
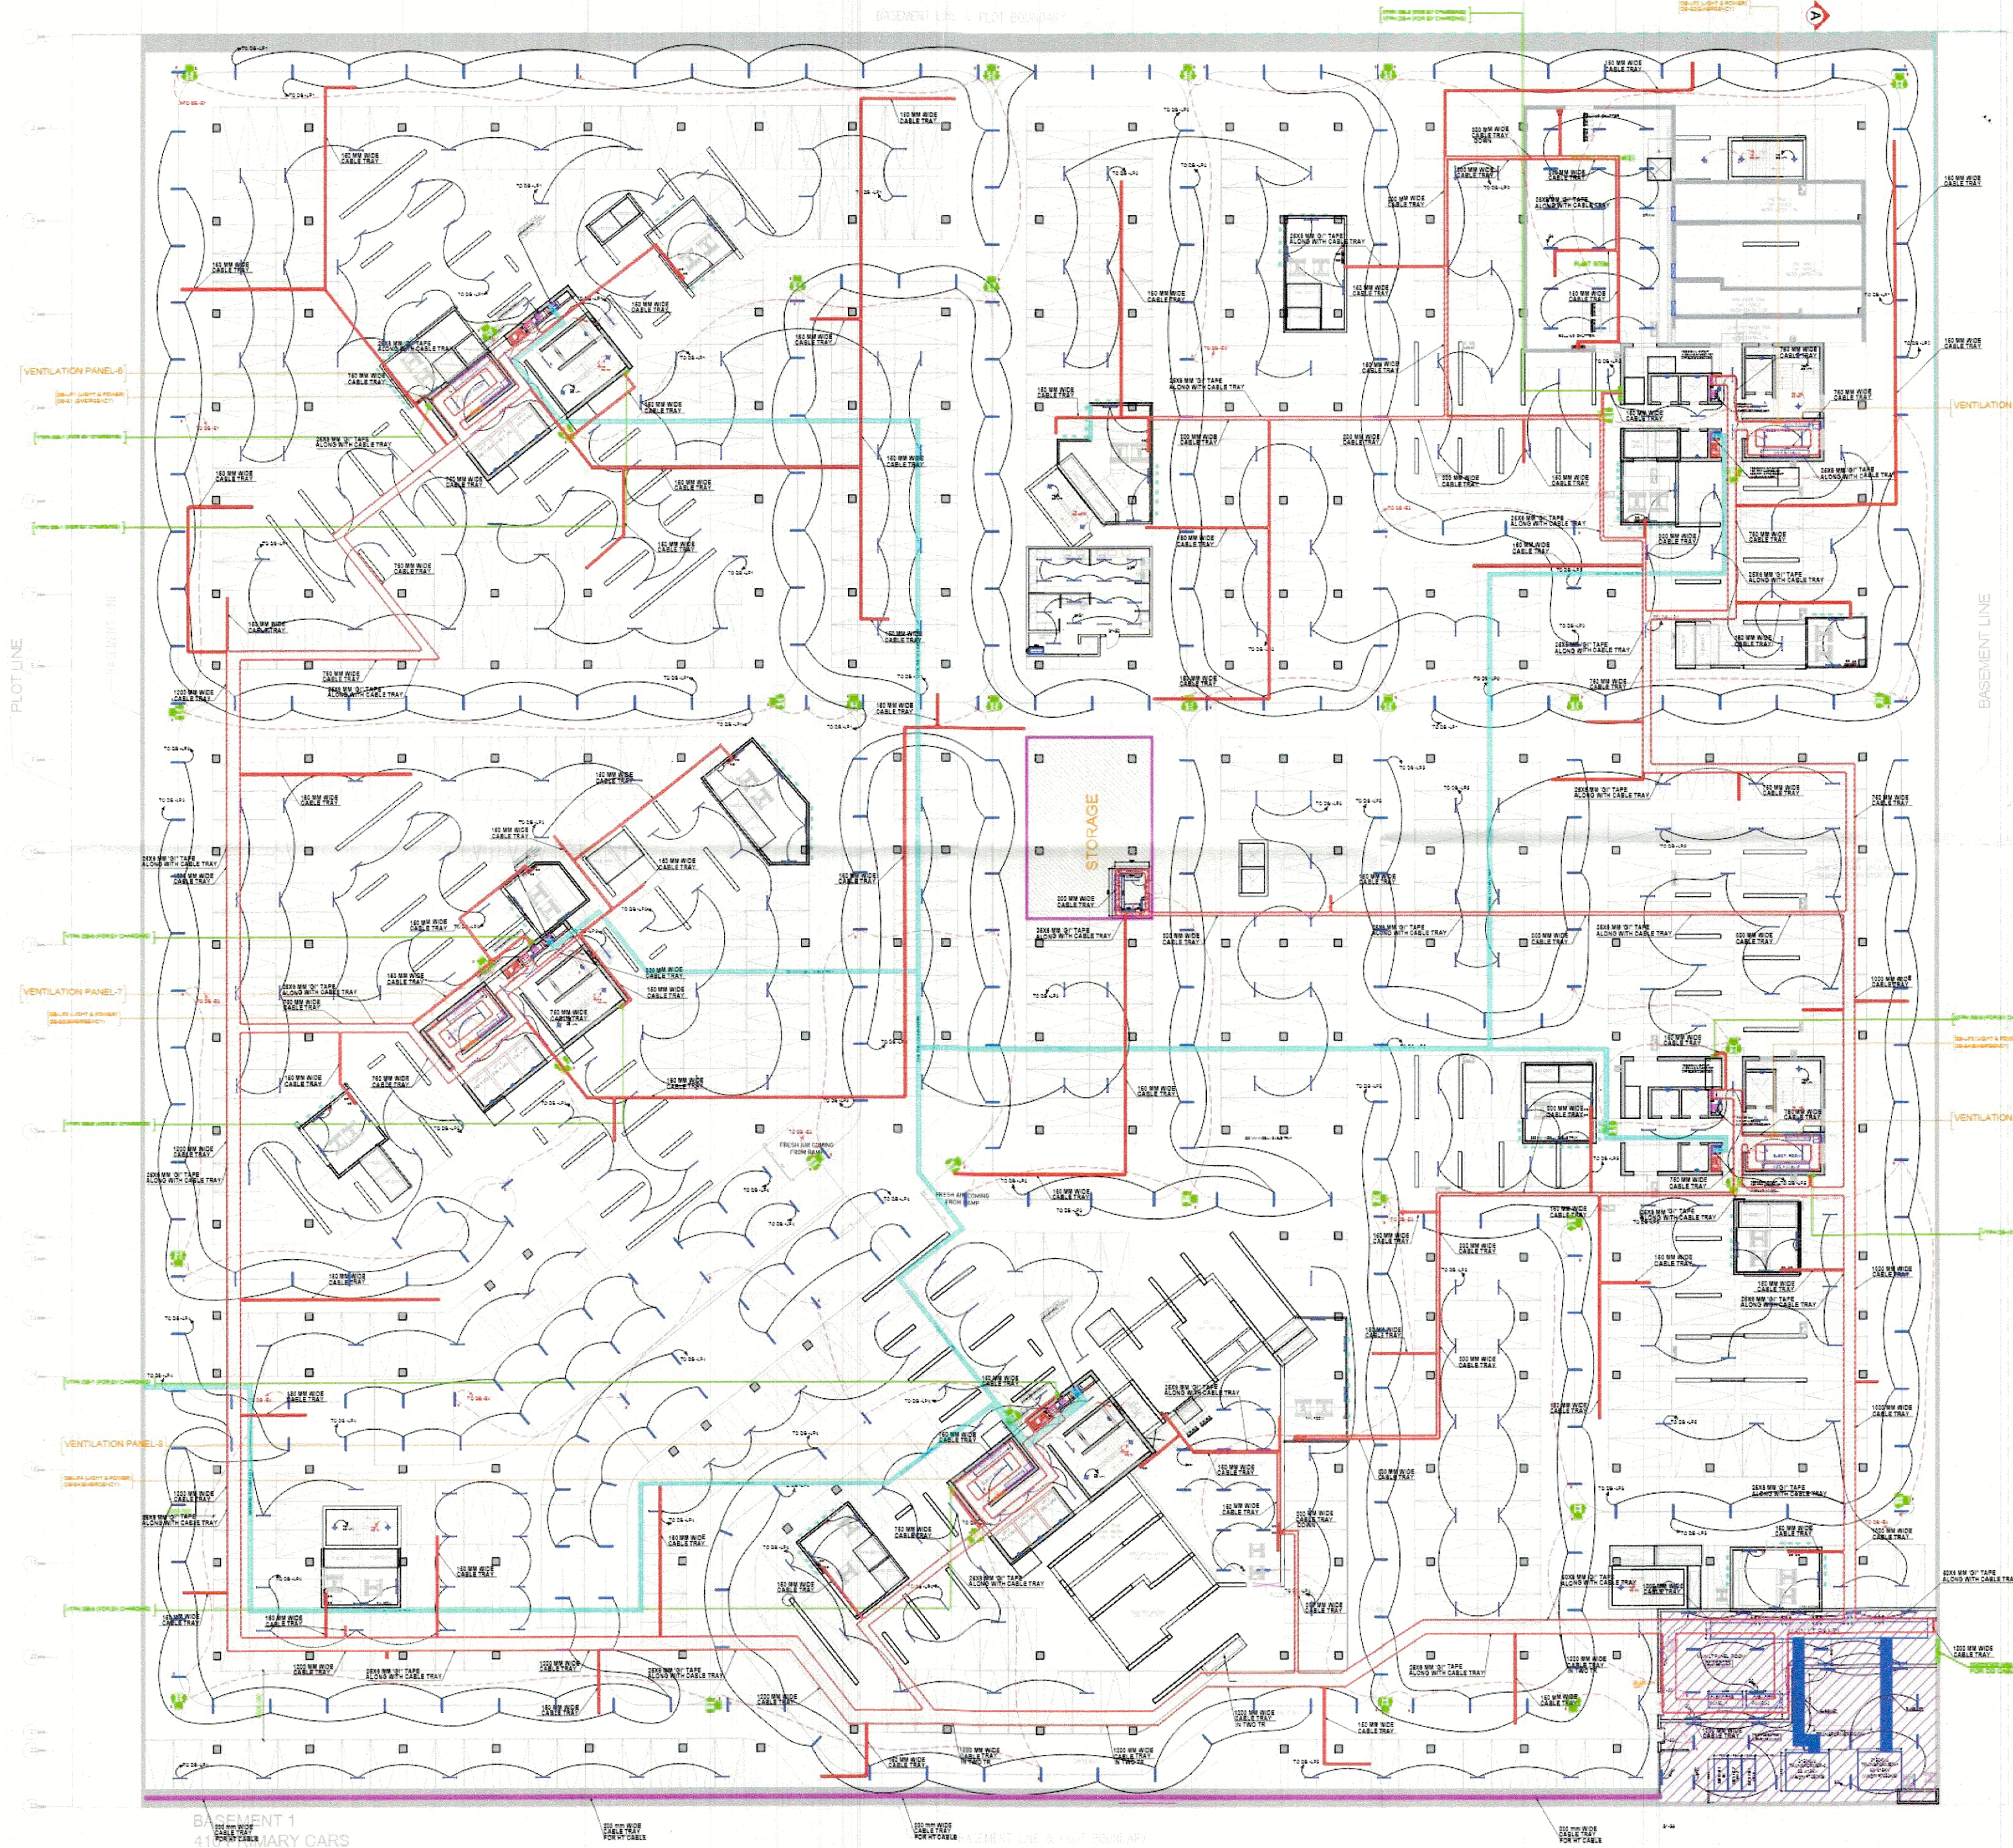


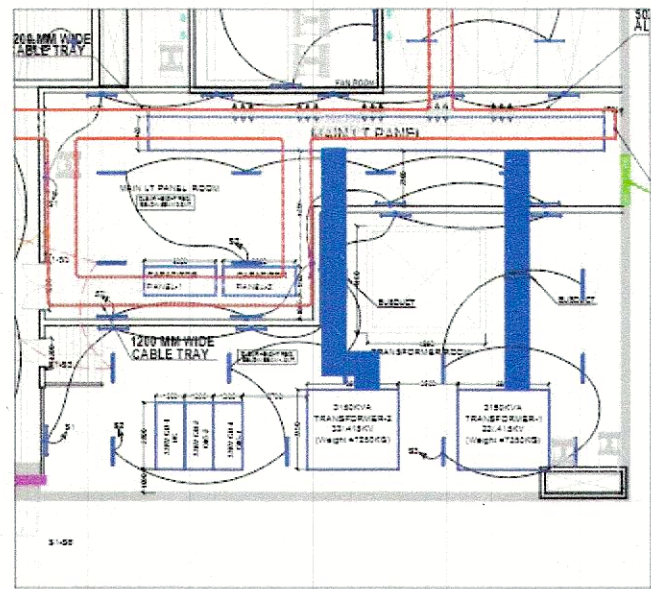


- LEGEND
- 2X22W LED LIGHT FIXTURE

Architect :
Wave Infratech Pvt. Ltd.
C-1, Sector-3
Noida, U.P. 201301
TEL: +91 120 4180500

MEP Consultant
ELECTRO
MEP CONSULTANTS
Find us: electromep.com
Reach us: projects@electromep.com
Talk to us: 011 41881394
Visit us: A222, Ground Floor & Lower Ground Floor
Shivalik Malviya Nagar, New Delhi - 110017

For Uppal Chadha Hi-Tech Developers Pvt. Ltd.
Niraj Kumar Nanda, Architect
Council of Architecture
Registration No. CA/2009/46122

- LEGEND :-
- 1. LADDER TYPE CABLE TRAY IN CEILING FOR LT CABLE
 - 2. PERFORATED TYPE CABLE TRAY IN CEILING FOR LV CABLE
- NOTE:-
- 1. PERFORATED TYPE CABLE TRAY 300MM & 150 MM CABLE TRAY FOR POWER CABLE
 - 2. LADDER TYPE CABLE TRAY 450MM & ABOVE CABLE TRAY FOR POWER CABLE

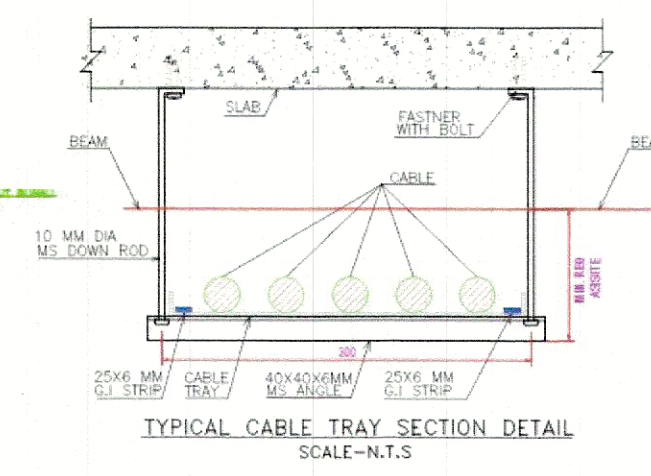

Structure Consultant

Landscape Consultant


OWNER
UPPAL CHADHA HITECH DEVELOPERS PVT. LTD.

PROJECT
PROPOSED GROUP HOUSING (VH) AT PLOT NO. GH02 PH04 A, AT WAVE CITY NH-24 GHAZIABAD (UP)

REV. NO. DESCRIPTION DATE

TITLE
BASEMENT -1 PLAN ELECTRICAL LAYOUT

DRAWN DUSHYANT DWG. NO. REV. NO.
C/D ANIL
SCALE 1:175
DATE 09.03.2028 EL-VH-10101 R0

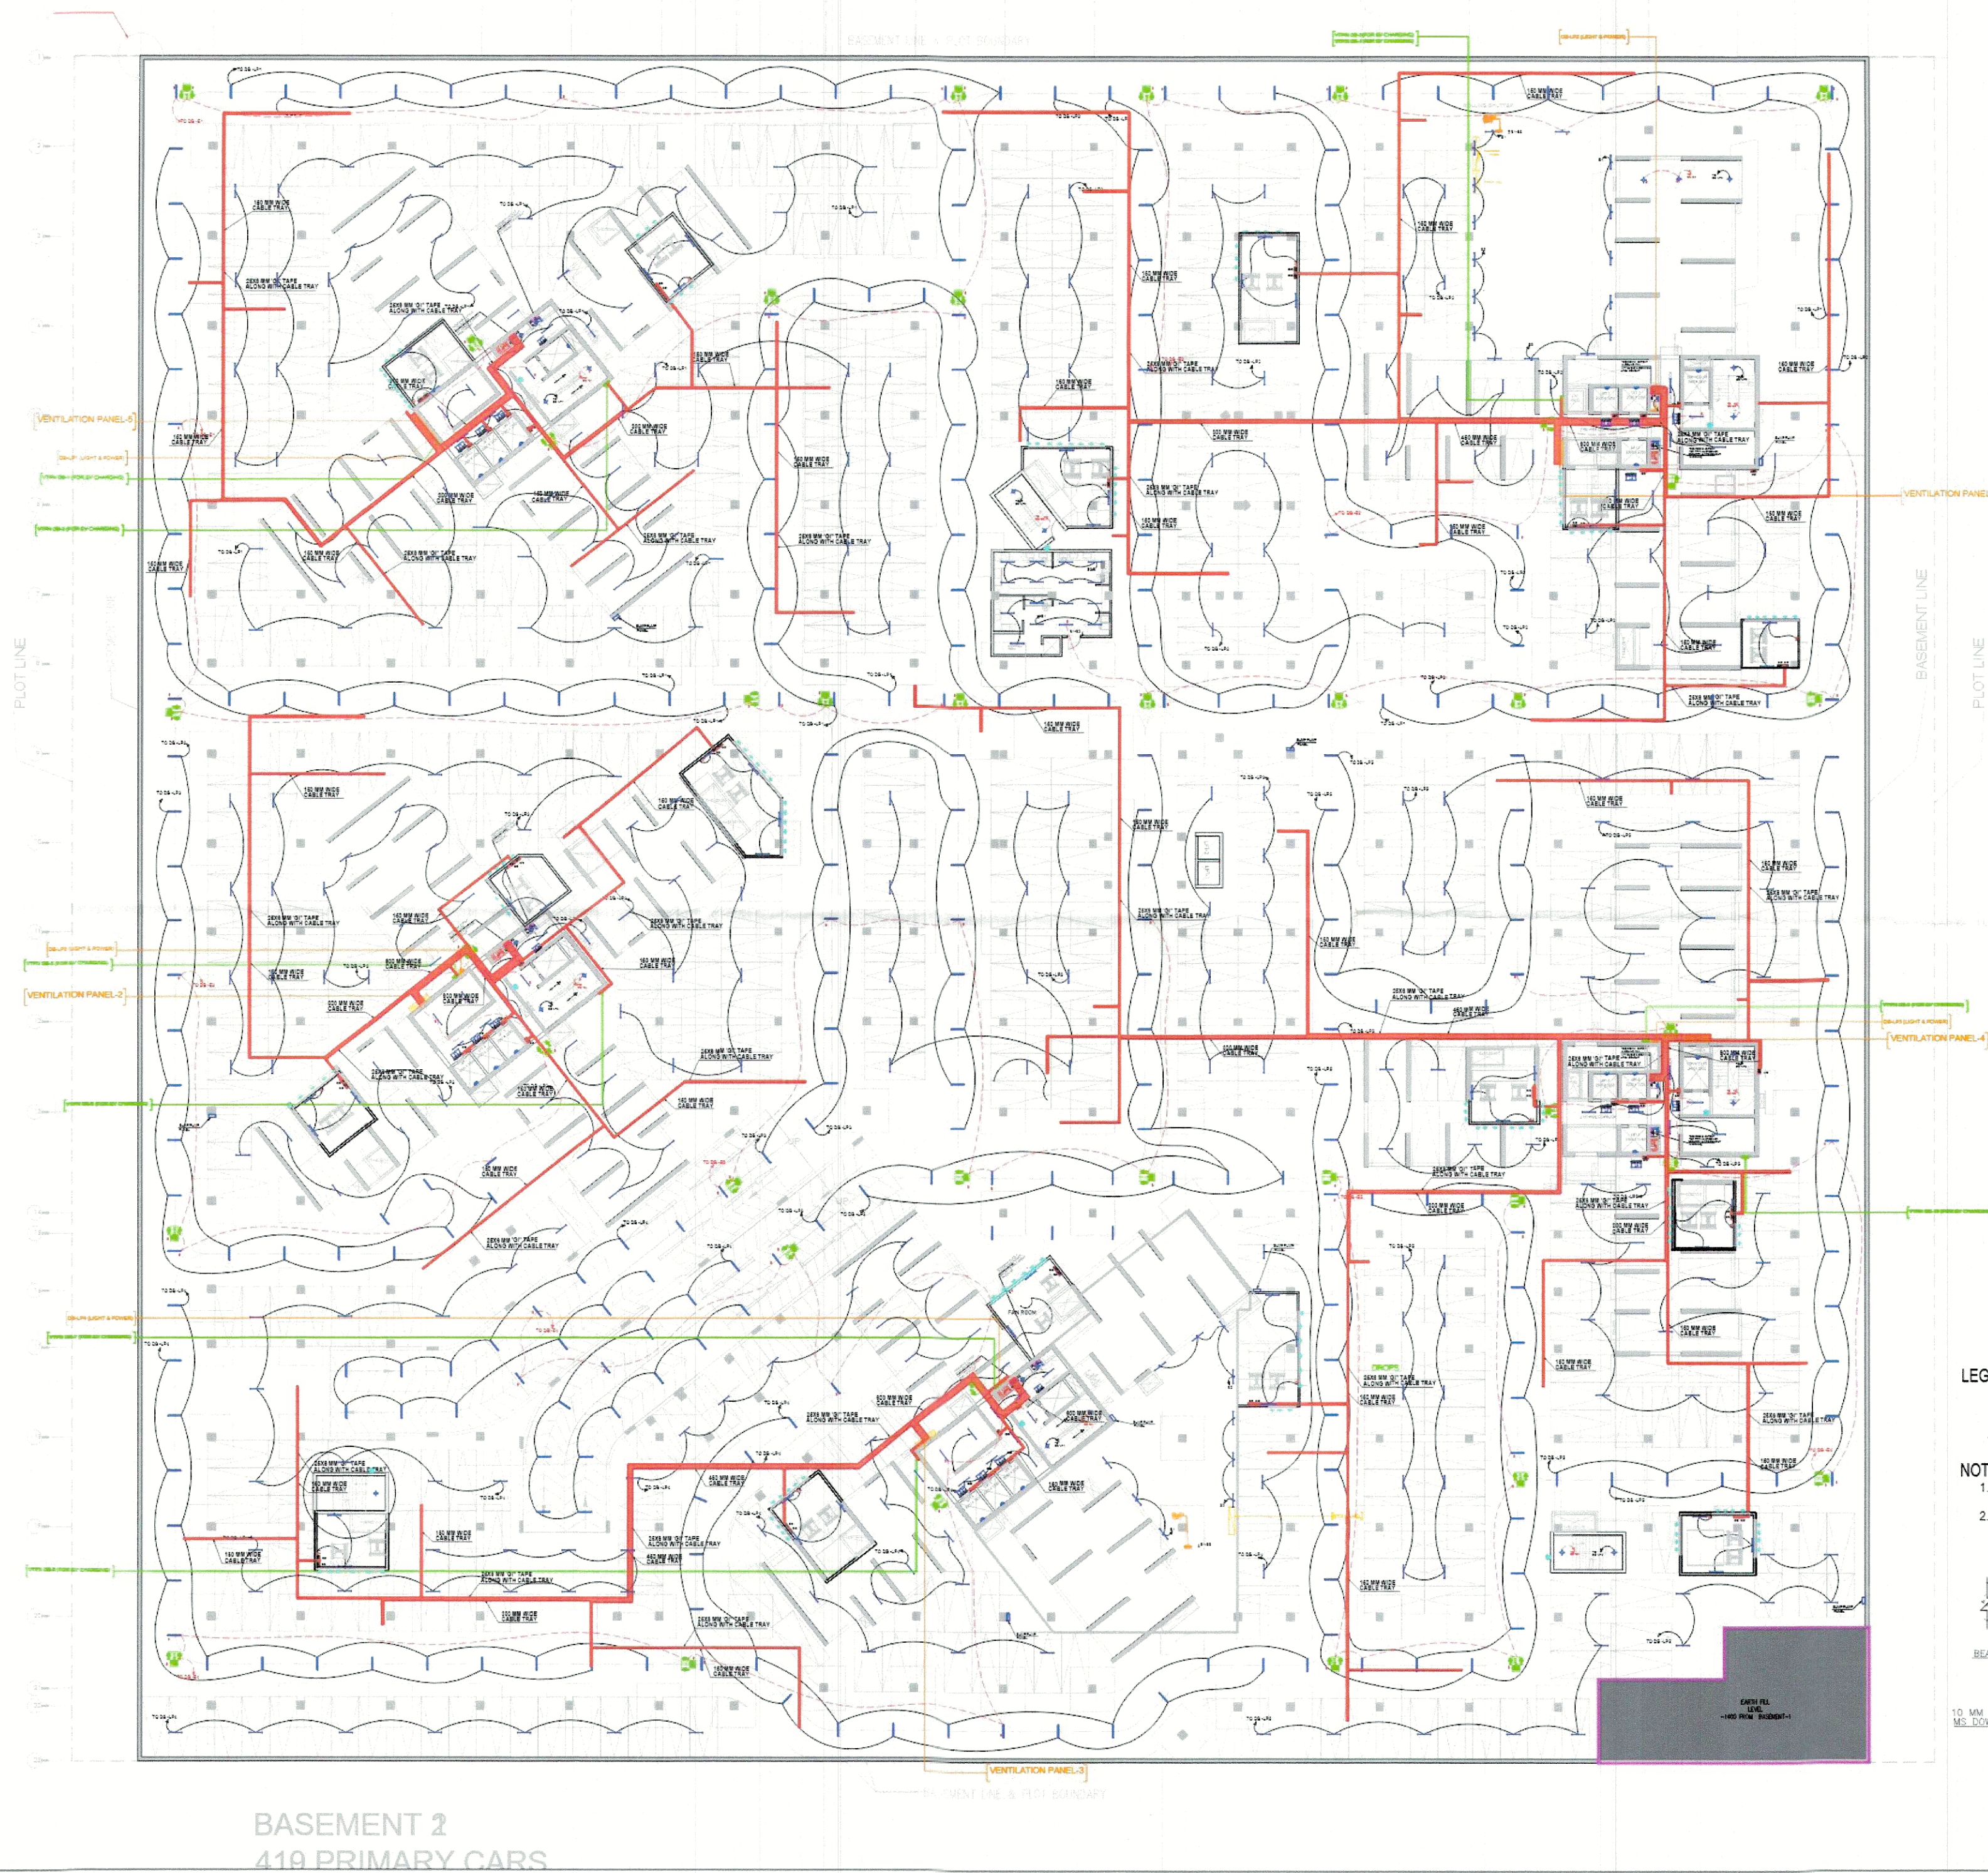

For Uppal Chadha Hi-Tech Developers Pvt. Ltd.

Niraj Kumar Nanda, Architect
Council of Architecture
Registration No. CA/219/2012

LEGEND

2X22W LED LIGHT FIXTURE

Architect :

Wave Infratech Pvt. Ltd.
C-1, Sector-3
Noida, U.P. 201301
TEL: +91 120 4180500

MEP Consultant

ELECTRO
MEP CONSULTANTS

Find us: electromep.com
Reach us: projects@electromep.com
Talk to us: 011 41881394
Visit us: A222, Ground Floor & Lower Ground Floor
Shivalki Malviya Nagar, New Delhi - 110017

Structure Consultant

Landscape Consultant

OWNER

UPPAL CHADHA HITECH DEVELOPERS
PVT. LTD.

PROJECT: PROPOSED GROUP HOUSING (VH)
AT PLOT NO. GH02 PH04 A, AT WAVE CITY
NH-24 GHAZIABAD (UP)

REV. NO.	DESCRIPTION	DATE
TITLE	BASEMENT -2 PLAN ELECTRICAL LAYOUT	

DRAWN	DUSHYANT	DWG NO.	REV. NO.
CAD	ANIL		
SCALE	1:125	EL-VH(E2)-1018	R0
DATE	03.03.2028		
PURPOSE			