


LEGEND FOR PLUMBING	
Red square	MANHOLE FOR SEWER
Blue square	DRAINAGE MANHOLE
Red line	SEWERAGE PIPE
Blue line	DRAINAGE PIPE

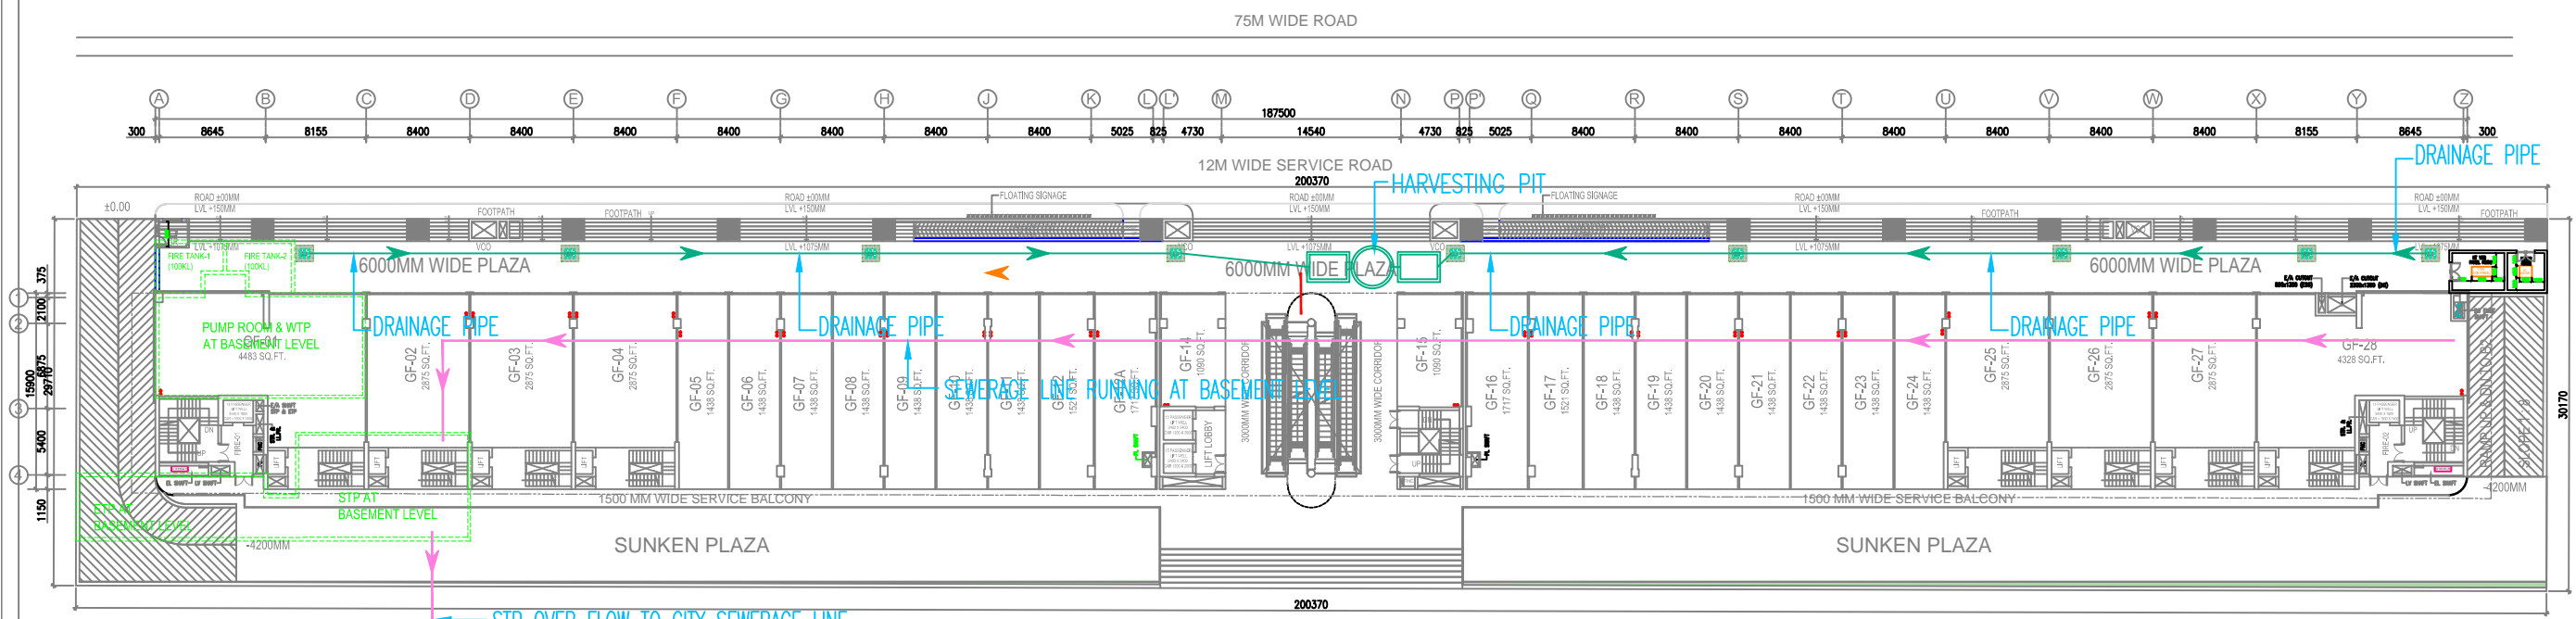

**GROUND FLOOR PLAN (+1200)**

<p><b>NOTES:-</b></p> <ol style="list-style-type: none"> <li>1. ALL DIMENSIONS ARE IN MM.</li> <li>2. ALL DIMENSIONS ARE TO BE READ AND NOT MEASURED.</li> <li>3. ANY DISCREPANCIES MUST BE BROUGHT TO THE NOTICE OF THE CONSULTANT BEFORE EXECUTION OF WORK AT SITE.</li> <li>4. THIS DRAWING MUST BE READ IN CONJUNCTION WITH ALL RELEVANT ARCHITECTURAL, STRUCTURAL, PLUMBING, FIRE FIGHTING AND ELECTRICAL DRAWINGS.</li> <li>5. THIS DRAWING IS THE SOLE PROPERTY OF MODARCHINDIA. IT SHOULD NOT BE USED/COPIED/REPRODUCED IN ANY MANNER WITHOUT THE PRIOR PERMISSION OF MODARCHINDIA.</li> <li>6. ARCHITECTURAL DRAWING SHOULD BE FOLLOWED FOR ALL DIMENSIONS &amp; LEVELS.</li> </ol>	<p><b>STRUCTURE CONSULTANT :-</b></p> <p><b>VINECH</b> CONSULTANTS CONSULTING ENGINEERS &amp; PROJECT MANAGERS</p> <p>C-95, PAMPONA ENCLAVE GATE NO. 3/3/4/5 - 1 NEW DELHI - 110048 TEL: 48141814, 48141815 FAX: 48141817 e-mail: v@vcon.co.in</p>	<p><b>MEP CONSULTANT:-</b></p> <p><b>V</b> Consulting</p> <p>B-50, Basement, Soami Nagar New Delhi-110017 Tel No: 011-49848197 &amp; 49849205 Email: info@vconsulting.co.in</p>	<p><b>PROJECT:-</b></p> <p>PROPOSED COMMERCIAL BUILDING AT PLOT NO.COMM.-04, SECTOR-50, NOIDA (U.P.)</p>	<p><b>OWNER:-</b></p> <p>M/S WESTWAY CITY CENTRE LLP NOIDA</p>	<p><b>ARCHITECT:-</b></p> <p><b>modarchindia</b> architects interior designers &amp; planners studio: 1st floor, B-99, sector-63, Noida -201301, U.P. phone: 0120-4206253, email: amitgargal@hotmail.com website: www.modarch.in</p>	<p><b>KEY PLAN</b></p> <p>SCALE: - N.T.S</p>	<p><b>DRAWING TITLE:-</b></p> <p>SITE PLAN DRAINAGE &amp; SEWERAGE LAYOUT</p> <table border="1"> <tr> <td>CHECKED BY</td> <td>V.N.</td> <td>DRAWN BY</td> <td>A.B.</td> </tr> <tr> <td>APPROVED BY</td> <td>V.N.</td> <td>DATE:-21/08/2023</td> <td>SCALE:- 1:250</td> </tr> <tr> <td colspan="3">DRAWING NO.- M/SITE01</td> <td>REVISION- RD</td> </tr> </table>	CHECKED BY	V.N.	DRAWN BY	A.B.	APPROVED BY	V.N.	DATE:-21/08/2023	SCALE:- 1:250	DRAWING NO.- M/SITE01			REVISION- RD
CHECKED BY	V.N.	DRAWN BY	A.B.																
APPROVED BY	V.N.	DATE:-21/08/2023	SCALE:- 1:250																
DRAWING NO.- M/SITE01			REVISION- RD																