




KEY PLAN

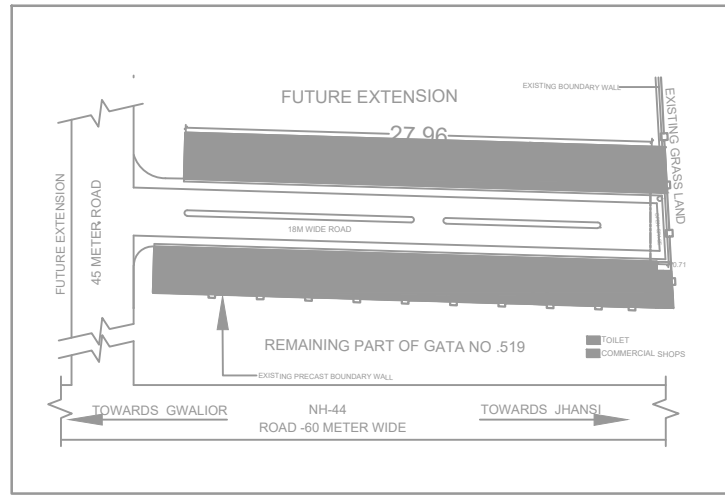

SITE PLAN

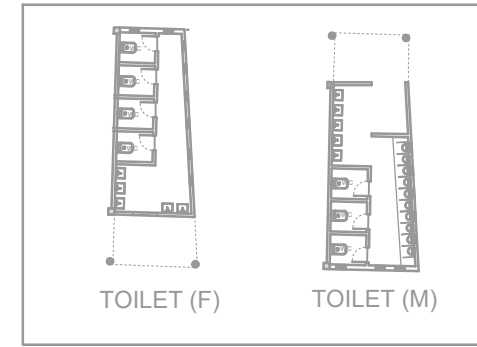

TOILET BLOCK

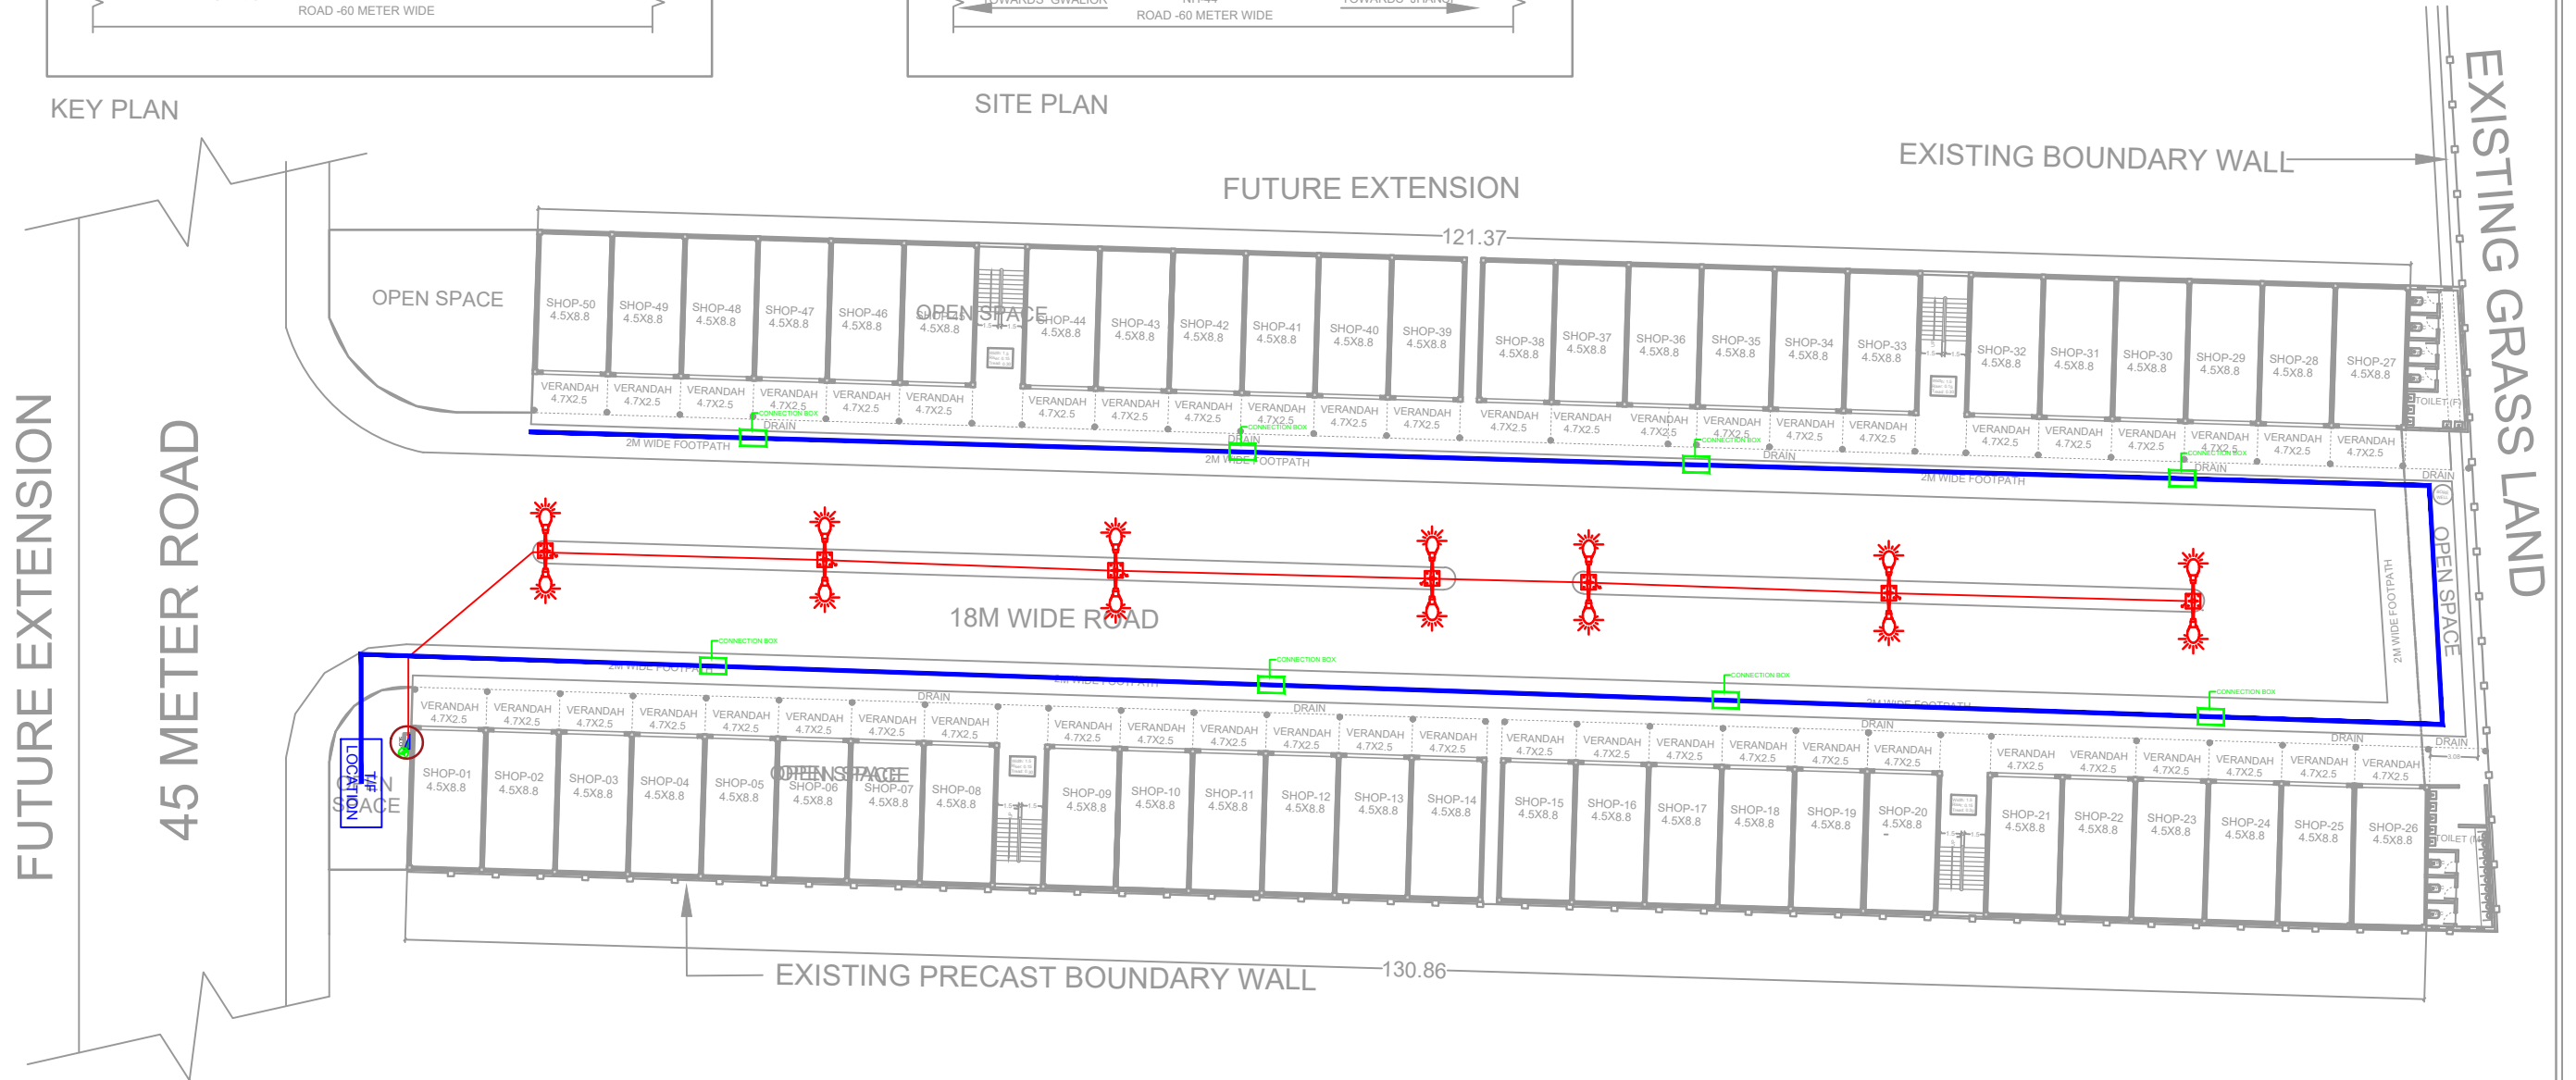

JHANSI DEVELOPMENT AUTHORITY
 Infront of, Commissionary Compound,
 Circuit House Rd, Gwal Toli, Jhansi,
 Uttar Pradesh 284003

PROJECT NAME:
 PROPOSED 50 SHOPS AT
 TRANSPORT NAGAR PHASE-1,
 JHANSI

DRAWING TITLE:
 STREET LIGFHT & ELECTRICITY
 SUPPLY LAYOUT PLAN

DATE: **SCALE:**
 N.T.S.



Electrical Legend:

Symbol	Description
	7 Mtr. DOUBLE ARM STREET LIGHT POLE WITH 120 WATT LED STREET LIGHT
	UNDERGROUND CABLE FOR STREET LIGHT
	UNDER GROUND LT LINE FOR DESTRIIBUTION
	TRANSFORMER LOCATION
	STREET LIGHT CUBICAL PANEL WITH EARTHING

J.E.	A.E.	E.E.
T.P.	SECRETARY	V.C.