


FIRST, SECOND, THIRD, FOURTH, FIFTH, SIXTH & SEVENTH FLOOR PLAN (SCALE 1:100)

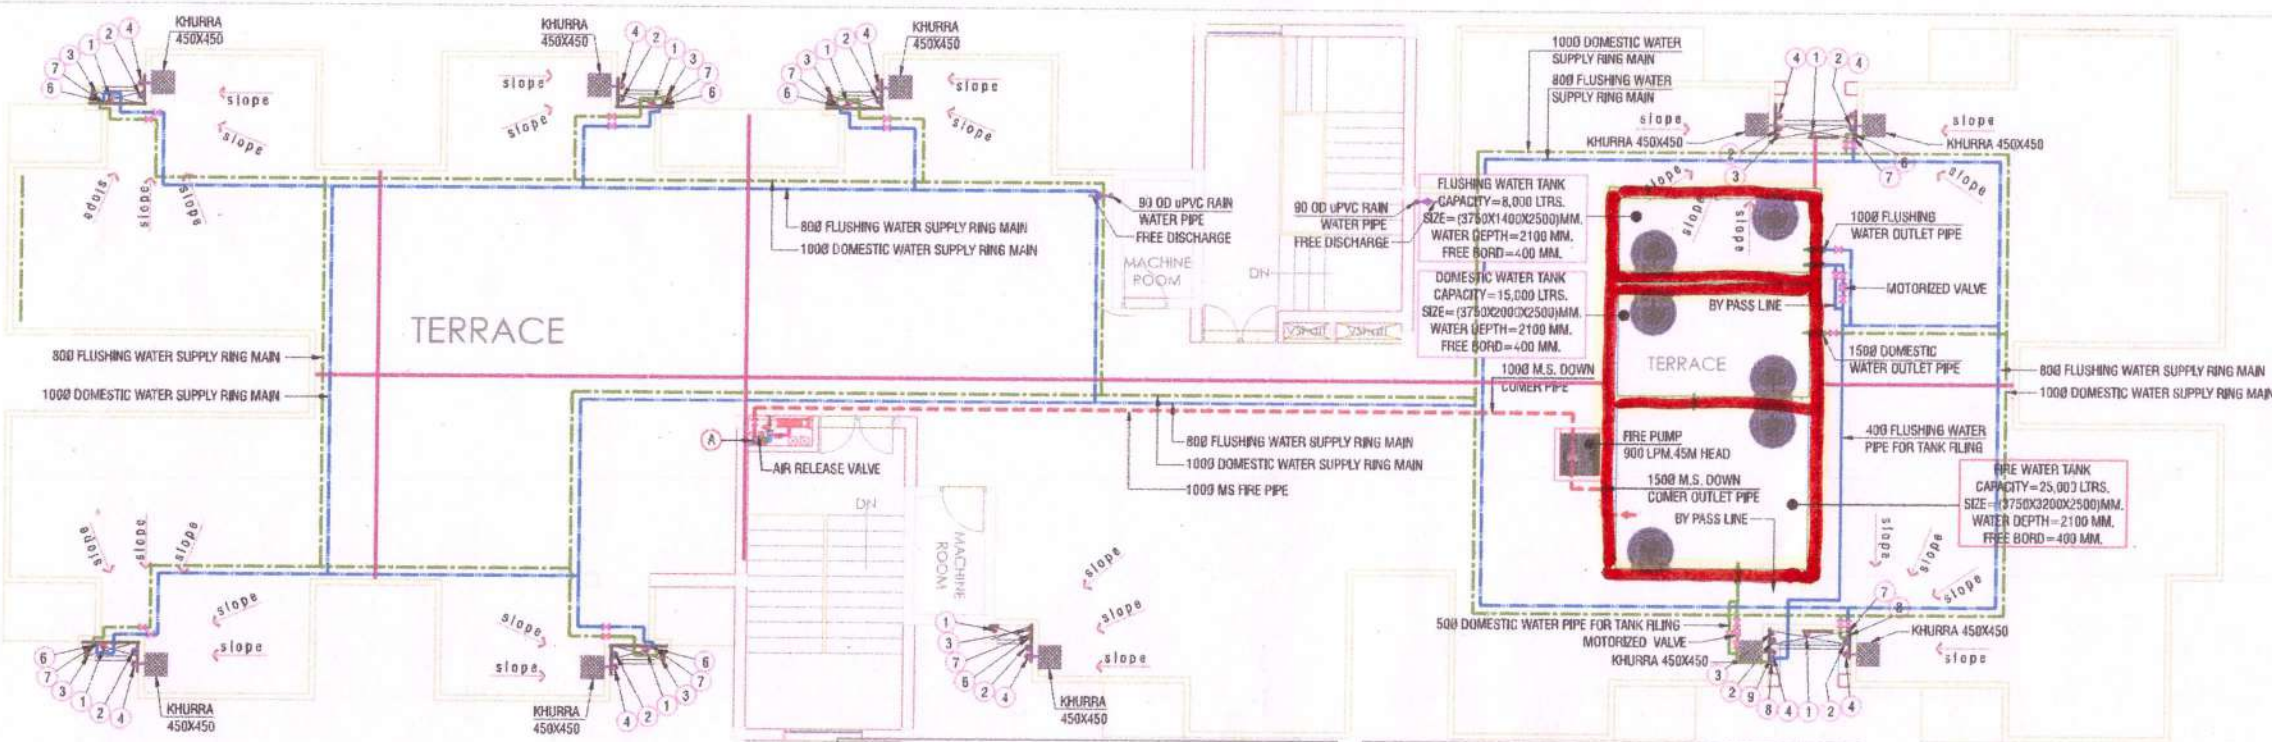

TERRACE PLAN (SCALE 1:100)

FIRE LEGEND :-

(A) 1000 M.S. DOWN COMER PIPE

HOSE REEL

IMPORTANT NOTES:-
(250 x 250)mm CUT OUT IN HOSE REEL.
1.) 1000 M.S. DOWN COMER PIPE

PLUMBING NOTES:

1. WASH BASIN TO FLOOR TRAP (FT) 40 OD uPVC PIPE.
2. KITCHEN SINK TO FLOOR TRAP (FT) uPVC FLEXIBLE PIPE.
3. FLOOR DRAIN (FD) TO FLOOR TRAP (FT) 63 OD uPVC WASTE PIPE.
4. 110 OD uPVC PIPE USED FOR SOIL & WASTE.
5. 160 OD uPVC PIPE USED FOR TERRACE RAIN WATER
6. 90 OD uPVC PIPE USED FOR BALCONY.

SCHEDULE OF PIPES :

PIPE NO.	DESCRIPTION
1	110 OD uPVC SOIL PIPE
2	110 OD uPVC WASTE PIPE
3	75 OD uPVC ANTI-SYPHONAGE PIPE
4	110 OD uPVC TERRACE RAIN WATER PIPE
5	90 OD uPVC TERRACE RAIN WATER PIPE
6	DOMESTIC WATER SUPPLY D/N TAKE PIPE*

7	FLUSHING WATER SUPPLY D/N TAKE PIPE*
8	DOMESTIC WATER SUPPLY RISER*
9	FLUSHING WATER SUPPLY RISER*
FT	FLOOR TRAP (110 x 110) MM,
FD	FLOOR DRAIN (110 x 63) MM
BD	BALCONY DRAIN (110 x 63) MM

ISSUES

NO.	DESCRIPTION	STATUS

REVISIONS

NO.	DESCRIPTION	DATE

PURPOSE OF DRAWING

G.F.C. TENDER

INFORMATION ONLY APPROVAL ONLY

ARCHITECT SIGN: _____ OWNER SIGN: _____

WORKING DRAWING

PROJECT:
PROPOSED MINI TOWNSHIP GORO COUNTY AT MADIYAD, LUCKNOW

CLIENT:
ORO COUNTY/DEV/W-01

ARCHITECT & ASSOCIATES:
espaces
A/c. SANJAY KR. GUPTA
108, CORPORATE CHAMBER-4,
VIBHUTI KHAND, GOMTI NAGAR, LUCKNOW
Ph.No.- 4365958, 89415114989
small-espaces_arch@gmail.com

MEP CONSULTANTS:
PARADISE CONSULTANTS
PLOT NO. 96, POCKET-1, BASEMENT
JASOLA VIHAR NEW DELHI - 110025
PH+91-11-29943601, 41030619
E-mail: paradiseconsultants@gmail.com

DRAWING TITLE : EWS TYPICAL & TERRACE PLAN PLUMBING & FIRE LAYOUT

scale :	1:100 (A3)	drawn by :	AJAY
date :	24/09/2022	checked by :	UNSHU JM
project no :		approved by :	NEVER
drawing no :			

PL-PC-ORO-II-EWS-102

REVISION

NO.	
-----	--