


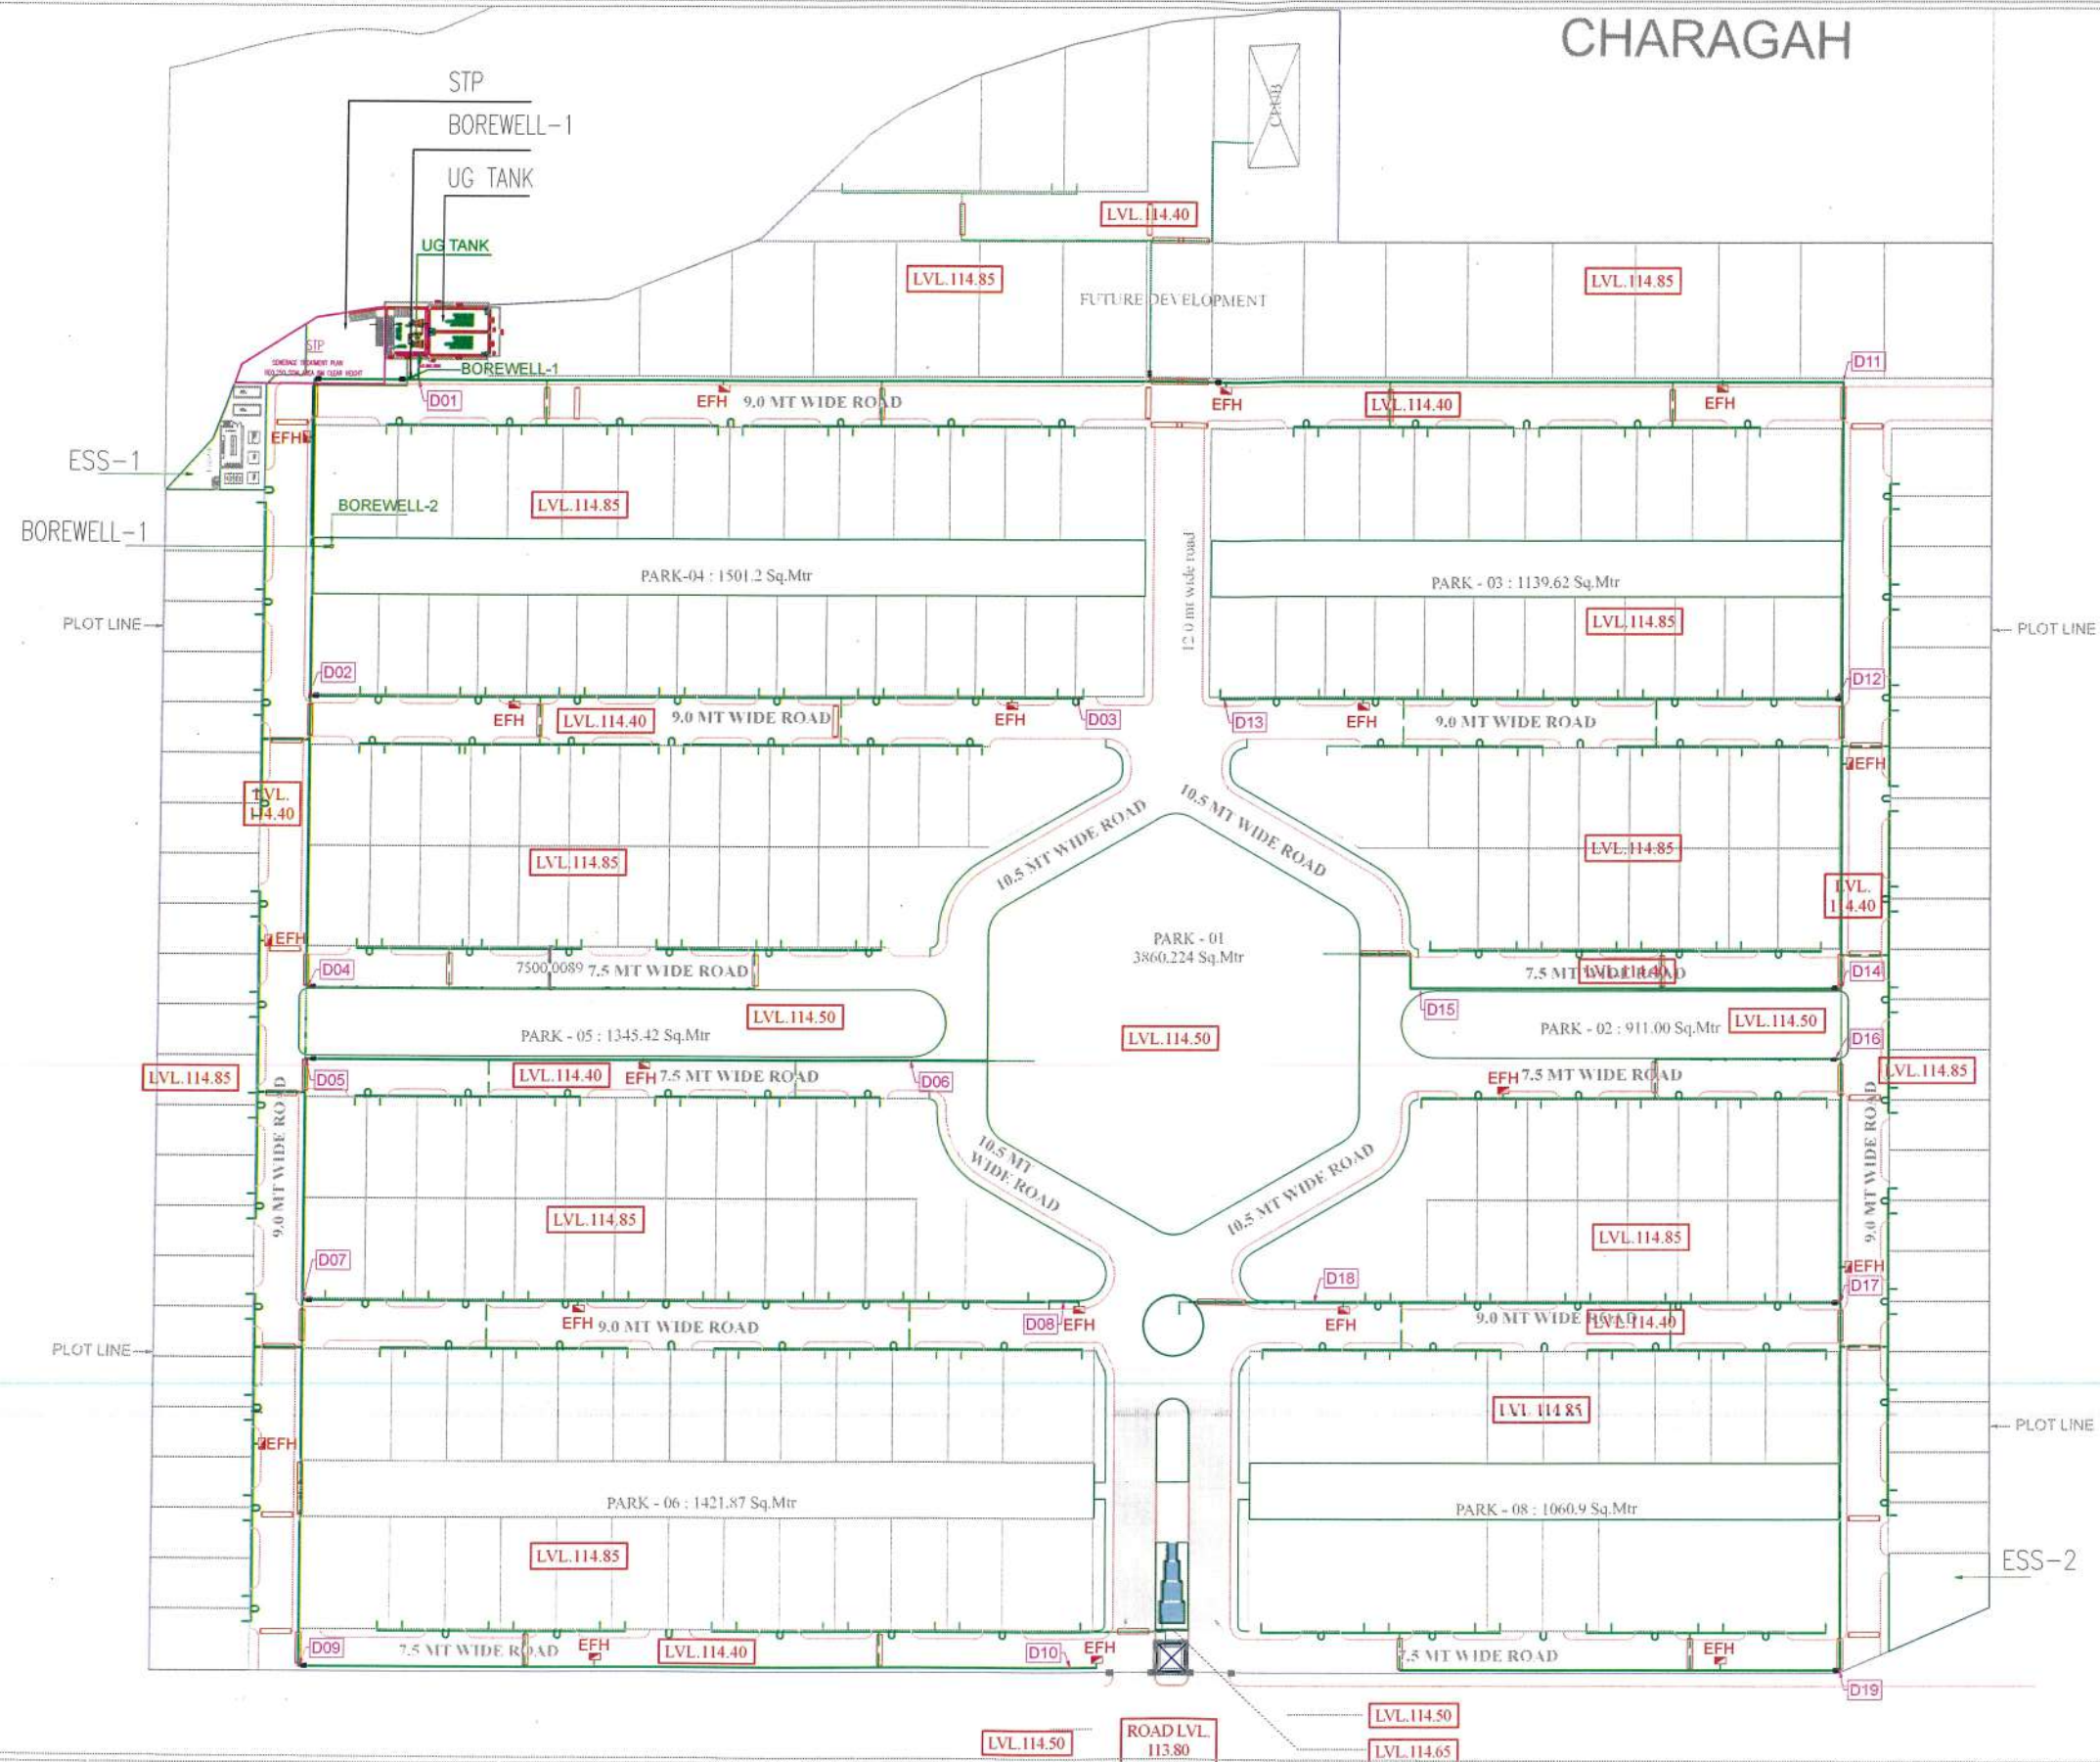

WATER SUPPLY LEGEND:-	
	VALVE
	DWS-DOMESTIC WATER SUPPLY(Ductile Iron K7)
	FWS-FLUSHING WATER SUPPLY(UPVC SH 80)
	R.C.C. HUME PIPE FOR ROAD CASING
	GARDEN HYDRANT
	FIRE HYDRANT
	AIR RELEASE VALVE

GOOD FOR CONSTRUCTION

NOTES:
1. ALL THE WORKS TO BE DONE AS PER THE SPECIFICATIONS AND STANDARDS OF THE BIDDING DOCUMENT.
2. THE CONTRACTOR SHALL BE RESPONSIBLE FOR OBTAINING ALL THE NECESSARY PERMITS AND APPROVALS FROM THE LOCAL AUTHORITIES.
3. THE CONTRACTOR SHALL MAINTAIN ACCESS TO ALL ADJACENT PROPERTIES AT ALL TIMES.
4. THE CONTRACTOR SHALL BE RESPONSIBLE FOR THE PROTECTION OF ALL EXISTING UTILITIES AND STRUCTURES.
5. THE CONTRACTOR SHALL MAINTAIN A RECORD OF ALL WORKS DONE AND SUBMIT IT TO THE ARCHITECT AT THE END OF THE PROJECT.

PROJECT
**AMBROSIA ESTATES
BBD GREEN CITY**

ARCHITECTS
jsr
architecture, interiors, pvt
Co.™ Defence colony New delhi
Phone: 011-40541981
Email: jsr1974@gmail.com

DRAWING TITLE
**SITE PLAN
DOMESTIC WATER SUPPLY
LAYOUT**

NO	REVISION	DATE	DESCRIPTION	Scale	1:600 @ A1
1				Date	21-07-2025
2				Drawn by	BHUMIKA
				Checked by	MANOJ
				Approved by	S.BEHERA
				PL-04	

Handwritten signature and date: 21/07/2025

For Viraj Constructions Pvt. Ltd.
For Viraj Constructions Pvt. Ltd.
Authorised Signatory