

Architect :
Wave Infratech Pvt. Ltd.
G-1 Sector-3
Noida, U.P. 201301
TEL: +91 120 4190500


Structure Consultant
K M H
ENGINEERING

MEP Consultant
ELECTRO CONSULTANTS

Interior, Facade &
Landscape

ULTRA CONFIDENTIAL

For Uppal Chadha Hi-Tech Developers Pvt. Ltd.

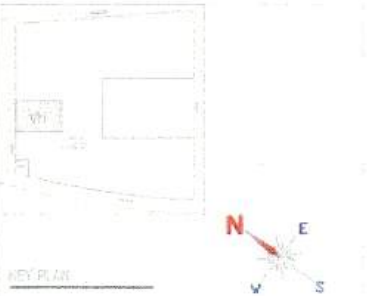

NO.	DESCRIPTION	REMARKS
1	1. TOILET AND BATH ROOMS	
2	2. KITCHEN AND BREAKFAST ROOM	
3	3. BED ROOMS	
4	4. LIVING ROOM AND DINING ROOM	
5	5. STUDY ROOM	
6	6. BALCONY	
7	7. TERRACE	
8	8. GARAGE	
9	9. STAIRS	
10	10. ELEVATOR	
11	11. COMMON AREA	
12	12. PARKING AREA	
13	13. LANDSCAPE	
14	14. FENCE	
15	15. GATE	
16	16. ROAD	
17	17. WATER SUPPLY	
18	18. SEWERAGE	
19	19. GAS	
20	20. ELECTRICAL	
21	21. TELEPHONE	
22	22. CABLE TV	
23	23. FIRE ALARM	
24	24. SECURITY	
25	25. MAINTENANCE	
26	26. STORAGE	
27	27. WASTE DISPOSAL	
28	28. LANDSCAPE	
29	29. FENCE	
30	30. GATE	
31	31. ROAD	
32	32. WATER SUPPLY	
33	33. SEWERAGE	
34	34. GAS	
35	35. ELECTRICAL	
36	36. TELEPHONE	
37	37. CABLE TV	
38	38. FIRE ALARM	
39	39. SECURITY	
40	40. MAINTENANCE	
41	41. STORAGE	
42	42. WASTE DISPOSAL	
43	43. LANDSCAPE	
44	44. FENCE	
45	45. GATE	
46	46. ROAD	
47	47. WATER SUPPLY	
48	48. SEWERAGE	
49	49. GAS	
50	50. ELECTRICAL	
51	51. TELEPHONE	
52	52. CABLE TV	
53	53. FIRE ALARM	
54	54. SECURITY	
55	55. MAINTENANCE	
56	56. STORAGE	
57	57. WASTE DISPOSAL	
58	58. LANDSCAPE	
59	59. FENCE	
60	60. GATE	
61	61. ROAD	
62	62. WATER SUPPLY	
63	63. SEWERAGE	
64	64. GAS	
65	65. ELECTRICAL	
66	66. TELEPHONE	
67	67. CABLE TV	
68	68. FIRE ALARM	
69	69. SECURITY	
70	70. MAINTENANCE	
71	71. STORAGE	
72	72. WASTE DISPOSAL	
73	73. LANDSCAPE	
74	74. FENCE	
75	75. GATE	
76	76. ROAD	
77	77. WATER SUPPLY	
78	78. SEWERAGE	
79	79. GAS	
80	80. ELECTRICAL	
81	81. TELEPHONE	
82	82. CABLE TV	
83	83. FIRE ALARM	
84	84. SECURITY	
85	85. MAINTENANCE	
86	86. STORAGE	
87	87. WASTE DISPOSAL	
88	88. LANDSCAPE	
89	89. FENCE	
90	90. GATE	
91	91. ROAD	
92	92. WATER SUPPLY	
93	93. SEWERAGE	
94	94. GAS	
95	95. ELECTRICAL	
96	96. TELEPHONE	
97	97. CABLE TV	
98	98. FIRE ALARM	
99	99. SECURITY	
100	100. MAINTENANCE	

NO.	DESCRIPTION	REMARKS
1	1. TOILET AND BATH ROOMS	
2	2. KITCHEN AND BREAKFAST ROOM	
3	3. BED ROOMS	
4	4. LIVING ROOM AND DINING ROOM	
5	5. STUDY ROOM	
6	6. BALCONY	
7	7. TERRACE	
8	8. GARAGE	
9	9. STAIRS	
10	10. ELEVATOR	
11	11. COMMON AREA	
12	12. PARKING AREA	
13	13. LANDSCAPE	
14	14. FENCE	
15	15. GATE	
16	16. ROAD	
17	17. WATER SUPPLY	
18	18. SEWERAGE	
19	19. GAS	
20	20. ELECTRICAL	
21	21. TELEPHONE	
22	22. CABLE TV	
23	23. FIRE ALARM	
24	24. SECURITY	
25	25. MAINTENANCE	
26	26. STORAGE	
27	27. WASTE DISPOSAL	
28	28. LANDSCAPE	
29	29. FENCE	
30	30. GATE	
31	31. ROAD	
32	32. WATER SUPPLY	
33	33. SEWERAGE	
34	34. GAS	
35	35. ELECTRICAL	
36	36. TELEPHONE	
37	37. CABLE TV	
38	38. FIRE ALARM	
39	39. SECURITY	
40	40. MAINTENANCE	
41	41. STORAGE	
42	42. WASTE DISPOSAL	
43	43. LANDSCAPE	
44	44. FENCE	
45	45. GATE	
46	46. ROAD	
47	47. WATER SUPPLY	
48	48. SEWERAGE	
49	49. GAS	
50	50. ELECTRICAL	
51	51. TELEPHONE	
52	52. CABLE TV	
53	53. FIRE ALARM	
54	54. SECURITY	
55	55. MAINTENANCE	
56	56. STORAGE	
57	57. WASTE DISPOSAL	
58	58. LANDSCAPE	
59	59. FENCE	
60	60. GATE	
61	61. ROAD	
62	62. WATER SUPPLY	
63	63. SEWERAGE	
64	64. GAS	
65	65. ELECTRICAL	
66	66. TELEPHONE	
67	67. CABLE TV	
68	68. FIRE ALARM	
69	69. SECURITY	
70	70. MAINTENANCE	
71	71. STORAGE	
72	72. WASTE DISPOSAL	
73	73. LANDSCAPE	
74	74. FENCE	
75	75. GATE	
76	76. ROAD	
77	77. WATER SUPPLY	
78	78. SEWERAGE	
79	79. GAS	
80	80. ELECTRICAL	
81	81. TELEPHONE	
82	82. CABLE TV	
83	83. FIRE ALARM	
84	84. SECURITY	
85	85. MAINTENANCE	
86	86. STORAGE	
87	87. WASTE DISPOSAL	
88	88. LANDSCAPE	
89	89. FENCE	
90	90. GATE	
91	91. ROAD	
92	92. WATER SUPPLY	
93	93. SEWERAGE	
94	94. GAS	
95	95. ELECTRICAL	
96	96. TELEPHONE	
97	97. CABLE TV	
98	98. FIRE ALARM	
99	99. SECURITY	
100	100. MAINTENANCE	

TOWER (5)-A1
STILT to 28th FLOOR
COORDINATE FOR
AT TOWER

For Uppal Chadha Hi-Tech Developers Pvt. Ltd.
Niraj Kumar Nanda, Architect
Council of Architecture
Registration No. CA/239346/20


DATE: 28.12.2018
DRAWN: SS
CHECKED: AK
DATE: 28.12.2018

General Notes:
1. DO NOT SCALE FROM THE DRAWINGS
2. ALL DIMENSIONS ARE IN METERS AND UNLESS OTHERWISE SPECIFIED, ALL DIMENSIONS TO BE AS SHOWN ON THE DRAWINGS
3. ALL DIMENSIONS TO BE IN CONJUNCTION WITH THE ELECTRICAL AND MECHANICAL DRAWINGS AND TO BE IN CONJUNCTION WITH THE ARCHITECTURAL DRAWINGS
4. ALL DIMENSIONS TO BE IN CONJUNCTION WITH THE ARCHITECTURAL DRAWINGS
5. ALL DIMENSIONS TO BE IN CONJUNCTION WITH THE ARCHITECTURAL DRAWINGS
6. ALL DIMENSIONS TO BE IN CONJUNCTION WITH THE ARCHITECTURAL DRAWINGS
7. ALL DIMENSIONS TO BE IN CONJUNCTION WITH THE ARCHITECTURAL DRAWINGS
8. ALL DIMENSIONS TO BE IN CONJUNCTION WITH THE ARCHITECTURAL DRAWINGS
9. ALL DIMENSIONS TO BE IN CONJUNCTION WITH THE ARCHITECTURAL DRAWINGS
10. ALL DIMENSIONS TO BE IN CONJUNCTION WITH THE ARCHITECTURAL DRAWINGS

Signature
For Uppal Chadha Hi-Tech Developers Pvt. Ltd.

SITE PLAN
WASTE DISPOSAL LAYOUT

PL-VH(SITE)-1020

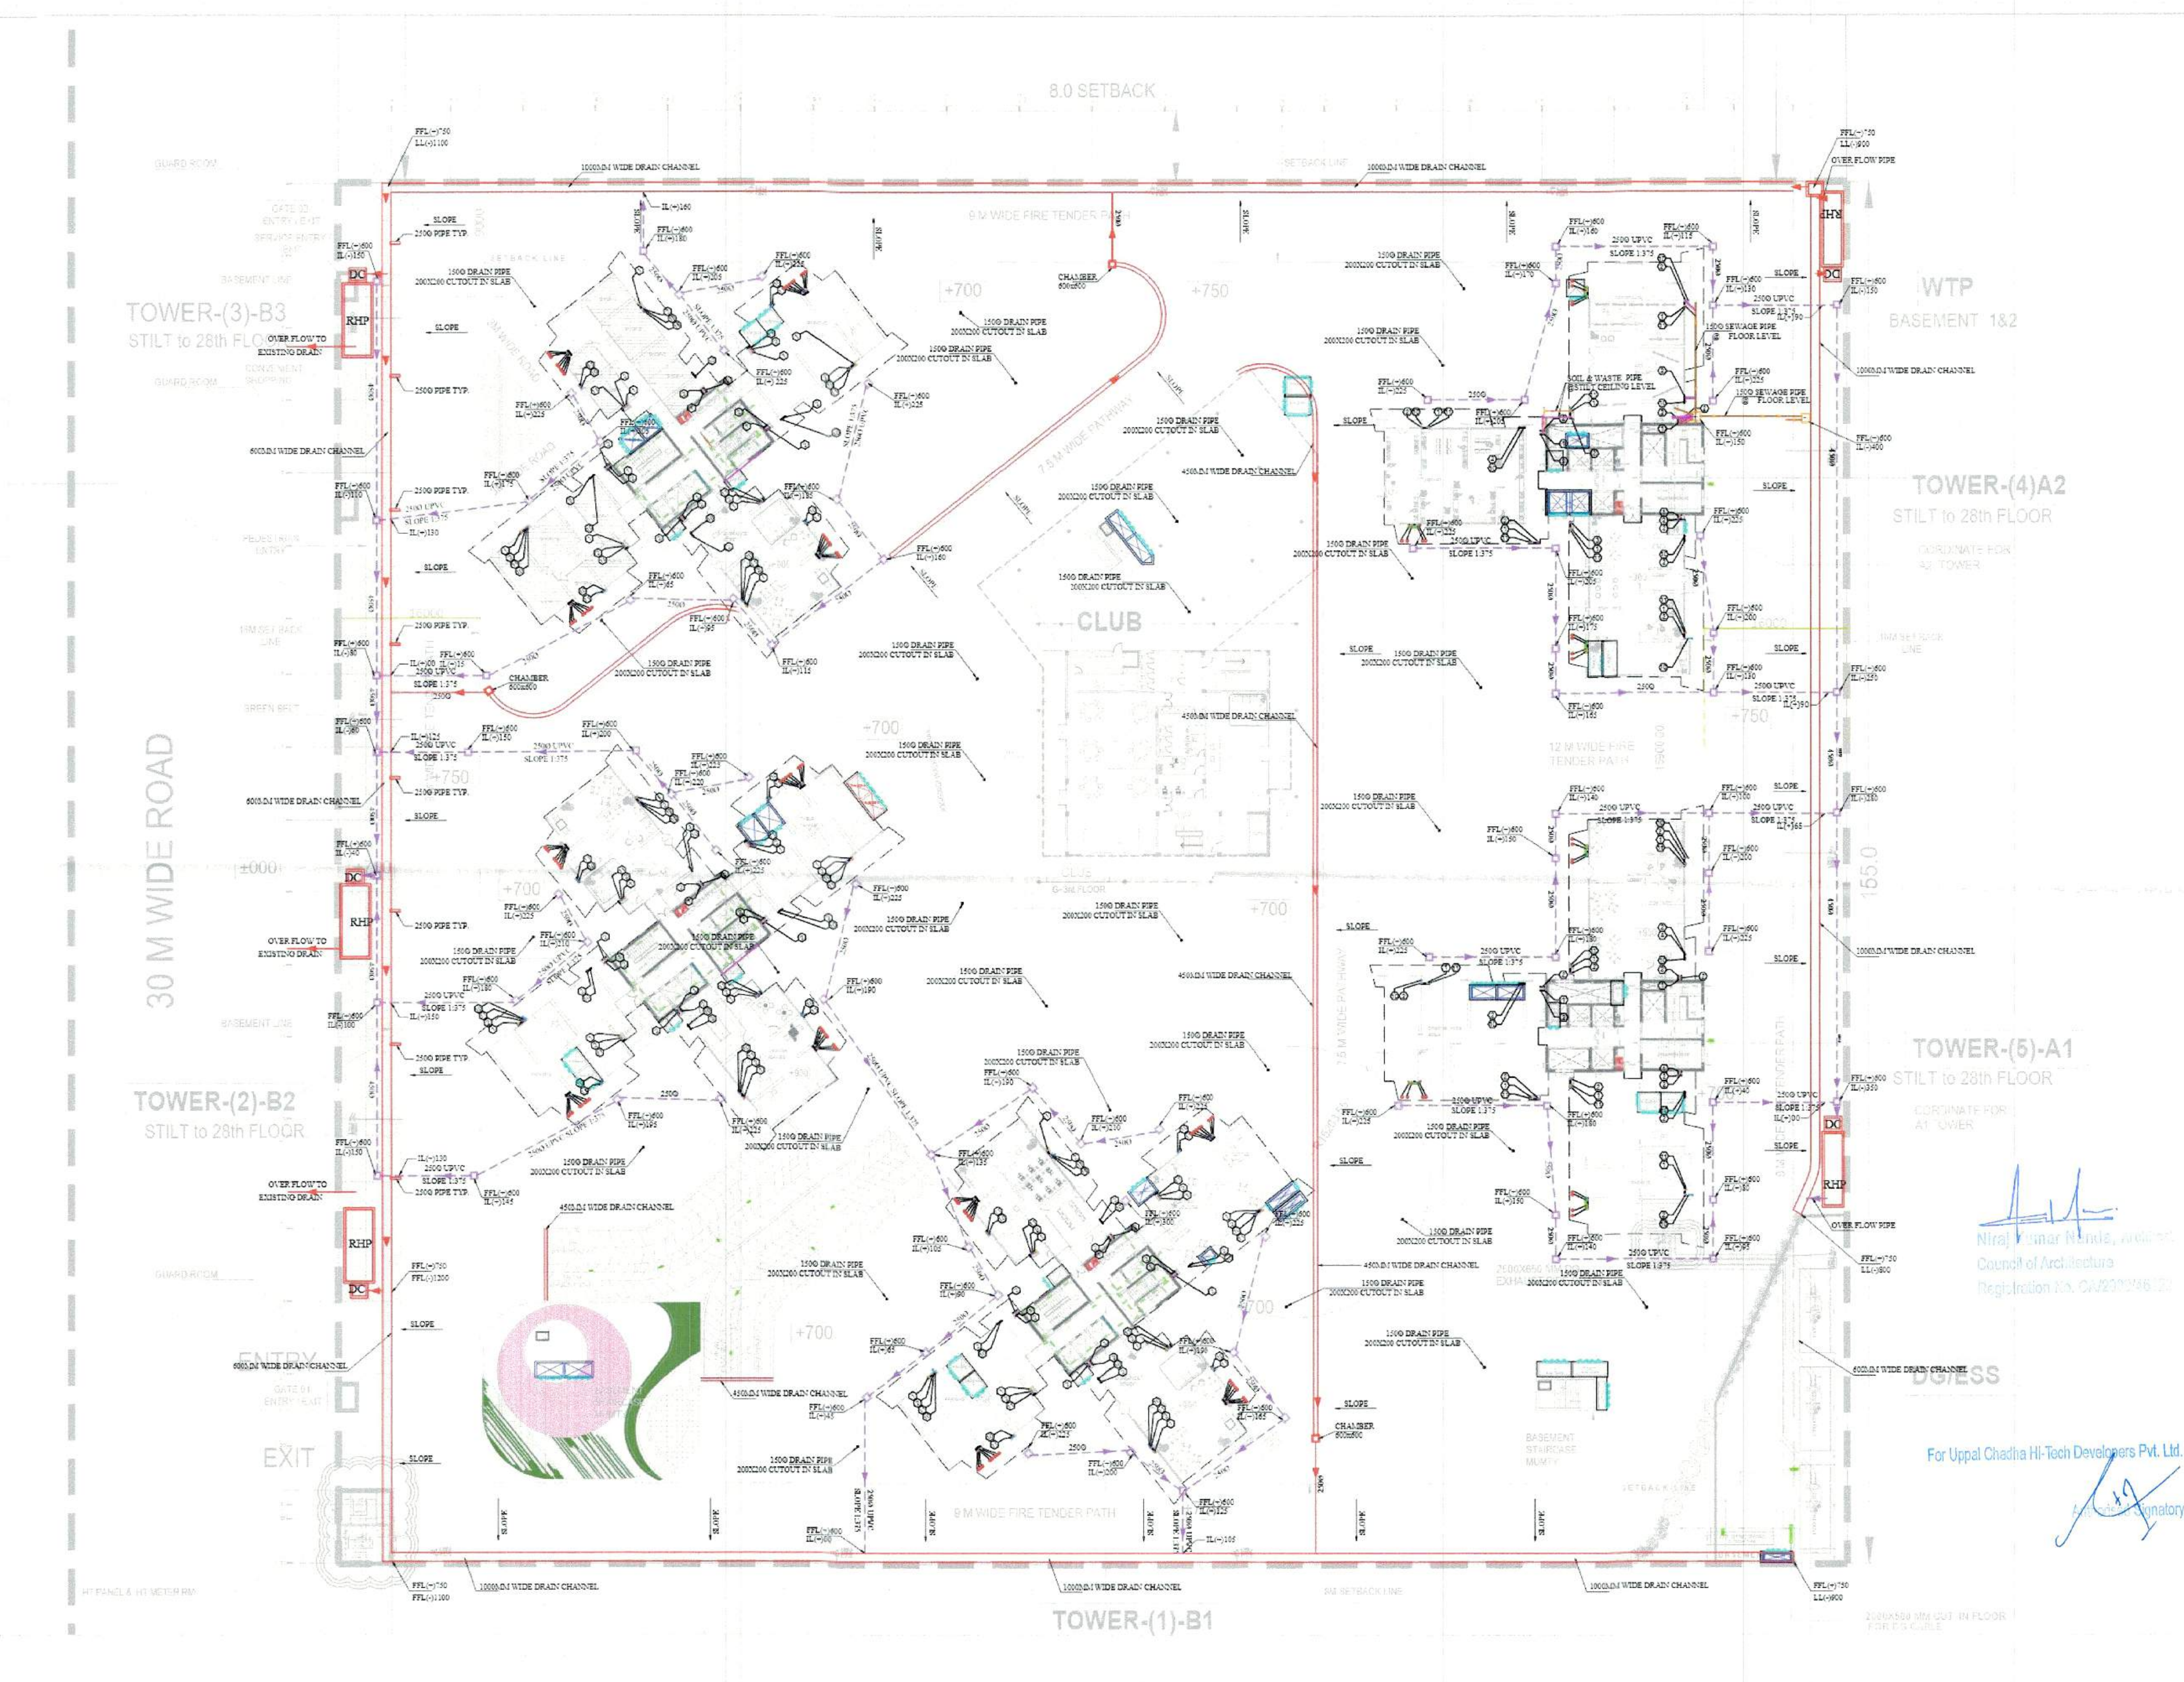

This drawing is subject to copyright and may not be copied, used or reproduced in any way without the express permission of WAVE Infratech. This document should not be used in any way without the express permission of WAVE Infratech. WAVE Infratech accepts no responsibility for this document to any other party other than the person by whom it was commissioned.

