


FUTURE EXTENSION


EXISTING BOUNDARY WALL

EXISTING GRASS LAND

FUTURE EXTENSION
45 METER ROAD

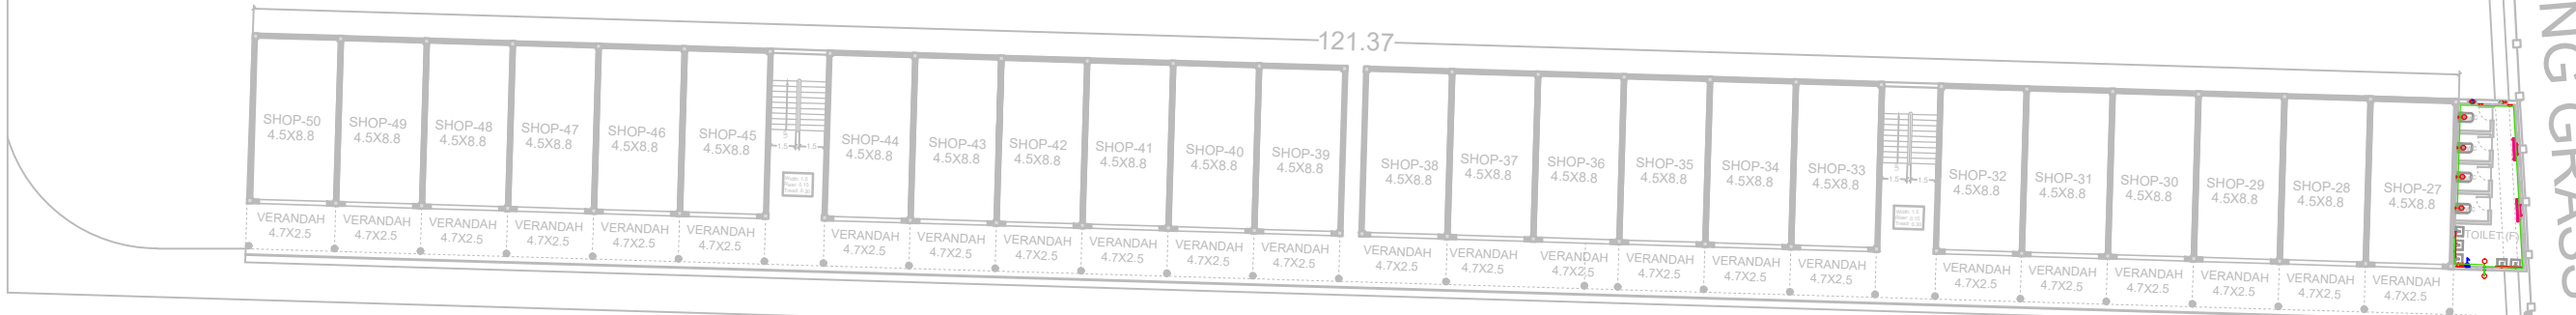

18M WIDE ROAD

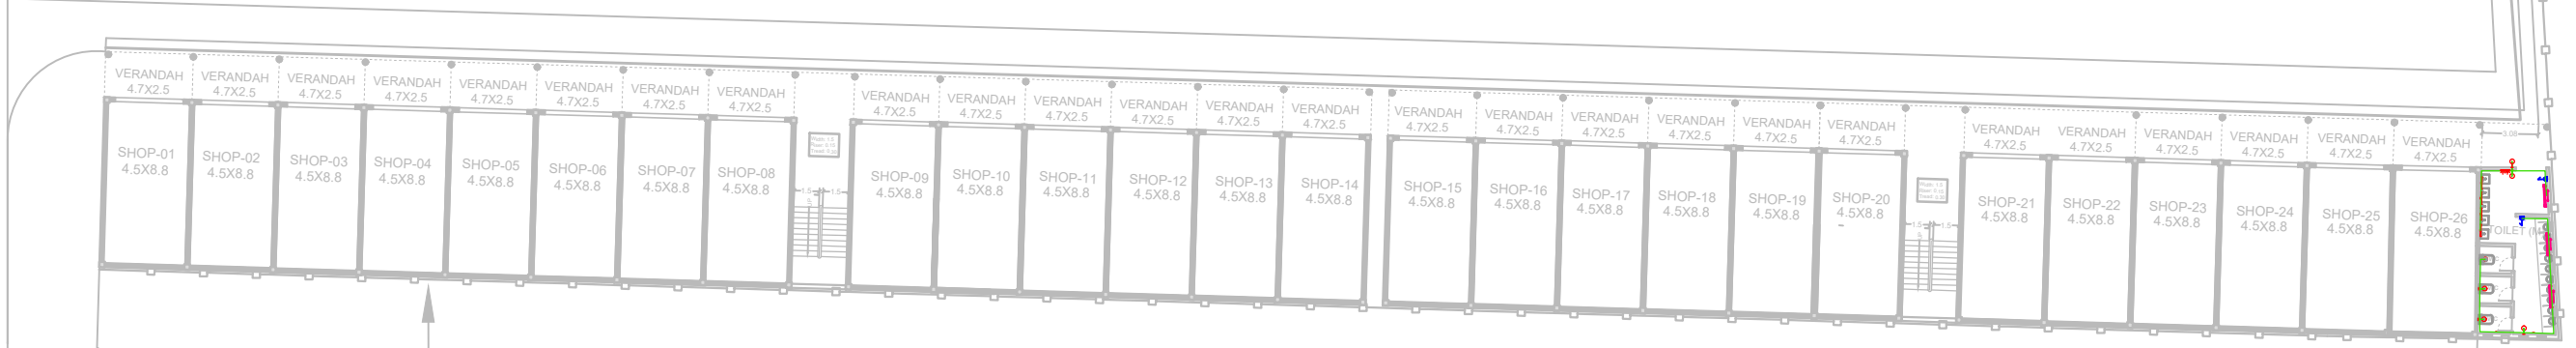

REMAINING PART OF GATA NO .519

EXISTING PRECAST BOUNDARY WALL

TOWARDS GWALIOR

NH-44

TOWARDS JHANSI

ROAD -60 METER WIDE

PROJECT NAME:
PROPOSED 50 SHOPS LAYOUT AT
TRANSPORT NAGAR PHASE-1, JHANSI



DRAWING TITLE:
LAYOUT PLAN

DATE: SCALE:
N.T.S.

ELECTRICAL LEGEND		
S.NO.	SYMBOL	DESCRIPTION
1.		1X22W WALL MOUNTED LED LIGHT FITTING (1200mm LENGTH)
2.		10W WALL MOUNTED LED BATTEN HOLDER
3.		10 W LED TUBE LIGHT FITTING (600mm)
4.		EXHAUST FAN 230 MM EXHAUST FAN 300 MM
5.		CEILING ROSE
6.		MODULAR TYPE 6 AMP. SOCKET
7.		MODULAR TYPE 16 AMP. SOCKET
8.		MODULAR TYPE FLUSH MOUNTED SWITCH BOARD
9.		LIGHT POWER DISTRIBUTION BOARD
10.		CONDUITS (25MM/32MM DIA)

PROJECT MANAGEMENT UNIT:
JHANSI DEVELOPMENT AUTHORITY,
JHANSI