

**NOTES:**

**ELECTRICAL LEGEND :-**

S.NO.	SYMBOL	DESCRIPTION
1		FEEDER PILLAR
2		SINGLE ARM POLE
3		BOLLARD LIGHT
4		4CX6SQ.MM AL AR XLPE CABLE

**NOTES:**

**PLUMBING LEGEND :-**

S.NO.	SYMBOL	DESCRIPTION
1		MANHOLE
2		MANHOLE
3		RAIN WATER SUPPLY
4		DRAINAGE

PROJECT TITLE:	<b>DPS GROUP HOUSING</b>	
DRAWING SCALE:	AS SHOWN	DATE: 13 JUNE 2025
ARCHITECT	AR. TRIPTIE AWASTHI	










DWG. TITLE :- **SITE PLAN**  
**WATER SUPPLY, SEWERAGE, STREET LIGHT**  
**PUMP ROOM, DG, CSS & STP LOCATION**

DWG. No. :-  
**DP/VIZ/EXT/PL/0**

DRN BY:  
 JITENDRA CHAUDHARY

CHKD BY:  
 DEVENDRA DWIVEDI

Services Consultants :-  
**VIZICON**  
**BUILDING MEP CONSULTANT**  
 A-100, Sector- C, Indiranagar, near  
 Bhootnath Metro Station, LUCKNOW  
 EMAIL: Vizicon.lko@gmail.com

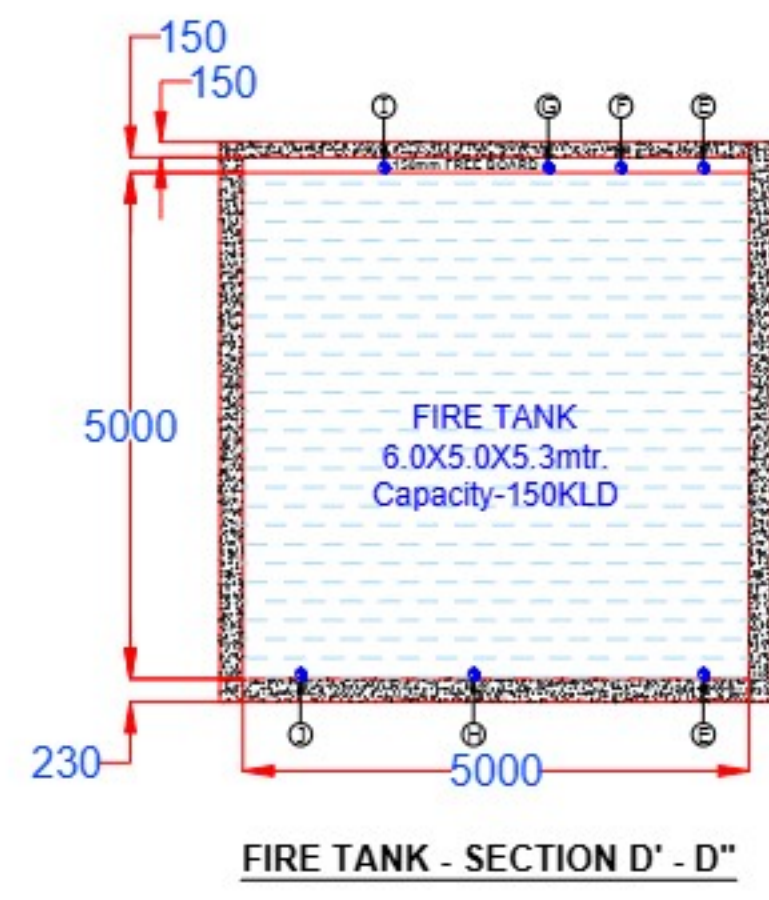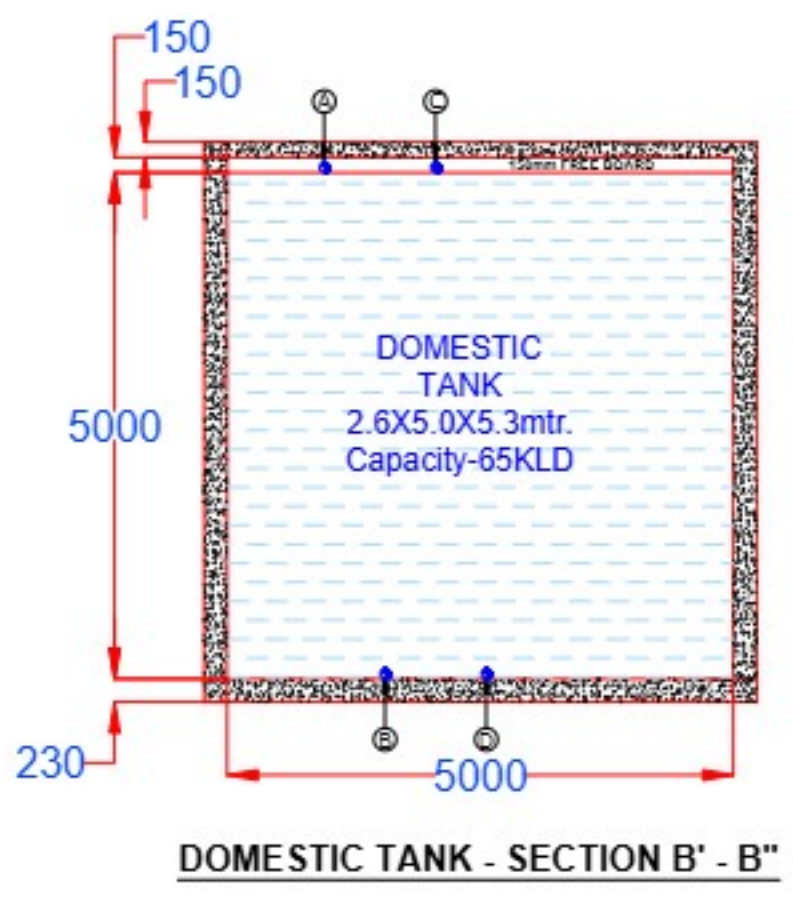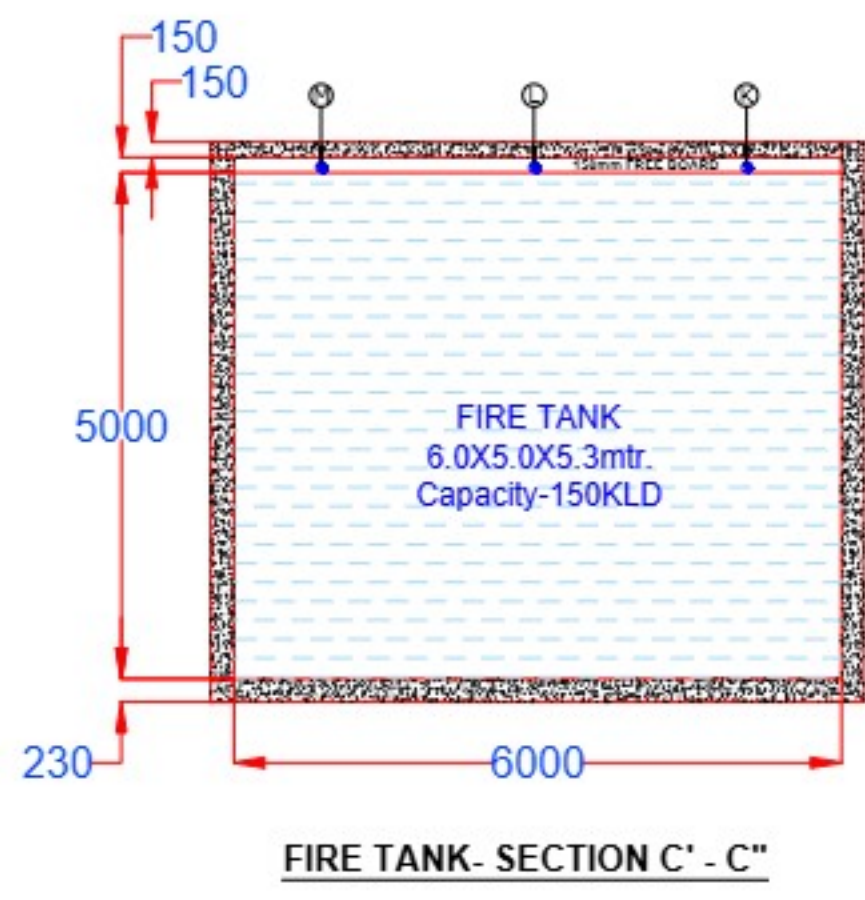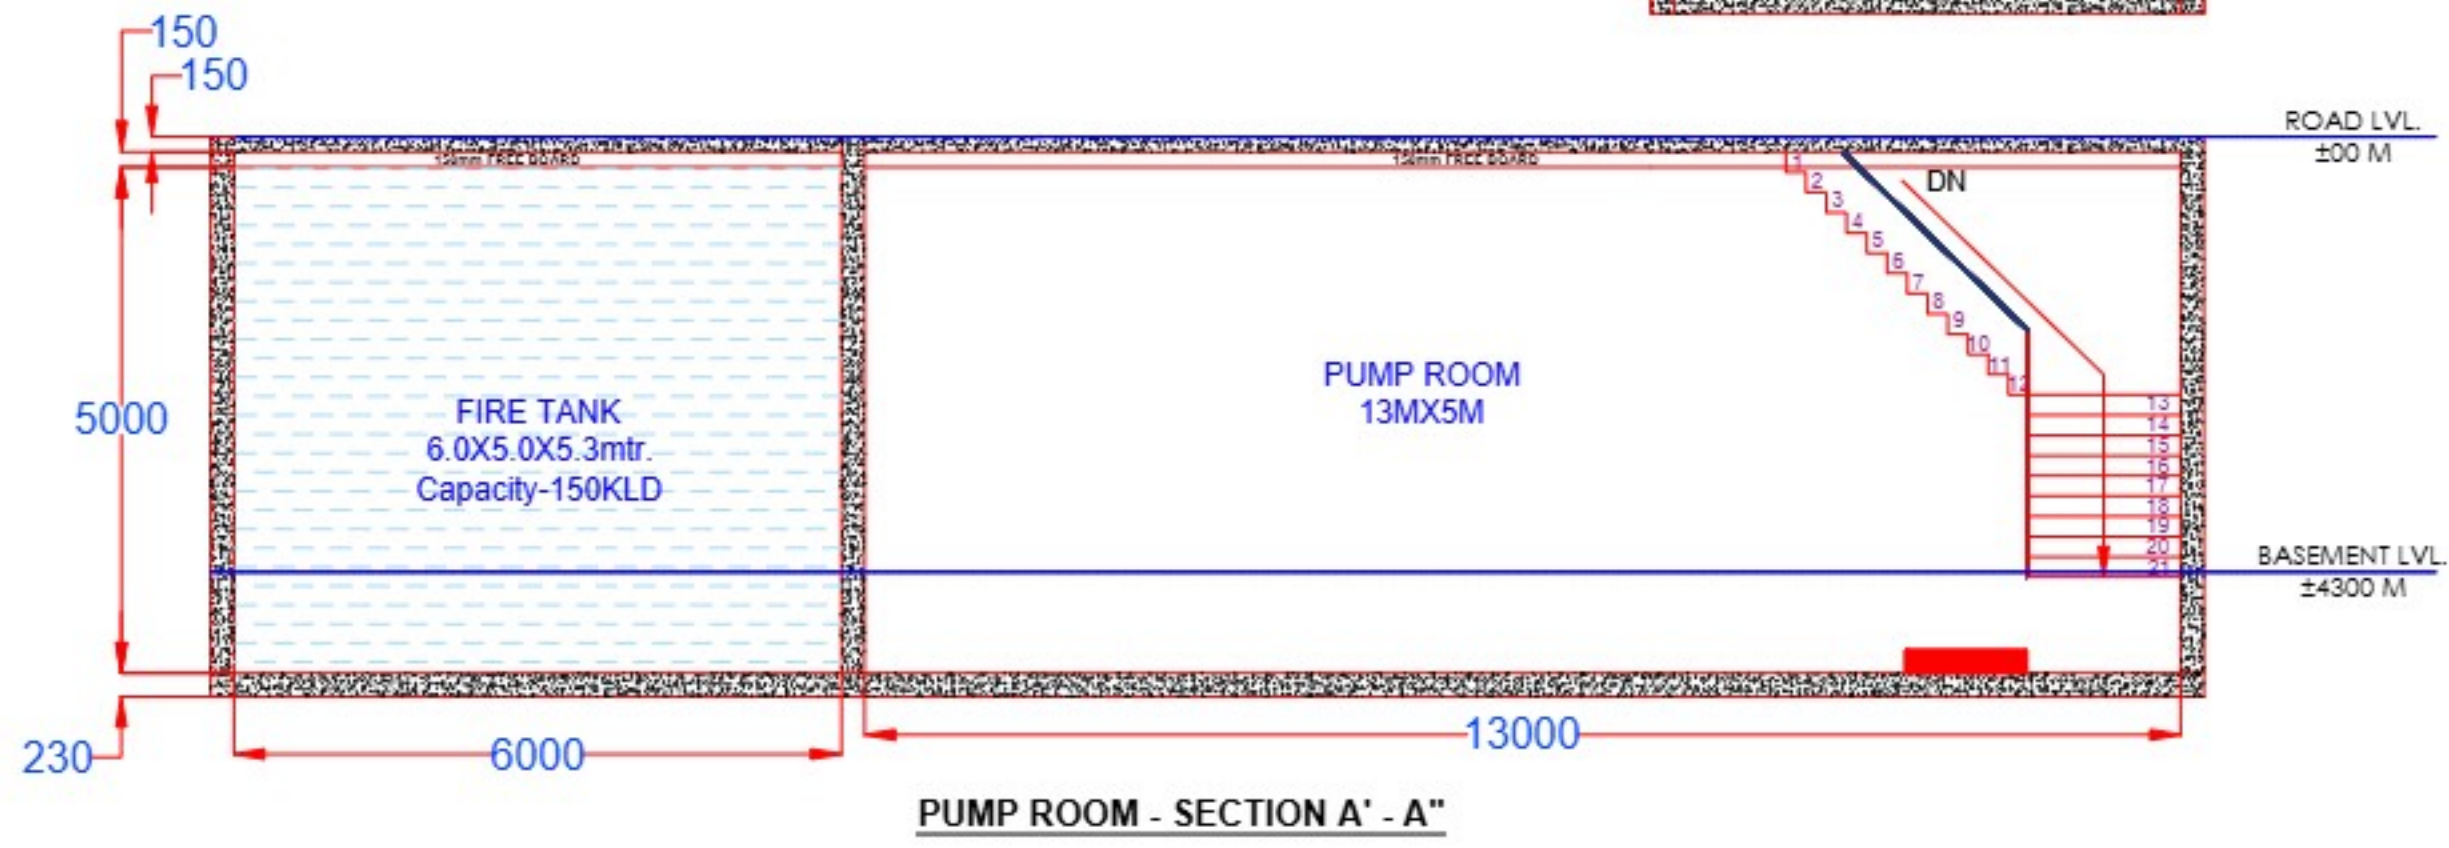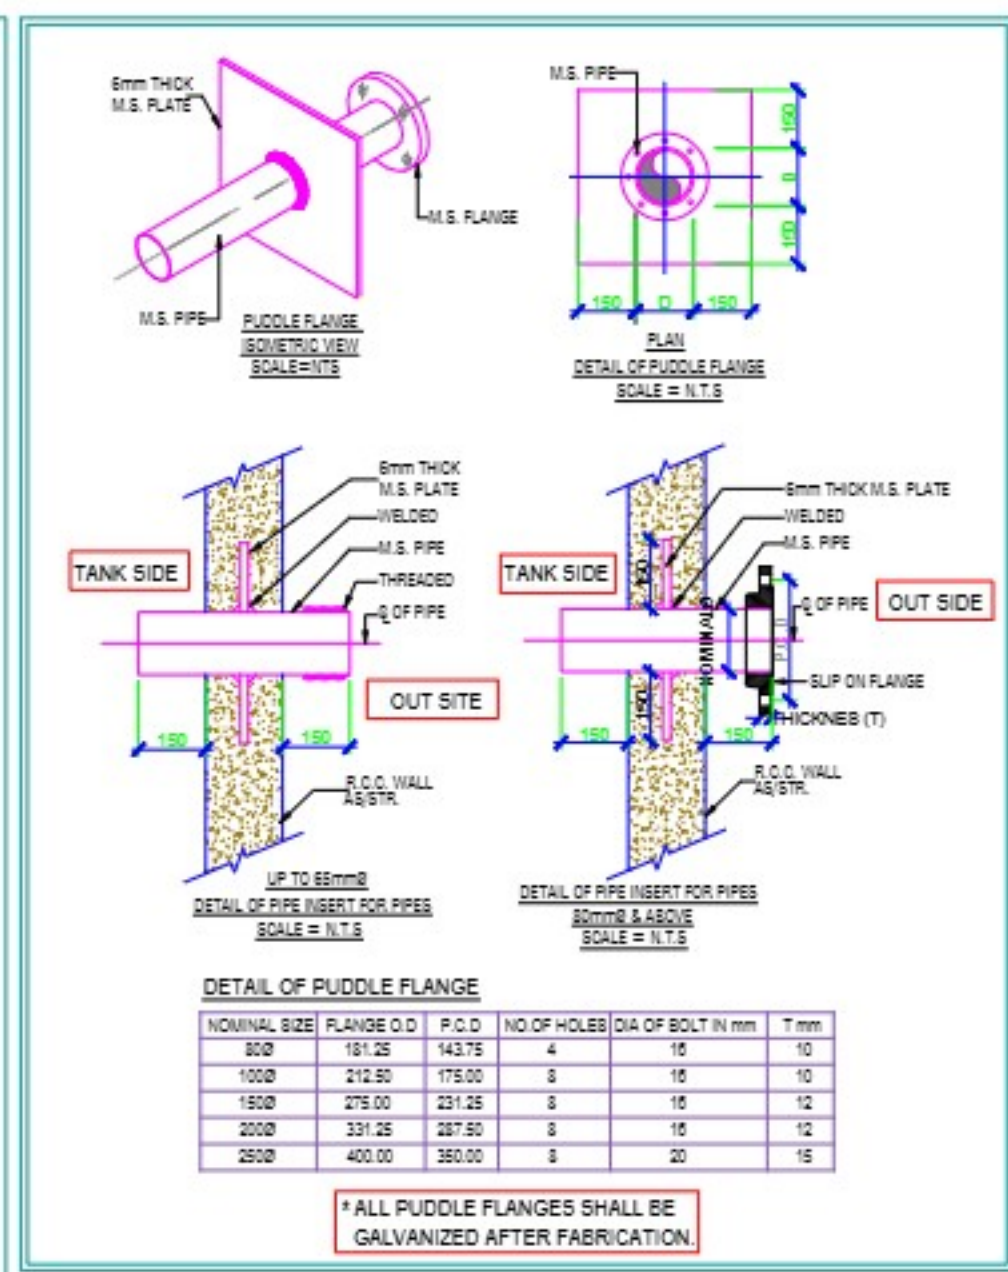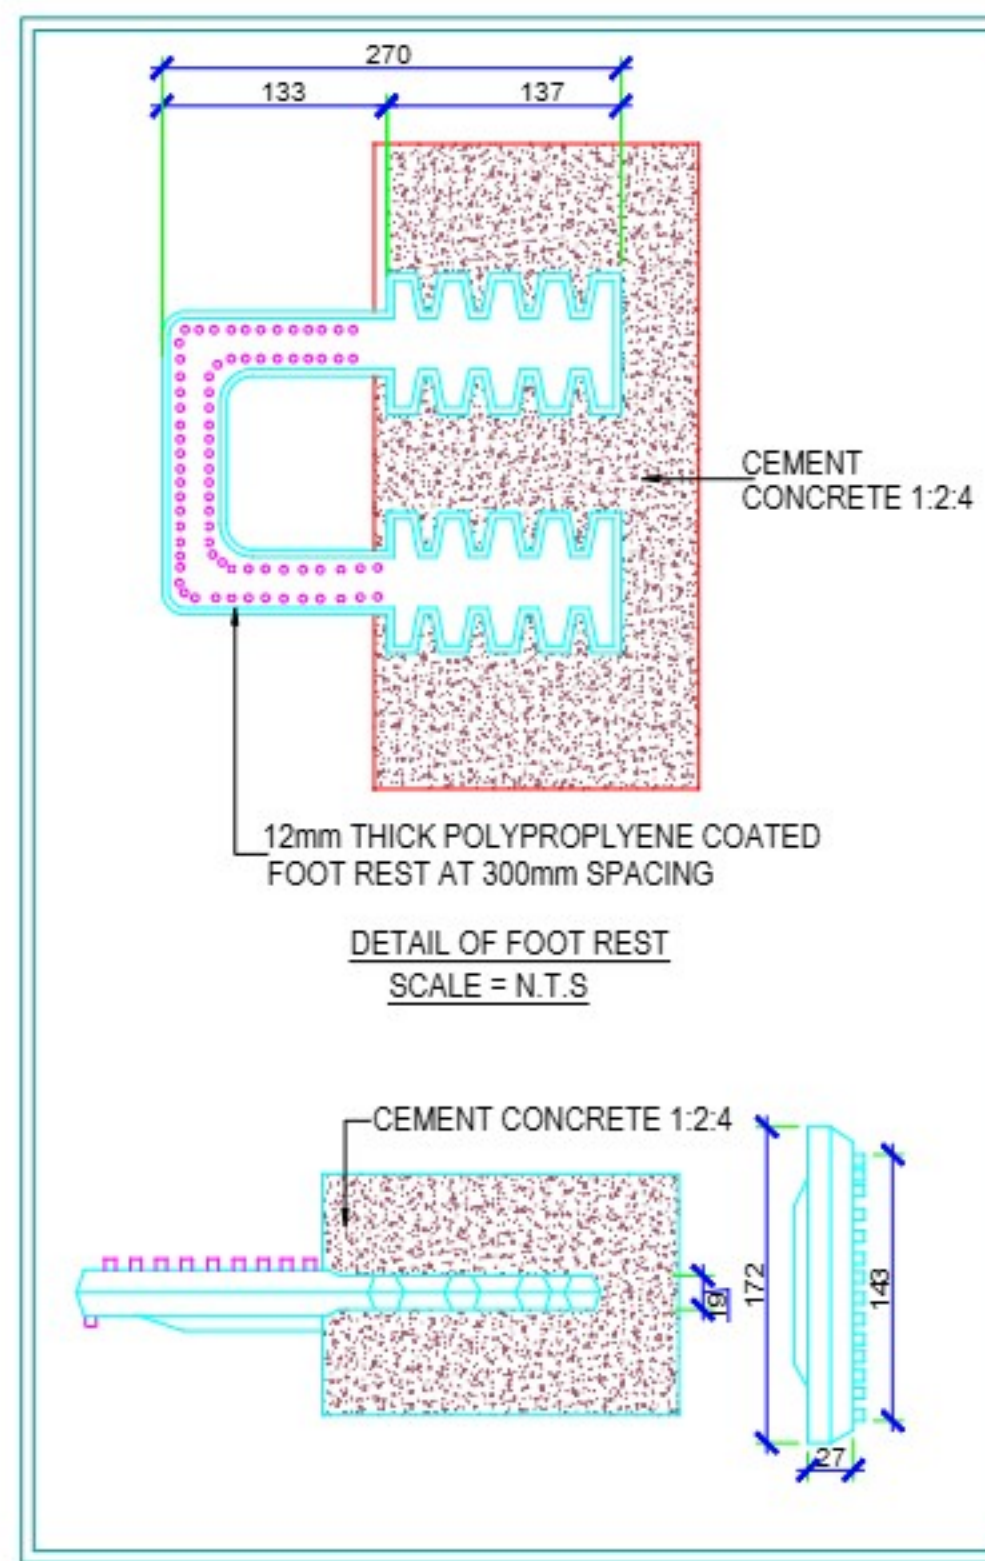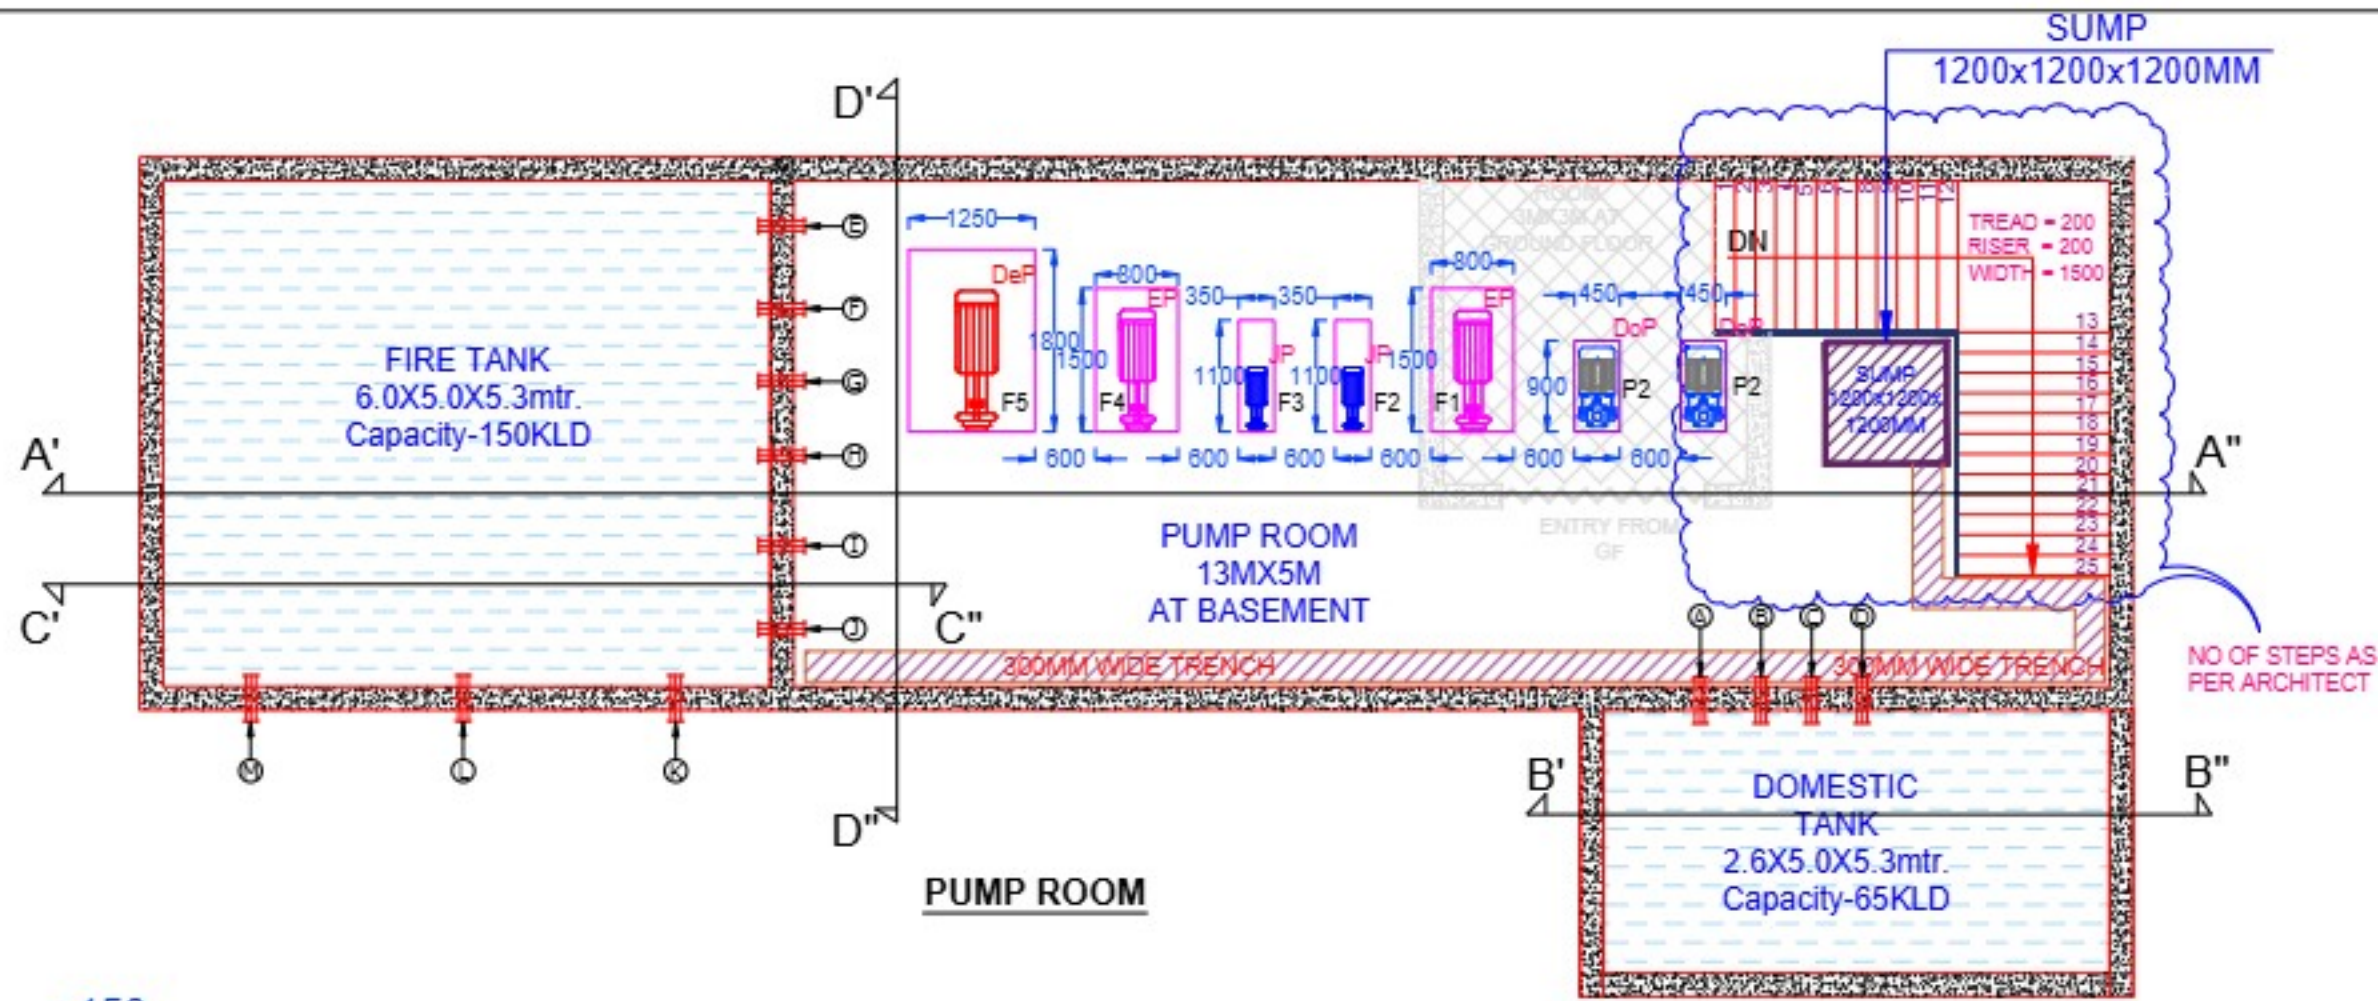

SNO.	PUMPS	SYMBOL	HEAD	CAPACITY
01.	HYDRANT PUMP	HP	-	-
02.	JOCKEY PUMP	JP	-	-
03.	SPRINKLER PUMP	SP	-	-
04.	JOCKEY PUMP	JP	-	-
05.	DIESEL PUMP	DP	-	-

SCHEDULE OF SLEEVES				
SYMBOL	DISCRIPTION	DIAMETER OF PIPE	LVL. (MM) Bottom of Pipe	NO. OF PIPE
(A)	OVER FLOW	100Ø	-300mm	1
(B)	WASHOUT	80Ø	-5000mm	1
(C)	INLET FROM FIRE (I)	100Ø	-300mm	1
(D)	DOMESTIC PUMP SUCTION	100Ø	-5000mm	1
(E)	EXTRA SLEEVES	100Ø	-300mm/-5000 (2Nos.)	2
(F)	TEST LINE	100Ø	-300mm	1
(G)	SENSOR	40Ø	-300mm	1
(H)	WASH OUT	80Ø	-5000mm	1
(I)	OVER FLOW	100Ø	-300mm	1
(J)	FIRE SUCTION	200Ø	-5000mm	1
(K)	TUBE WELL	100Ø	-300mm	1
(L)	MUNICIPAL	100Ø	-300mm	1
(M)	FIRE BRIGADE	100Ø	-300mm	1

PROJECT TITLE: **DPS GROUP HOUSING**

DRAWING SCALE: AS SHOWN

ARCHITECT: AR. TRIPTIE AWASTHI

DATE: 13 JUNE 2025



DWG. TITLE :- **PUMP ROOM DOMESTIC TANK & FIRE TANK SECTION**

DWG. No. :- **DP/VIZ/EXT/PL/0**

DRN BY: **JITENDRA CHAUDHARY**

CHKD BY: **DEVENDRA DWIVEDI**

Services Consultants :- **VIZICON BUILDING MEP CONSULTANT**  
 A-100, Sector- C, Indiranagar, near Bhootnath Metro Station, LUCKNOW  
 EMAIL: Vizicon.iko@gmail.com

CONSULTANT: **D-310 1st Floor Green Tower Vibhuti Khand, Gomti Nagar LUCKNOW**