


# WASTE DISPOSAL PLAN

SHEET -S-04


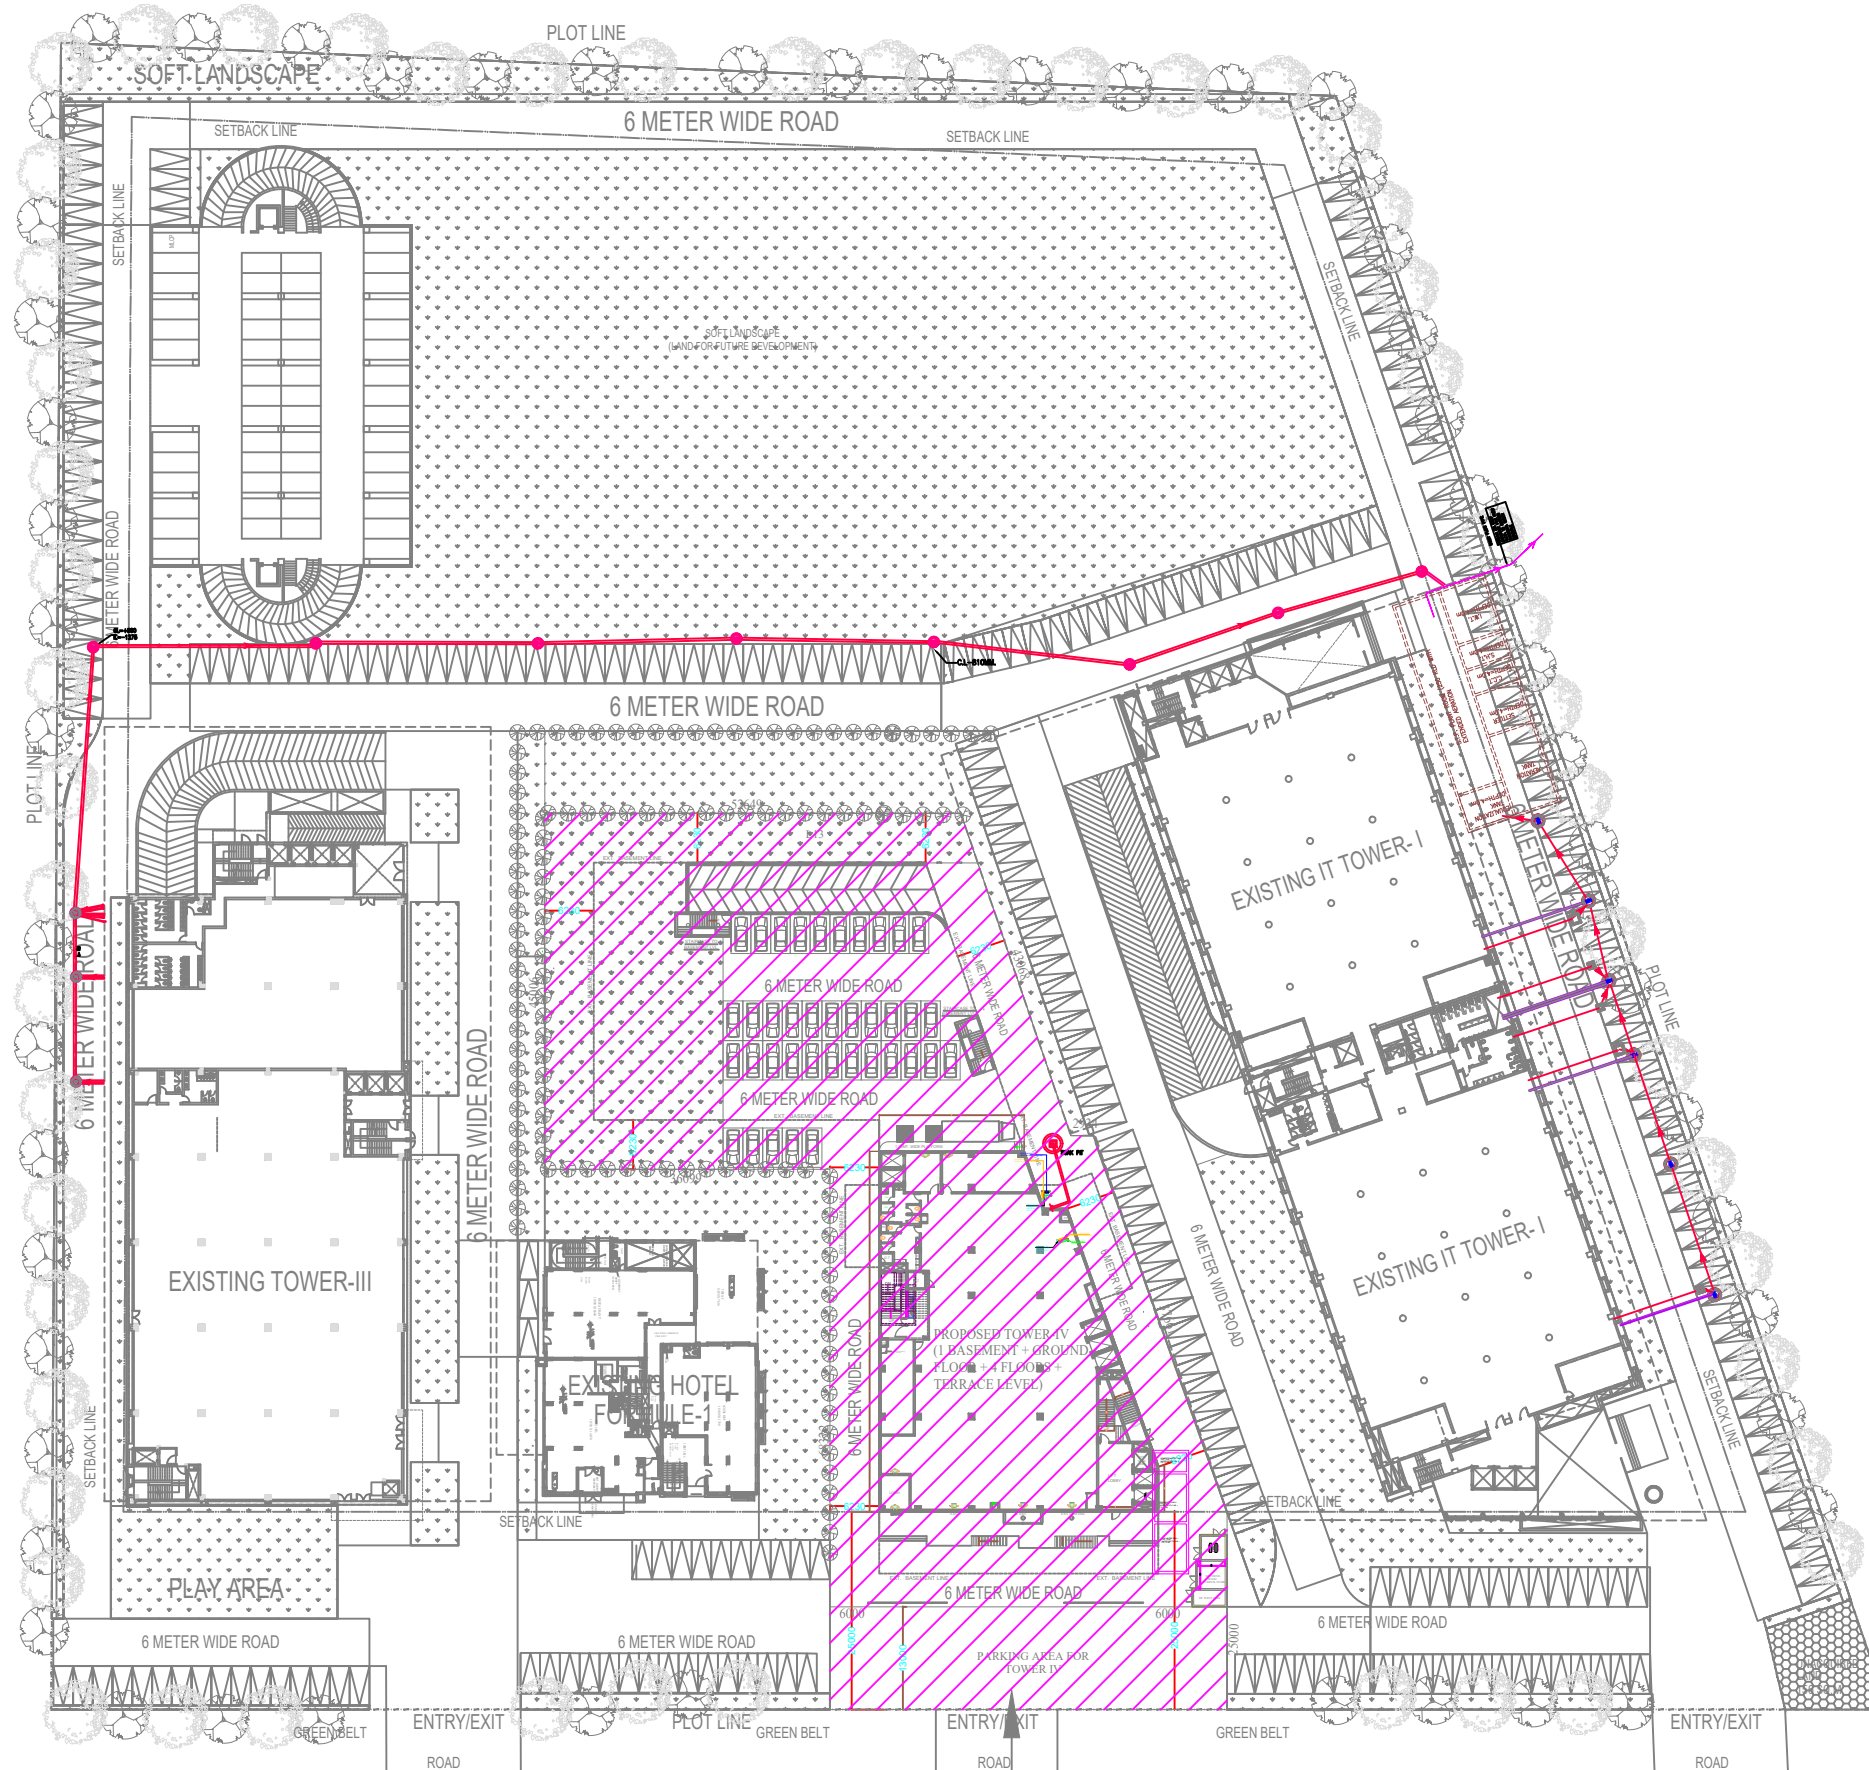


LEGEND OF PLUMBING/SANITARY:		
S.NO.	SYMBOL	DESCRIPTION
01.		SEWER LINE
02.		STORM WATER LINE
03.		CATCH BASIN / MANHOLE
04.		STORM MANHOLE
05.		SEWERAGE MANHOLE
06.		GARDEN HYDRANT

**TOWER-4, 5826 SQ.MET LAND  
APPLIED FOR RERA REGISTRATION**

OWNER'S SIGN:	ARCHITECT'S SIGN:
PROPOSED BUILDING PLAN, AT WEGMANS INDUSTRIES PVT. LTD., ON PLOT NO.-03, SECTOR K.P.-III, GREATER NOIDA, U.P.	
OWNER: WEGMANS INDUSTRIES PVT.Ltd.	
SHEET TITLE: WASTE DISPOSAL PLAN	
DRAWING NO:	
<b>S-04</b>	
SCALE:	DATE:
NTS	
ARCHITECTS: <b>DEVESH VERMA</b> ARCHITECTS & INTERIOR DESIGNERS TEL:999279559 E-MAIL:DEVESH7CHD@GMAIL.COM	
<small>© &amp; ® THIS DRAWING IS THE PROPERTY OF THE ARCHITECTS AND IS NOT TO BE COPIED OR REPRODUCED WITHOUT PERMISSION</small>	

# DRAINAGE PLAN

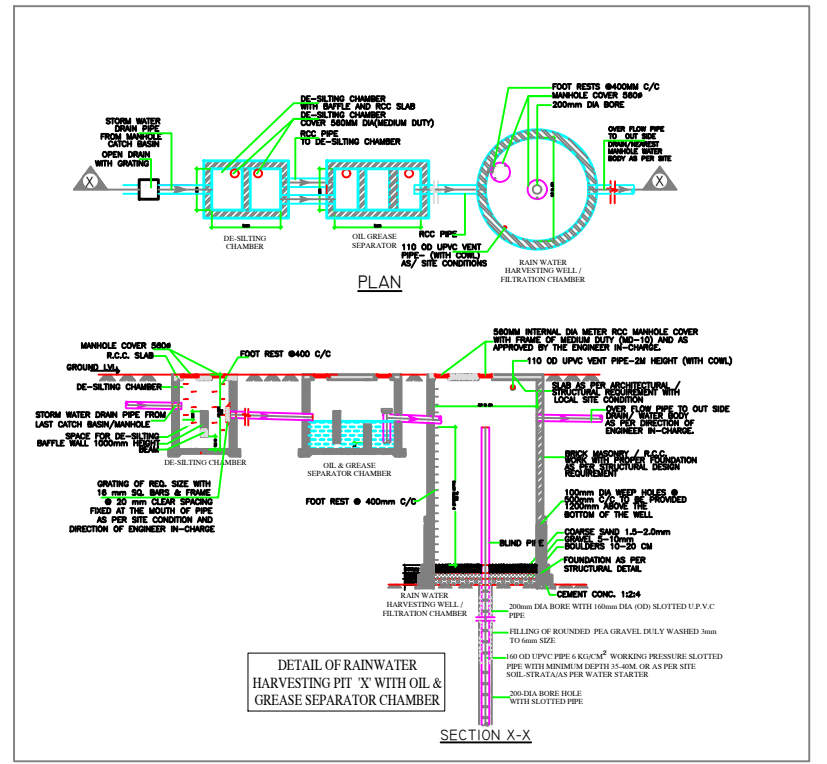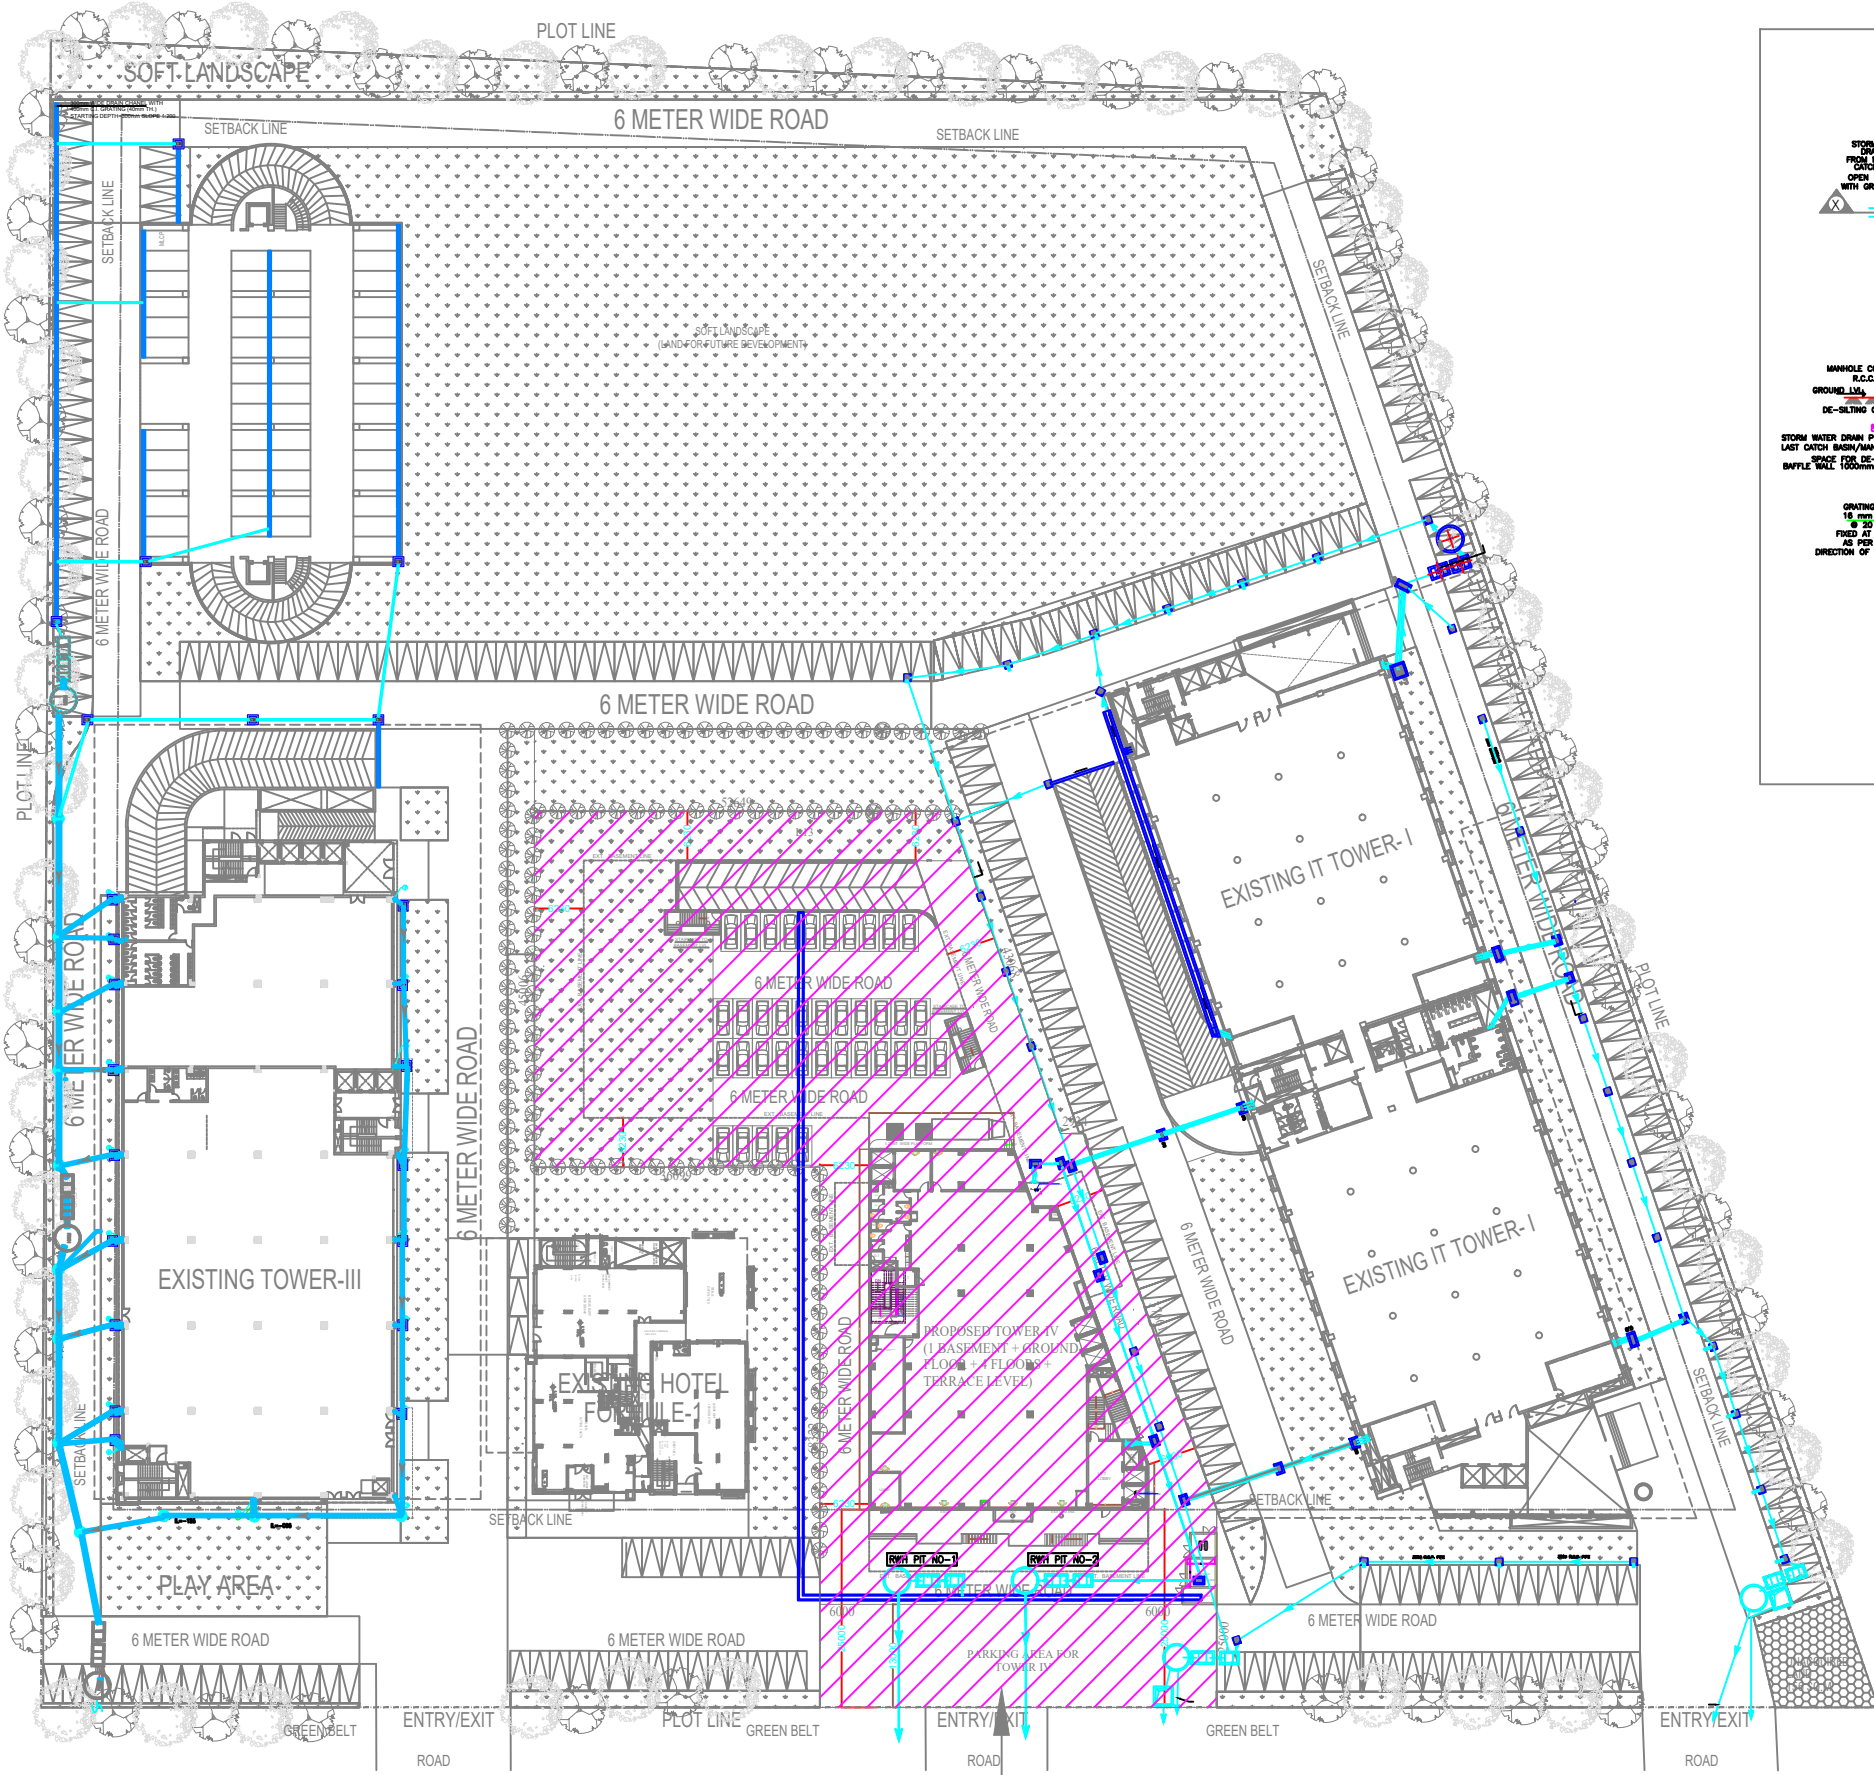

**LEGEND OF PLUMBING/SANITARY:**

S.NO.	SYMBOL	DESCRIPTION
01.		SEWER LINE
02.		STORM WATER LINE
03.		CATCH BASIN / MANHOLE
04.		STORM MANHOLE
05.		SEWERAGE MANHOLE
06.		GARDEN HYDRANT

**TOWER-4, 5826 SQ.MET LAND  
APPLIED FOR RERA REGISTRATION**

OWNERS' SIGN: \_\_\_\_\_ ARCHITECT'S SIGN: \_\_\_\_\_

PROPOSED BUILDING PLAN,  
AT WEGMANS INDUSTRIES PVT. LTD.,  
ON PLOT NO.-03, SECTOR K.P.-III,  
GREATER NOIDA, U.P.

OWNER:  
WEGMANS INDUSTRIES PVT.Ltd.

SHEET TITLE:  
DRAINAGE PLAN

DRAWING NO:  
**S-03**

SCALE:  
NTS

DATE: \_\_\_\_\_

ARCHITECTS:  
**DEVESH VERMA**  
ARCHITECTS & INTERIOR DESIGNERS  
Tel: 999279559  
E-mail: DEVESH7CHD@GMAIL.COM

© & ® THIS DRAWING IS THE PROPERTY OF THE ARCHITECTS AND IS NOT TO BE COPIED OR REPRODUCED WITHOUT PERMISSION