
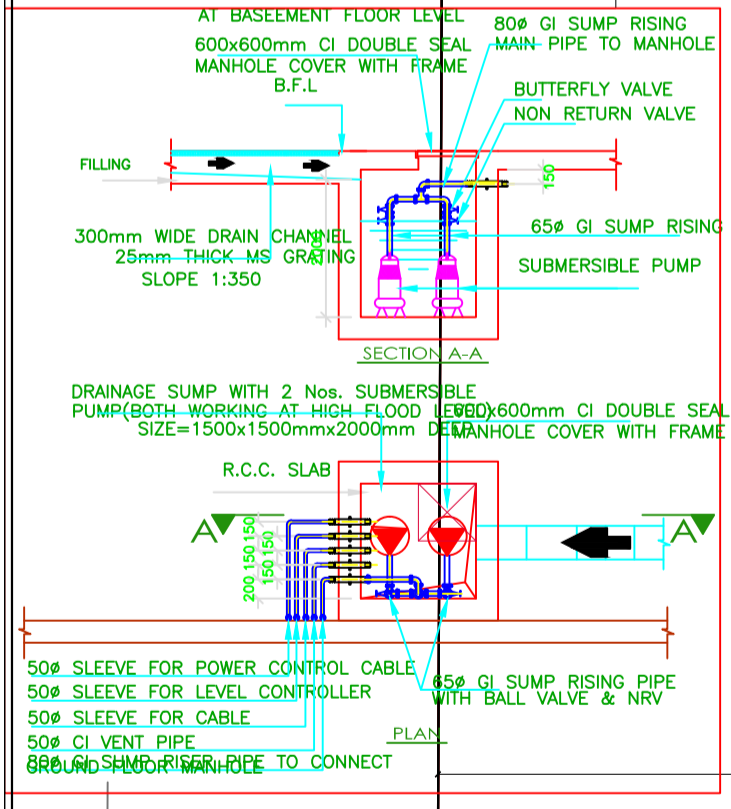


	300mm WIDE DRAIN CHANNEL
	FLOOR FINISH LEVEL
	INVERT LEVEL
	CONNECTION LEVEL

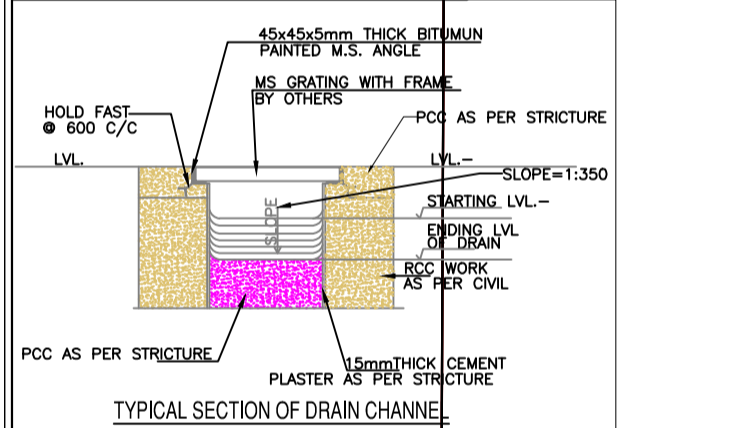

GENERAL NOTES :-
 1. All dimensions are in feet and inches.
 2. Do not scale this drawing follow written dimensions only.
 3. This drawing shall be read in conjunction with other architectural, structural and services drawings.
 4. Any discrepancy in the drawing should be immediately brought to the notice of architect, prior to construction.

5. Architectural Drawings should be followed for the Location of structural and masonry members however size & reinforcement shall be followed as structural or other relevant drawings.
 6. Coordination with other services drawings such as electrical, hvac, plumbing etc. is the sole responsibility of the contractor.
 7. For details follow large scale detailed drawings.
 8. All drawings/measurements must be checked & verified by the contractor at site.

9. Architect's responsibility is limited to the soundness of its design only.
 10. Bad workmanship will be sole responsibility of client & contractor.
WARNING :-
 1. This drawing is the sole copyright of Architects Mishra Garg & Associates and should be used for the purpose expressly issued.

DRAWING TITLE
BASEMENT FLOOR DRAINAGE LAYOUT PLAN

PROJECT TITLE
DREAM TOWN

ARCHITECTS :
HABITAT INDIA
 ARCHITECTS, ENGINEERS & INTERIOR DESIGNER
 17/430, ARYA NAGAR, FIROZABAD
 MOB. : 98370-26046
 Email-id : habitat_firozabad@hotmail.com

MEP CONSULTANTS : SRAJAN ASSOCIATES C-SCHEME, JAIPUR Email-id - snajipur@hotmail.com			
MISHRA GARG & ASSOCIATES ARCHITECTS, PLANNERS & INTERIOR DESIGNER C-35, LAPAT MARG, C-SCHEME, JAIPUR. TEL. : (0141) 2373274 Email-id : mishra.garg@gmail.com			
DESIGN BY S.BHEERA	PROJECT ARCHITECT KALASH	DATE 05.02.2024	NORTH
SCALE N.T.S	DEALT BY S.SINGH	DRG. NO. PL-01	