


WORKING DRAWING

NORTH SHEET NO.

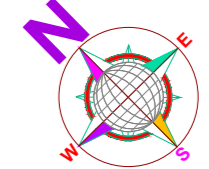

LEGEND:-

SL.	SYMBOL	DESCRIPTION
1.	G.L.	GROUND LEVEL
2.	I.L.	INVERT LEVEL
3.	C.L.	CONNECTION LEVEL
4.	300Ø	INTERNAL DIAMETER OF PIPE (IN mm.)
5.	GL=3000 IL=-450	GROUND LEVEL INVERT LEVEL
6.	L=8.0	LENGTH OF PIPE
7.	(600X600)	RAIN WATER LINE MAN HOLE 600X600
	(900X800)	RAIN WATER LINE MAN HOLE 900X800
8.	(900X800)	SEWER LINE MAN HOLE 900X800
9.	(1200X900)	SEWER LINE MAN HOLE 1200X800
	⊙	SEWER LINE MAN HOLE 1200 DIA
	⊙	SEWER LINE MAN HOLE 1500 DIA
10.	→	DRAIN LINE
11.	⊙	RAIN WATER HARVESTING PIT
12.	→	WATER SUPPLY LINE
13.	→	SEWER LINE
14.	⊗	GATE VALVE

PROJECT TITLE:


THIS IS TO CERTIFY THAT THIS BUILDING IS PROPOSED AS PER THE RULES & REGULATIONS OF MAHAYOJANA 2021.

SIGN OF LAND LORD. SIGN OF ARCHITECT.

SCALE:- 1:200 DATE:- 01.11.2022
SHEET-A0



architectural consultant pvt. ltd.
architects, engineers, planner
landscape design, interior design, & valuer
Office :- IInd & IIInd floor laxmi vardan commercial complex at
patrakar puram crossing gominagar, lucknow.
Dial :- +91-522-2393123, 2394123, 4044123
Email id:- skyline@usahcc.com
ARCHITECTS :- SANJAY & VIJAY SINHA

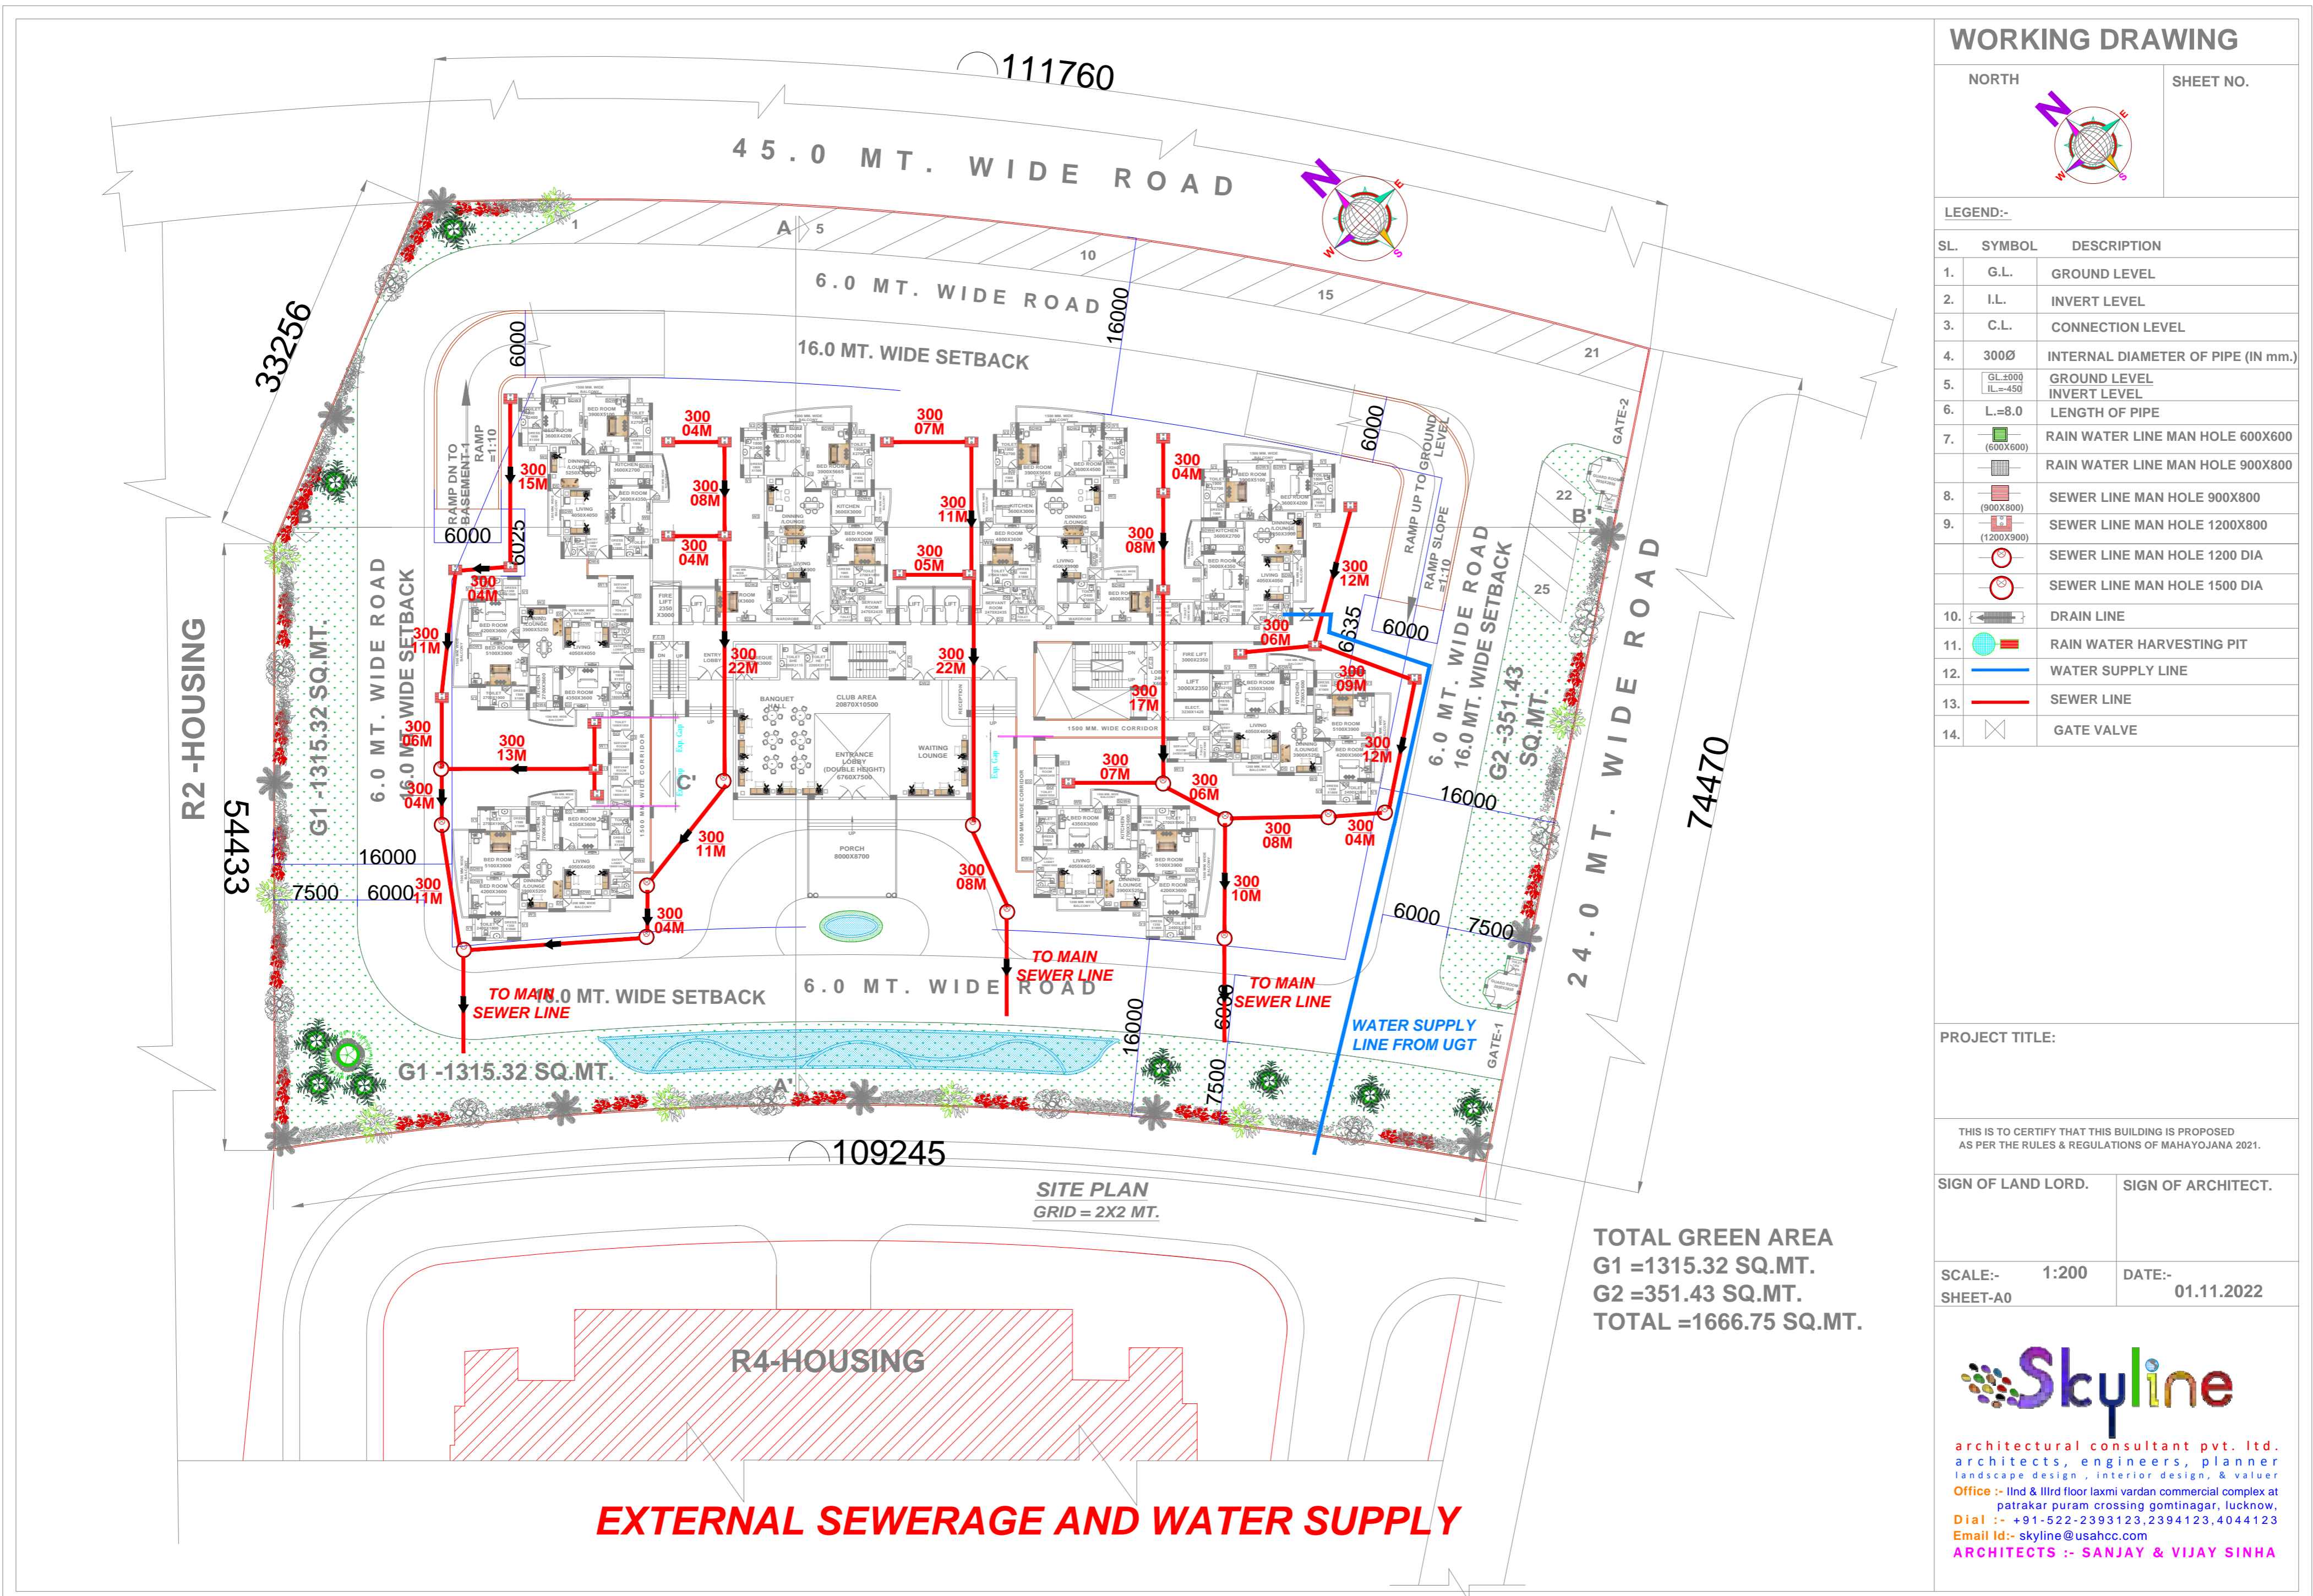

SITE PLAN
GRID = 2X2 MT.

TOTAL GREEN AREA
G1 =1315.32 SQ.MT.
G2 =351.43 SQ.MT.
TOTAL =1666.75 SQ.MT.

EXTERNAL SEWERAGE AND WATER SUPPLY

R4-HOUSING

R2-HOUSING