




LEGEND	
A	S1= CATCH BASIN 500X450X450mm DEEP UPTO 750
B	S2= CATCH BASIN 750X750X751mm DEEP UPTO 1000
C	S3 = C.B.900X900X1001mm DEEP DEEP UPTO 1500mm
D	DESILTING CHAMBER 2000X2000X 1500mm EFFECTIVE DEPTH
E	RAIN WATER HARVESTING 3000mm DIA & 3000mm EFFE. DEEP

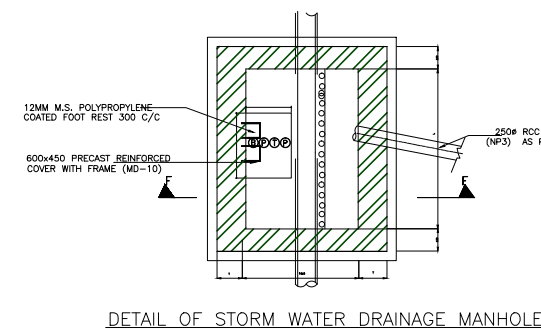


DETAIL OF STORM WATER DRAINAGE MANHOLE

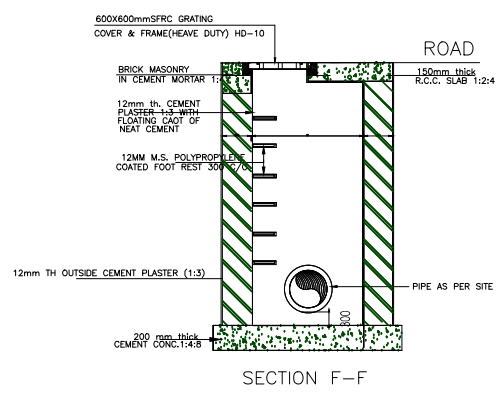


SECTION F-F

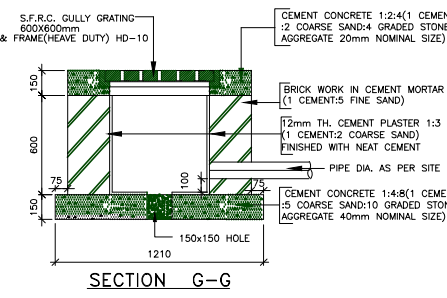


SECTION G-G

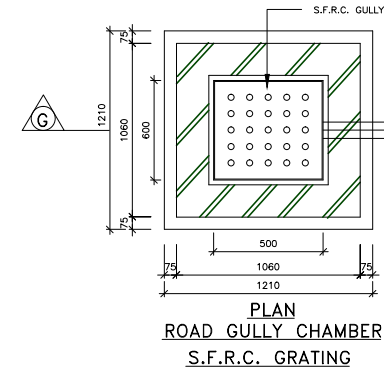


PLAN

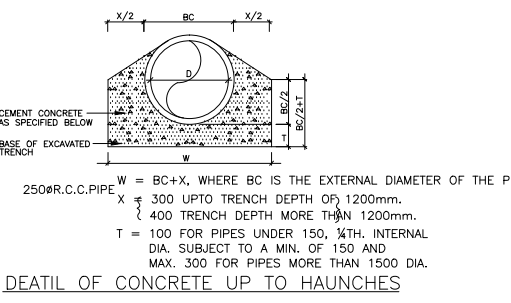


SECTION-AA

 


DETAIL OF DESILT CHAMBER

 

DETAIL OF CONCRETE UP TO HAUNCHES

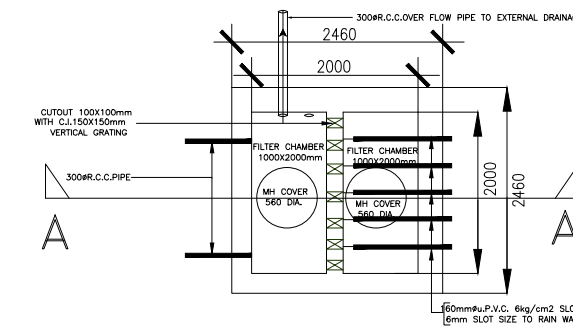


PLAN

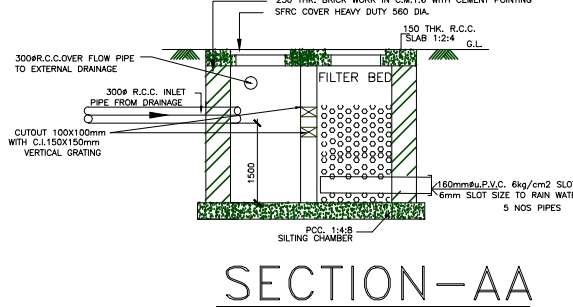


SECTION-AA


DESILT CHAMBER DETAILS

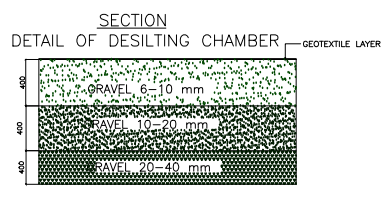



DETAILS OF FILTER BED

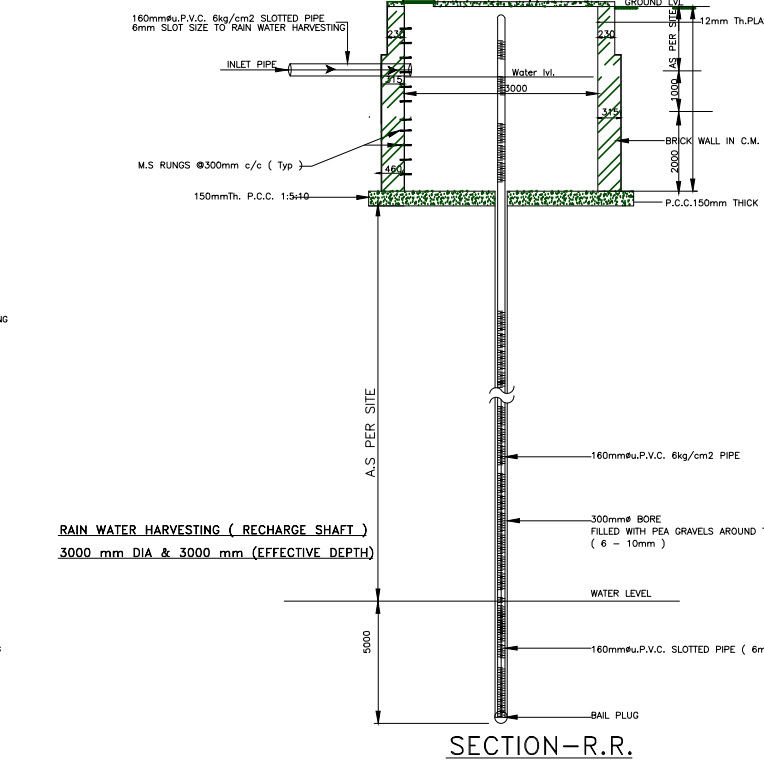

SECTION-R.R.

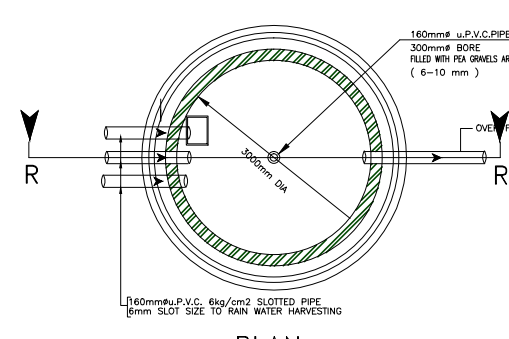

PLAN

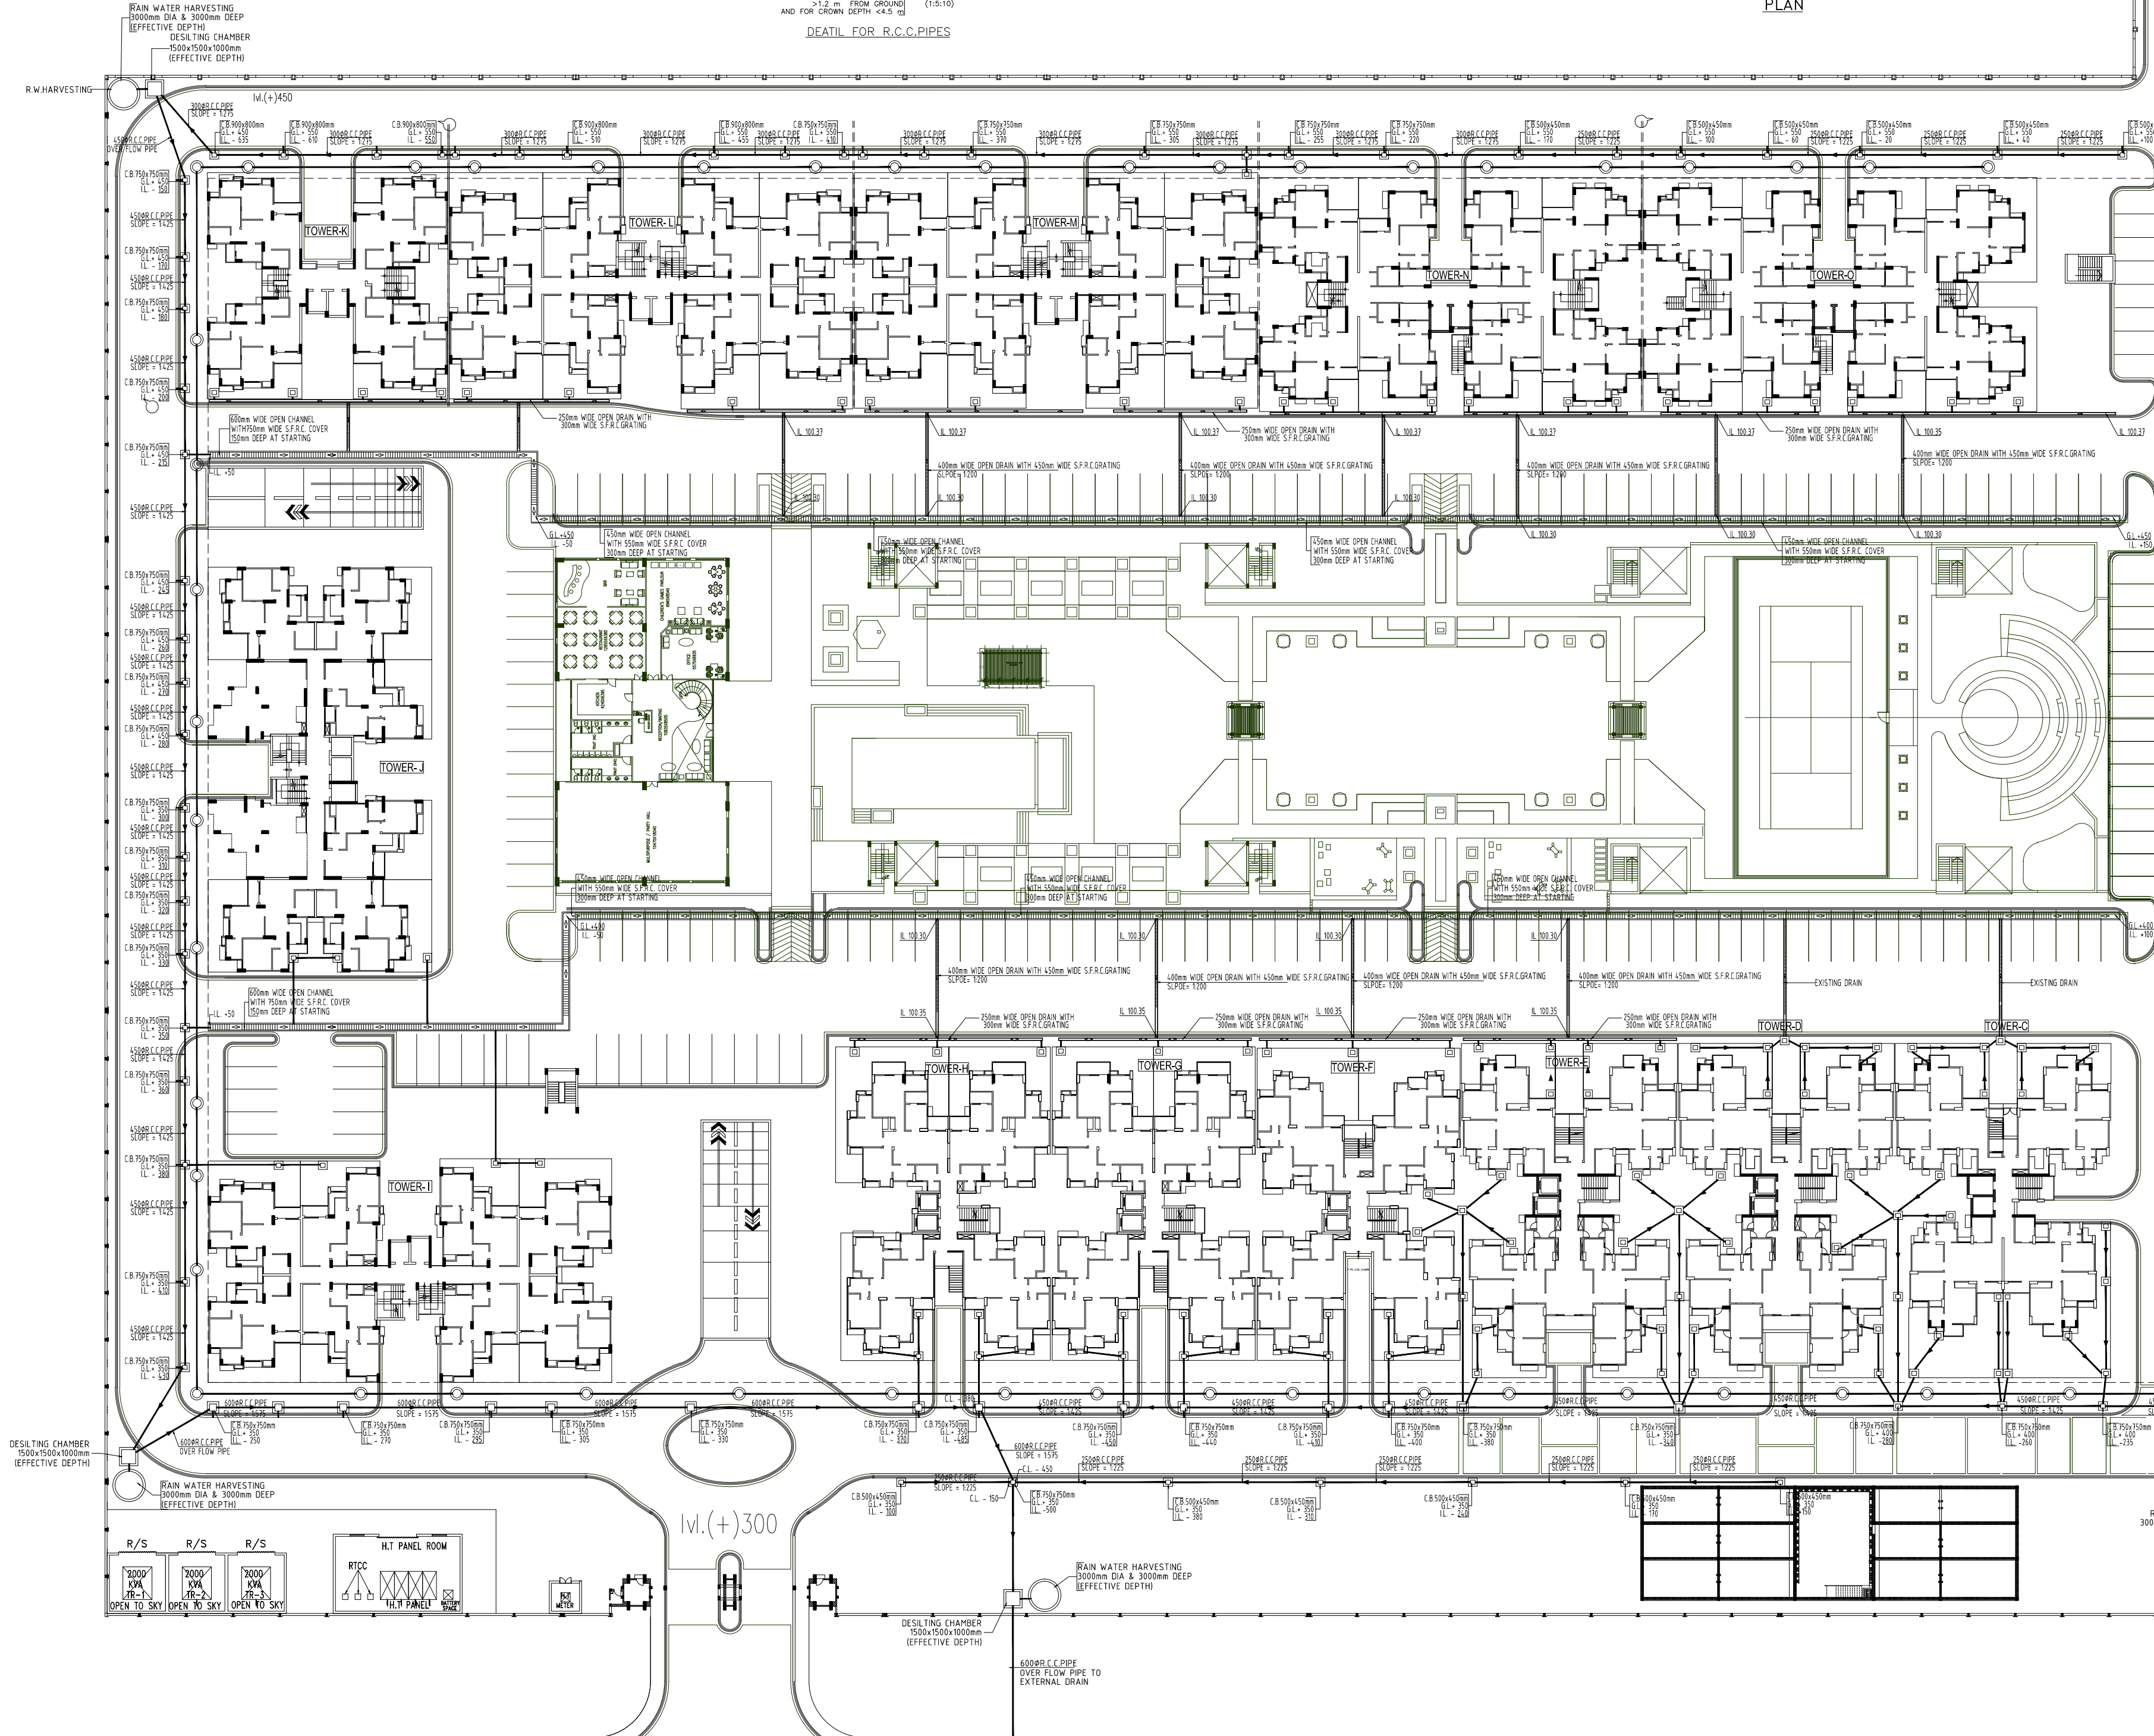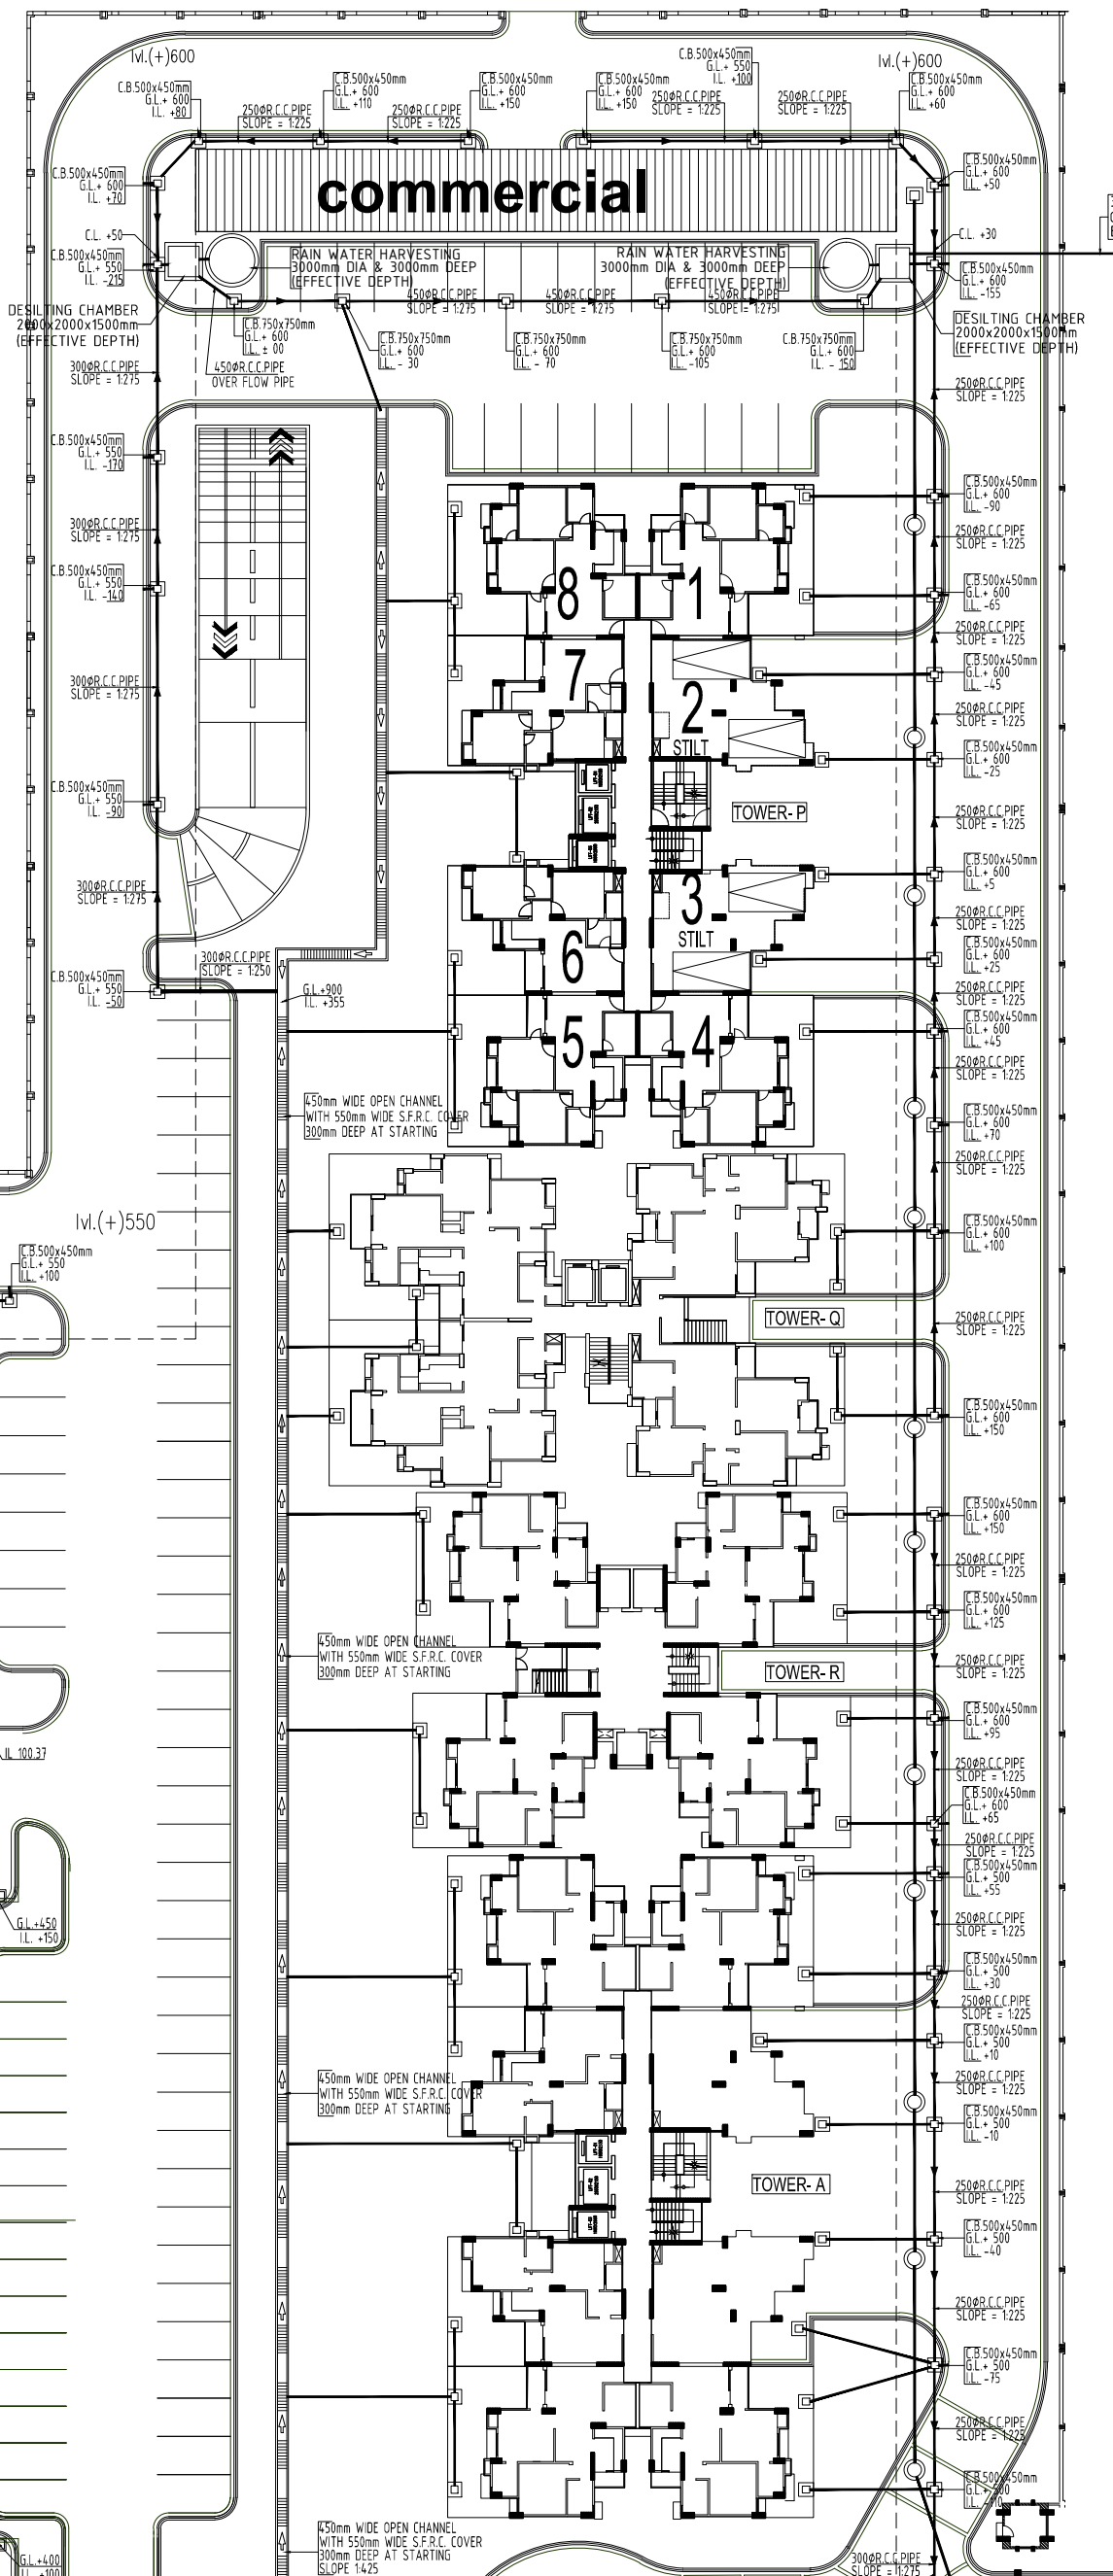

ARCHITECTS
SPACE COMBINE
ARCHITECTS, PLANNERS, ENGINEERS & PROJECT MANAGEMENT CONSULT.
A1/112, 2ND FLOOR,
SAFADARJUNG ENCLAVE, NEW DELHI-29.
PH-46150000.

SHEET TITLE :
**REVISED PLUMBING DRAWING
EXTERNAL DRAINAGE LAYOUT**

SCALE : 1 : 325
CHKD : - RAWAT
DRG. NO : -
DRN BY : - M.K.S.
PL-SP-D-01

OWNER :
**M/S TODAY HOMES NOIDA
PVT. LTD. (SPC)**

