


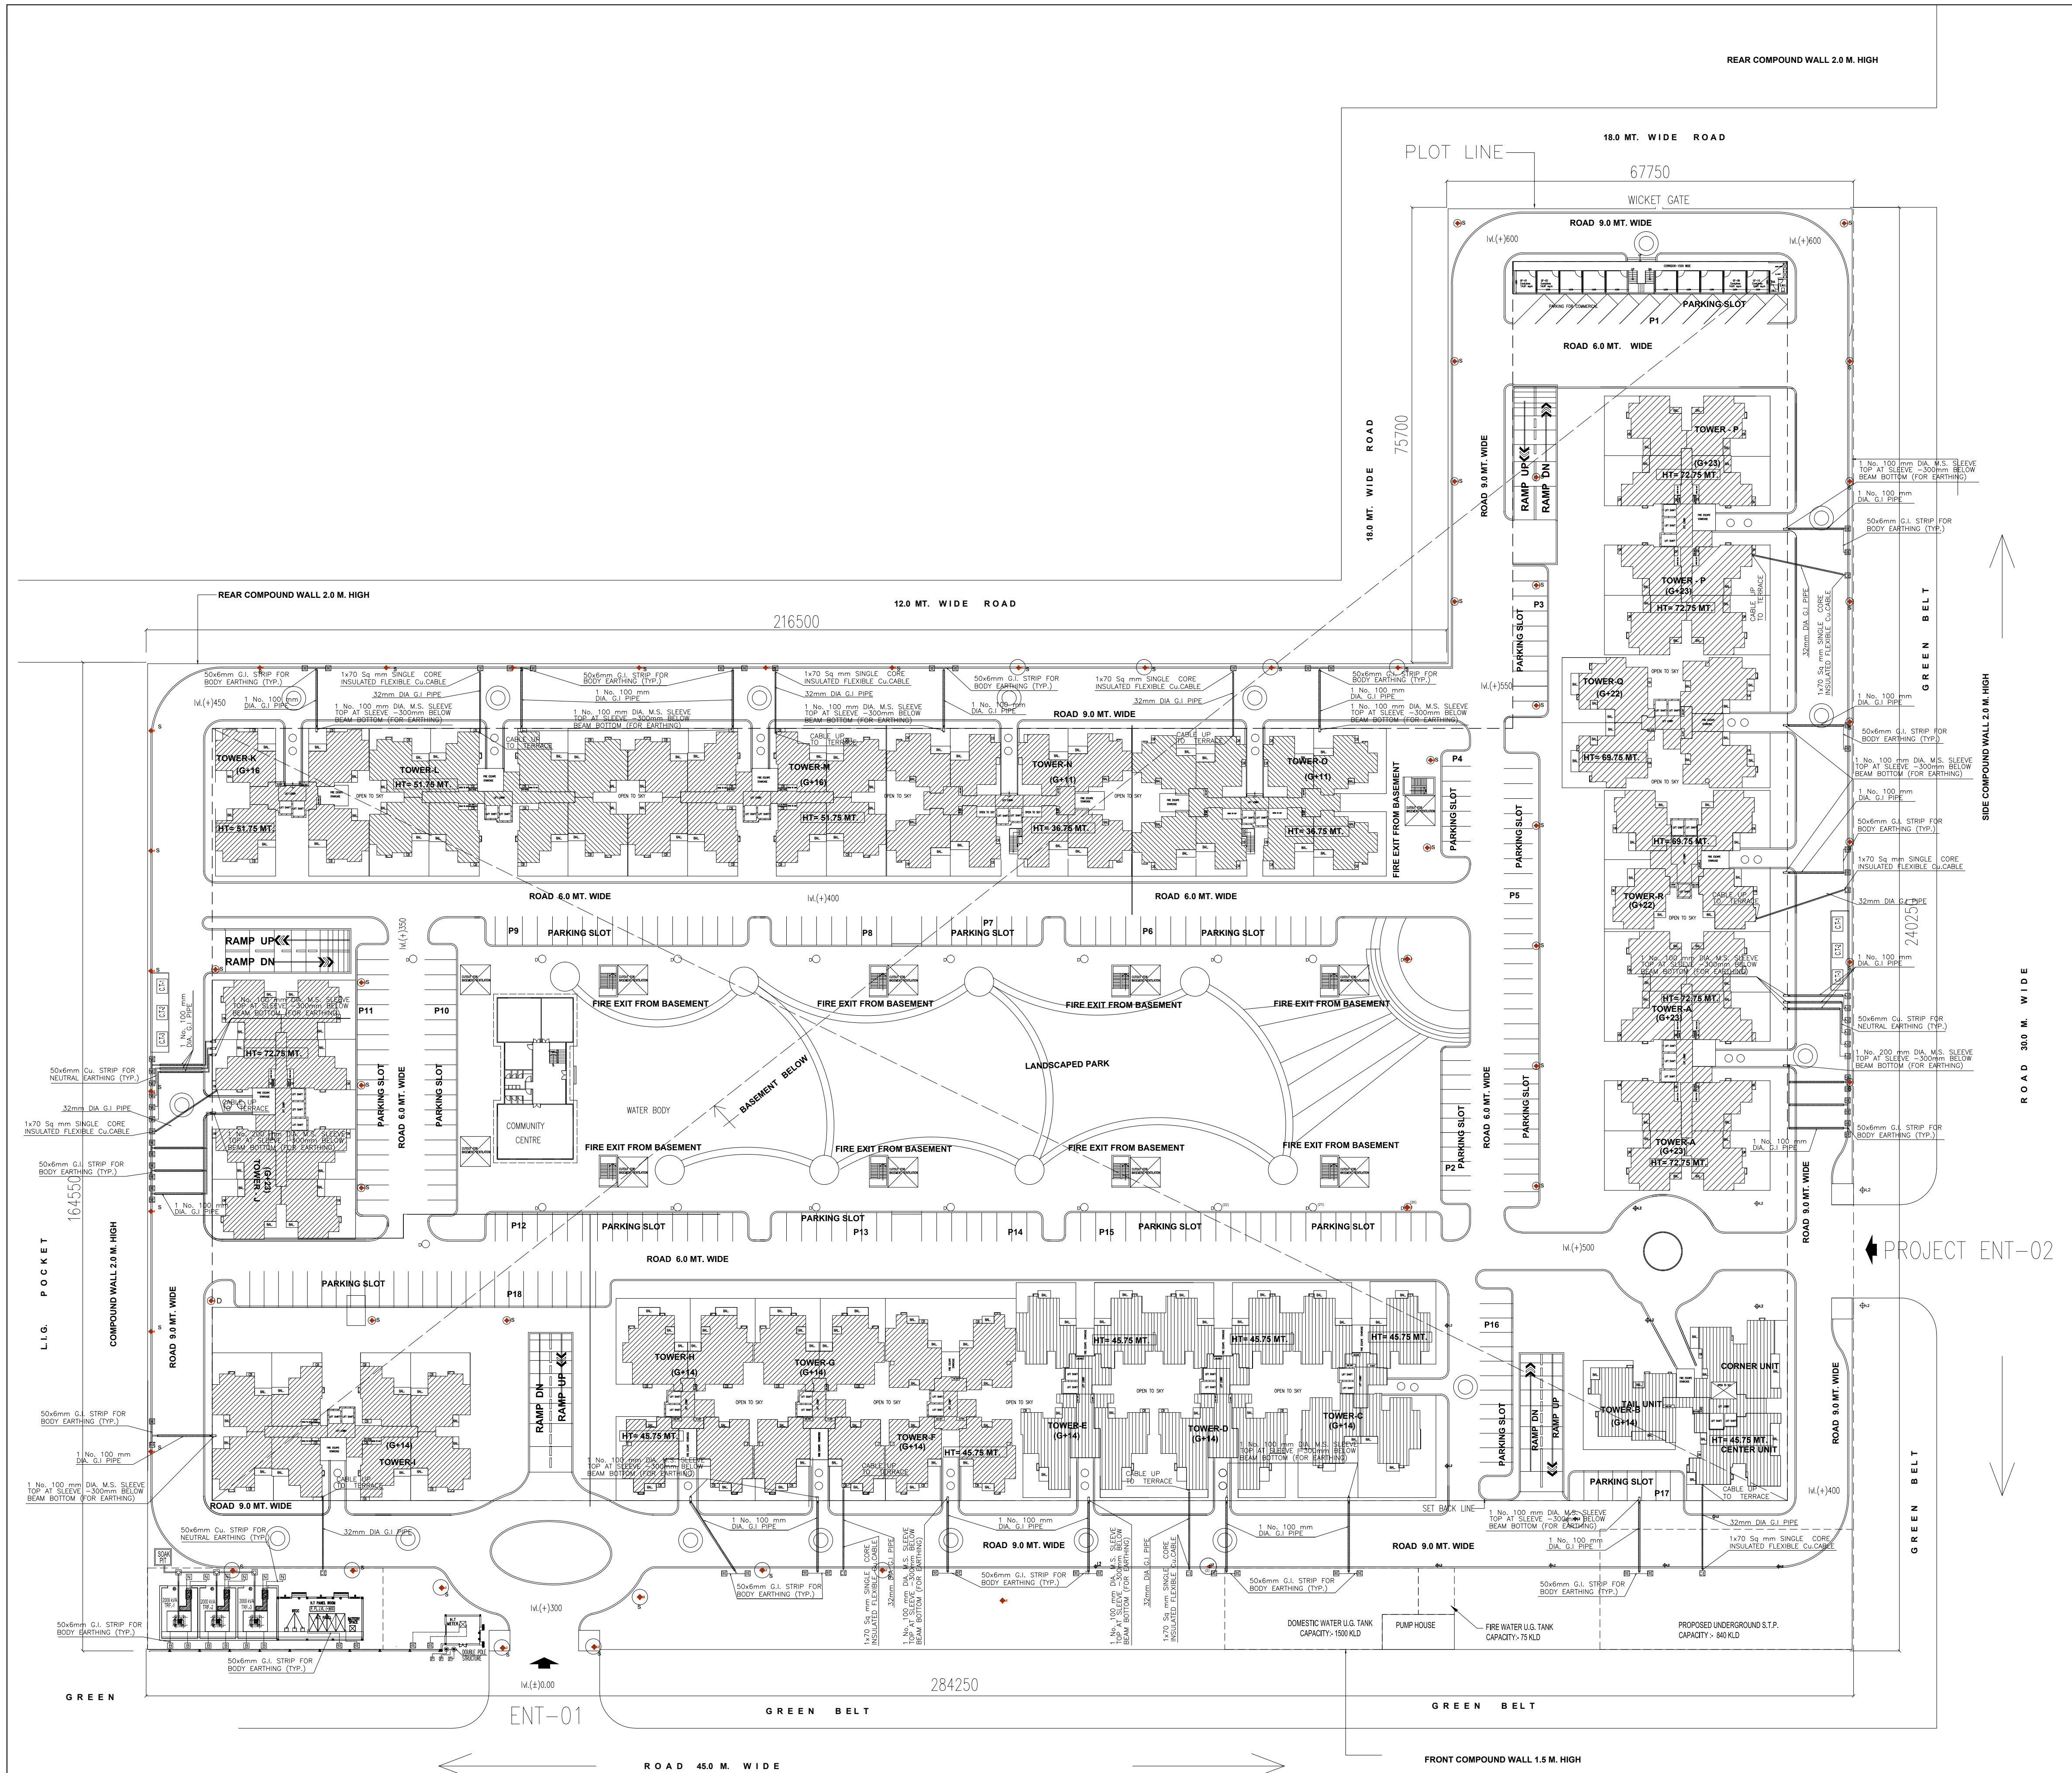

EARTHING NOTE:-

1. EACH TOWER HAVING 2NOS-PLATE EARTHING OF SIZE 600x600x6mm G.I. FROM EARTHING SET TO RISING MAIN 2x50x6mm G.I. STRIP THROUGH CABLE TRAY UP TO RISING MAIN UP TO TERRACE TO BE LAID.
2. FROM RISING MAIN TO EACH FLOOR 2x25mm G.I. STRIP TO TAPPED & CONNECT TO METERING PANEL AT EACH FLOOR.

SYMBOL	DESCRIPTION	MOU. HEIGHT
BE	600x600x6mm G.I. PLATE BODY EARTHING	IN GROUND
NE	600x600x6mm Cu. NEUTRAL EARTHING	IN GROUND
B	900x900x12mm G.I. PLATE BODY EARTHING	IN GROUND
N	900x900x6mm Cu. NEUTRAL EARTHING	IN GROUND
P	3 MTS LONG 100mm DIA G.I PIPE EARTHING	IN GROUND
CE	CHEMICAL EARTHING	IN GROUND

ARCHITECTS
SPACE COMBINE
ARCHITECTS, PLANNERS, ENGINEERS & PROJECT MANAGEMENT CONSULT.
A1/112, 2ND FLOOR,
SAFDARJUNG ENCLAVE, NEW DELHI-29.
PH:-46150000,

SHEET TITLE:
**SITE PLAN
ELECTRICAL LAYOUT**

SCALE : 1:400 DATE:-
DEALT BY : S.K DRG. NO.- EL-03
CHKD. BY : D.P.A

OWNER :
**M/S TODAY HOMES NOIDA
PVT. LTD. (SPC)**

ELECTRICAL CONSULTANT :-
D.P. ARORA & ASSOCIATES
GH-2/98-B, ANKUR APARTMENT
PASCHIM VIHAR-NEW DELHI-63
Ph.-M.-09312221486
E-mail: dpa.elc@gmail.com

PROJECT:
PROPOSED GROUP HOUSING AT PLOT NO-GH-01 SECTOR-135 NOIDA (U.P.)

ARCHITECT'S SIGN OWNER'S SIGN