

THIS DRAWING IS THE PROPERTY OF THE DERA AND SHALL NOT BE COPIED OR USED IN ANY MANNER WITHOUT PRIOR PERMISSION.

**REVISIONS OF DRAWINGS**

MARK	DATE	DESCRIPTION


**GENERAL NOTES**

1. ALL DIMENSIONS ARE IN MM UNTIL OR UNLESS SPECIFIED
2. ALL ARCHITECTURE & STRUCTURE DRAWINGS TO BE READ TOGETHER ALONG WITH ALL SERVICE DETAIL DRAWING
3. ALL DIMENSION MUST BE CHECKED ON SITE & WITH OTHER DRAWING BEFORE EXECUTION
4. DRAWING NOT TO BE SCALED, ONLY MENTIONING DIMENSION TO BE FOLLOWED
5. ANY DISCREPANCY, IF FOUND IN DRAWING OR ON SITE THE SAME WILL BE INFORMED TO CONSULTANTS OR ENGINEER IN CHARGE FOR PROPER CLARIFICATION

MARK	Symbol	ITEM
1		110mm uPVC Single 'Y'
2		110mm uPVC Class-3 W.W.P. Pipe
3		110mm uPVC 45° Bend
4		110mm uPVC Class-3 SWR Pipe
5		110mm uPVC Single 'Y'
6		110mm uPVC 45° Bend
7		110mm uPVC p trap
8		MANHOLE ( 600X600 )
9		GULLY TRAP

MARK	Symbol	ITEM	HEIGHT (FROM FLOOR FINISH LEVEL)
1		WASH BASIN	LVL+450MM
2		FLOOR MOUNTED W.C.	LVL+450MM
3		LONG BODY BIB-COCK	LVL+900MM
4		BIB-COCK HEALTH FAUCET	LVL+150MM
5		URINAL	600 MM FROM PFL
6		FLOOR TRAP	NT
7		BIB-COCK	LVL+1000MM
8		EQUAL TEE	
9		90° ELBOW	

S.No	Symbol	Symbol	ITEM
1			RAIN WATER PIPE
2			110MM SOIL PIPE RING FIT TYPE OF SLOPE 1:100
3			90MM WASTE PIPE FIT TYPE OF SLOPE 1:80
4			32MM COLD WATER PIPE

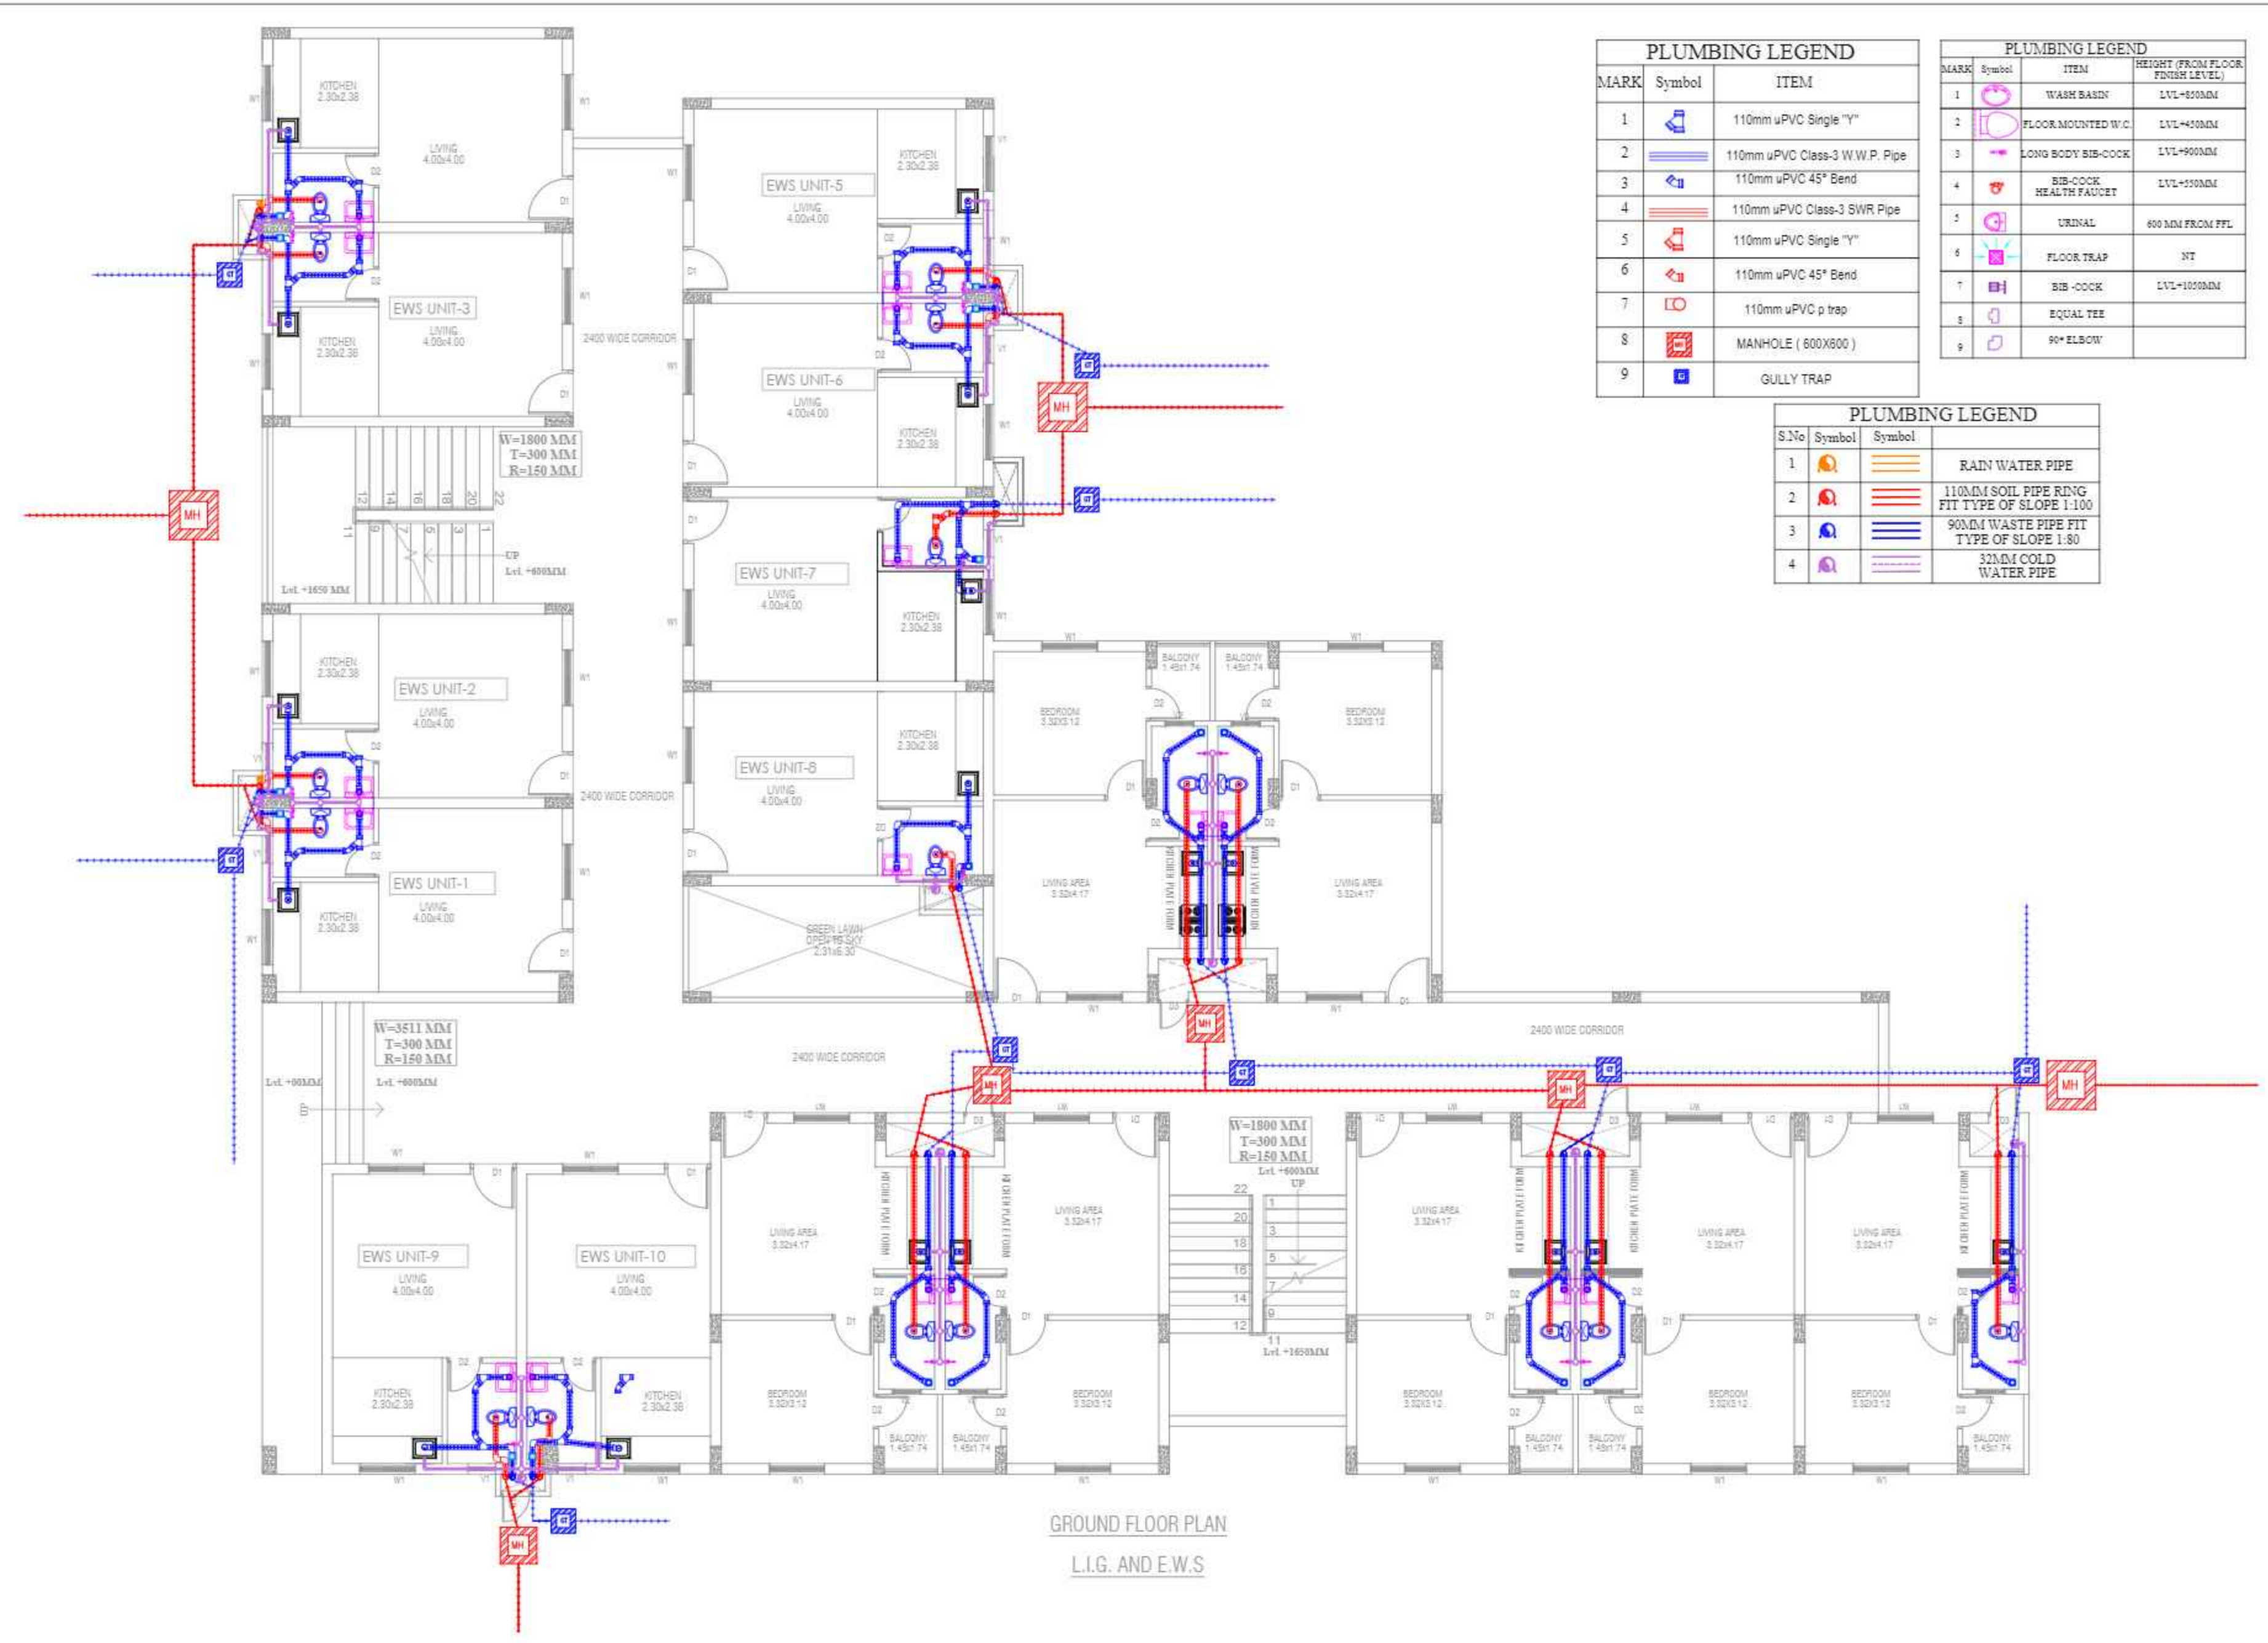

GROUND FLOOR PLAN  
L.I.G. AND E.W.S

**PROJECT DETAILS**

**CLIENT**  
Shri. Raghav Agrawal S/O Shri Ram Agrawal  
B/O 1349 BARADASHU DASHYAJA PLOT NO. 1314/1A/5432  
COLONY MARANT ROAD MATARURA

**ARCHITECT CONSULTANT**  
  
DERA Consultants Pvt. Ltd.  
305, GEETA ENCLAVE, KRISHNA NAGAR, MATHURA 201004  
Tel. : +91-5905871654, Email : office@dera.co.in  
(Authorised Signatory with Stamp)

**PROJECT TITLE**  
SHRI VRINDA ENCLAVE

**DRAWING TITLE**  
PLUMBING DETAIL GROUND FLOOR PLAN

**DRAWING PURPOSE**  
FOR APPROVAL

SCALE-	REVISION	DATE OF ISSUE-
		30/01/2023

DWG. NO.-	SHEET SIZE	SHEET NO.-
PL-101	A1	01/05
	DRAWN BY	CHECKED BY
	HG	DD

THIS DRAWING IS THE PROPERTY OF THE DERA AND SHALL NOT BE COPIED OR USED IN ANY MANNER WITHOUT PRIOR PERMISSION.



PLUMBING LEGEND		
MARK	Symbol	ITEM
1		110mm uPVC Single 'Y'
2		110mm uPVC Class-3 W.W.P. Pipe
3		110mm uPVC 45° Bend
4		110mm uPVC Class-3 SWR Pipe
5		110mm uPVC Single 'Y'
6		110mm uPVC 45° Bend
7		110mm uPVC p trap
8		MANHOLE ( 600X600 )
9		GULLY TRAP

PLUMBING LEGEND			
MARK	Symbol	ITEM	HEIGHT (FROM FLOOR FINISH LEVEL)
1		WASH BASIN	LVL+650MM
2		FLOOR MOUNTED W.C.	LVL+450MM
3		LONG BODY BIB-COCK	LVL+900MM
4		BIB-COCK HEALTH FAUCET	LVL+150MM
5		URINAL	600 MM FROM PFL
6		FLOOR TRAP	NT
7		BIB -COCK	LVL+1000MM
8		EQUAL TEE	
9		90° ELBOW	

PLUMBING LEGEND			
S.No	Symbol	Symbol	ITEM
1			RAIN WATER PIPE
2			110MM SOIL PIPE RING FIT TYPE OF SLOPE 1:100
3			90MM WASTE PIPE FIT TYPE OF SLOPE 1:80
4			32MM COLD WATER PIPE

REVISIONS OF DRAWINGS		
MARK	DATE	DESCRIPTION

**GENERAL NOTES**

- ALL DIMENSIONS ARE IN MM UNTIL OR UNLESS SPECIFIED
- ALL ARCHITECTURE & STRUCTURE DRAWINGS TO BE READ TOGETHER ALONG WITH ALL SERVICE DETAIL DRAWING
- ALL DIMENSION MUST BE CHECKED ON SITE & WITH OTHER DRAWING BEFORE EXECUTION
- DRAWING NOT TO BE SCALED, ONLY MENTIONING DIMENSION TO BE FOLLOWED
- ANY DISCREPANCY, IF FOUND IN DRAWING OR ON SITE THE SAME WILL BE INFORMED TO CONSULTANTS OR ENGINEER IN CHARGE FOR PROPER CLARIFICATION

PROJECT DETAILS		
<b>CLIENT</b>		
Shri. Raghav Agrawal S/O Shri Ram Agrawal B/O 1349 BARADASTI DASTI ALA PLOT NO. 1014 JAL SAZI COLONY MABANI ROAD MATRUHA		
<b>ARCHITECT CONSULTANT</b>		
DERA Consultants Pvt. Ltd. 305, GEETA ENCLAVE, KRISHNA NAGAR, MATRUHA 201004 Tel. : +91-9090871654, Email : office@dera.co.in <small>(Authorised Signatory with Stamp)</small>		
<b>PROJECT TITLE</b>		
SHRI VRINDA ENCLAVE		
<b>DRAWING TITLE</b>		
PLUMBING DETAIL FIRST FLOOR PLAN		
<b>DRAWING PURPOSE</b>		
FOR APPROVAL		
SCALE-	REVISION	DATE OF ISSUE-
		30/01/2023
DWG. NO.-		
PL-102		
SHEET SIZE	A1	SHEET NO-
		02/05
DRAWN BY	HG	CHECKED BY
		DD

FIRST FLOOR PLAN  
L.T.G. AND E.W.S.

THIS DRAWING IS THE PROPERTY OF THE DERA AND SHALL NOT BE COPIED OR USED IN ANY MANNER WITHOUT PRIOR PERMISSION.



PLUMBING LEGEND		
MARK	Symbol	ITEM
1		110mm uPVC Single 'Y'
2		110mm uPVC Class-3 W.W.P. Pipe
3		110mm uPVC 45° Bend
4		110mm uPVC Class-3 SWR Pipe
5		110mm uPVC Single 'Y'
6		110mm uPVC 45° Bend
7		110mm uPVC p trap
8		MANHOLE ( 600X600 )
9		GULLY TRAP

PLUMBING LEGEND			
MARK	Symbol	ITEM	HEIGHT (FROM FLOOR FINISH LEVEL)
1		WASH BASIN	LVL.+600MM
2		FLOOR MOUNTED W.C.	LVL.+400MM
3		LONG BODY BIB-COCK	LVL.+900MM
4		BIB-COCK HEALTH FAUCET	LVL.+500MM
5		URINAL	600 MM FROM PFL
6		FLOOR TRAP	NT
7		BIB -COCK	LVL.+1000MM
8		EQUAL TEE	
9		90° ELBOW	

PLUMBING LEGEND			
S.No	Symbol	Symbol	ITEM
1			RAIN WATER PIPE
2			110MM SOIL PIPE RING FIT TYPE OF SLOPE 1:100
3			90MM WASTE PIPE FIT TYPE OF SLOPE 1:80
4			32MM COLD WATER PIPE

REVISIONS OF DRAWINGS		
MARK	DATE	DESCRIPTION

**GENERAL NOTES**

- ALL DIMENSIONS ARE IN MM UNTIL OR UNLESS SPECIFIED
- ALL ARCHITECTURE & STRUCTURE DRAWINGS TO BE READ TOGETHER ALONG WITH ALL SERVICE DETAIL DRAWING
- ALL DIMENSION MUST BE CHECKED ON SITE & WITH OTHER DRAWING BEFORE EXECUTION
- DRAWING NOT TO BE SCALED, ONLY MENTIONING DIMENSION TO BE FOLLOWED
- ANY DISCREPANCY, IF FOUND IN DRAWING OR ON SITE THE SAME WILL BE INFORMED TO CONSULTANTS OR ENGINEER IN CHARGE FOR PROPER CLARIFICATION

**PROJECT DETAILS**

**CLIENT**  
 Shri. Raghav Agrawal S/O Shri Ram Agrawal  
 B.O. 1349 BARHADOLI DABAYAJA PLOT NO. 1314/2/1/5432  
 COLONY MABANI ROAD MATRUVA

**ARCHITECT CONSULTANT**  
  
**DERA Consultants Pvt. Ltd.**  
 305, GEETA ENCLAVE, KRISHNA NAGAR, MATHURA 201004  
 Tel. : +91-5909871654, Email : office@dera.co.in  
 (Authorised Signatory with Stamp)

**PROJECT TITLE**  
**SHRI VRINDA ENCLAVE**

**DRAWING TITLE**  
**PLUMBING DETAIL SECOND FLOOR PLAN**


**DRAWING PURPOSE**  
**FOR APPROVAL**

SCALE-	REVISION	DATE OF ISSUE-
		30/01/2023

DWG. NO.-	SHEET SIZE	SHEET NO.
PL-103	A1	03/05
	DRAWN BY	CHECKED BY
	HG	DD

**SECOND FLOOR PLAN**  
**L.I.G. AND E.W.S.**

THIS DRAWING IS THE PROPERTY OF THE DERA AND SHALL NOT BE COPIED OR USED IN ANY MANNER WITHOUT PRIOR PERMISSION.

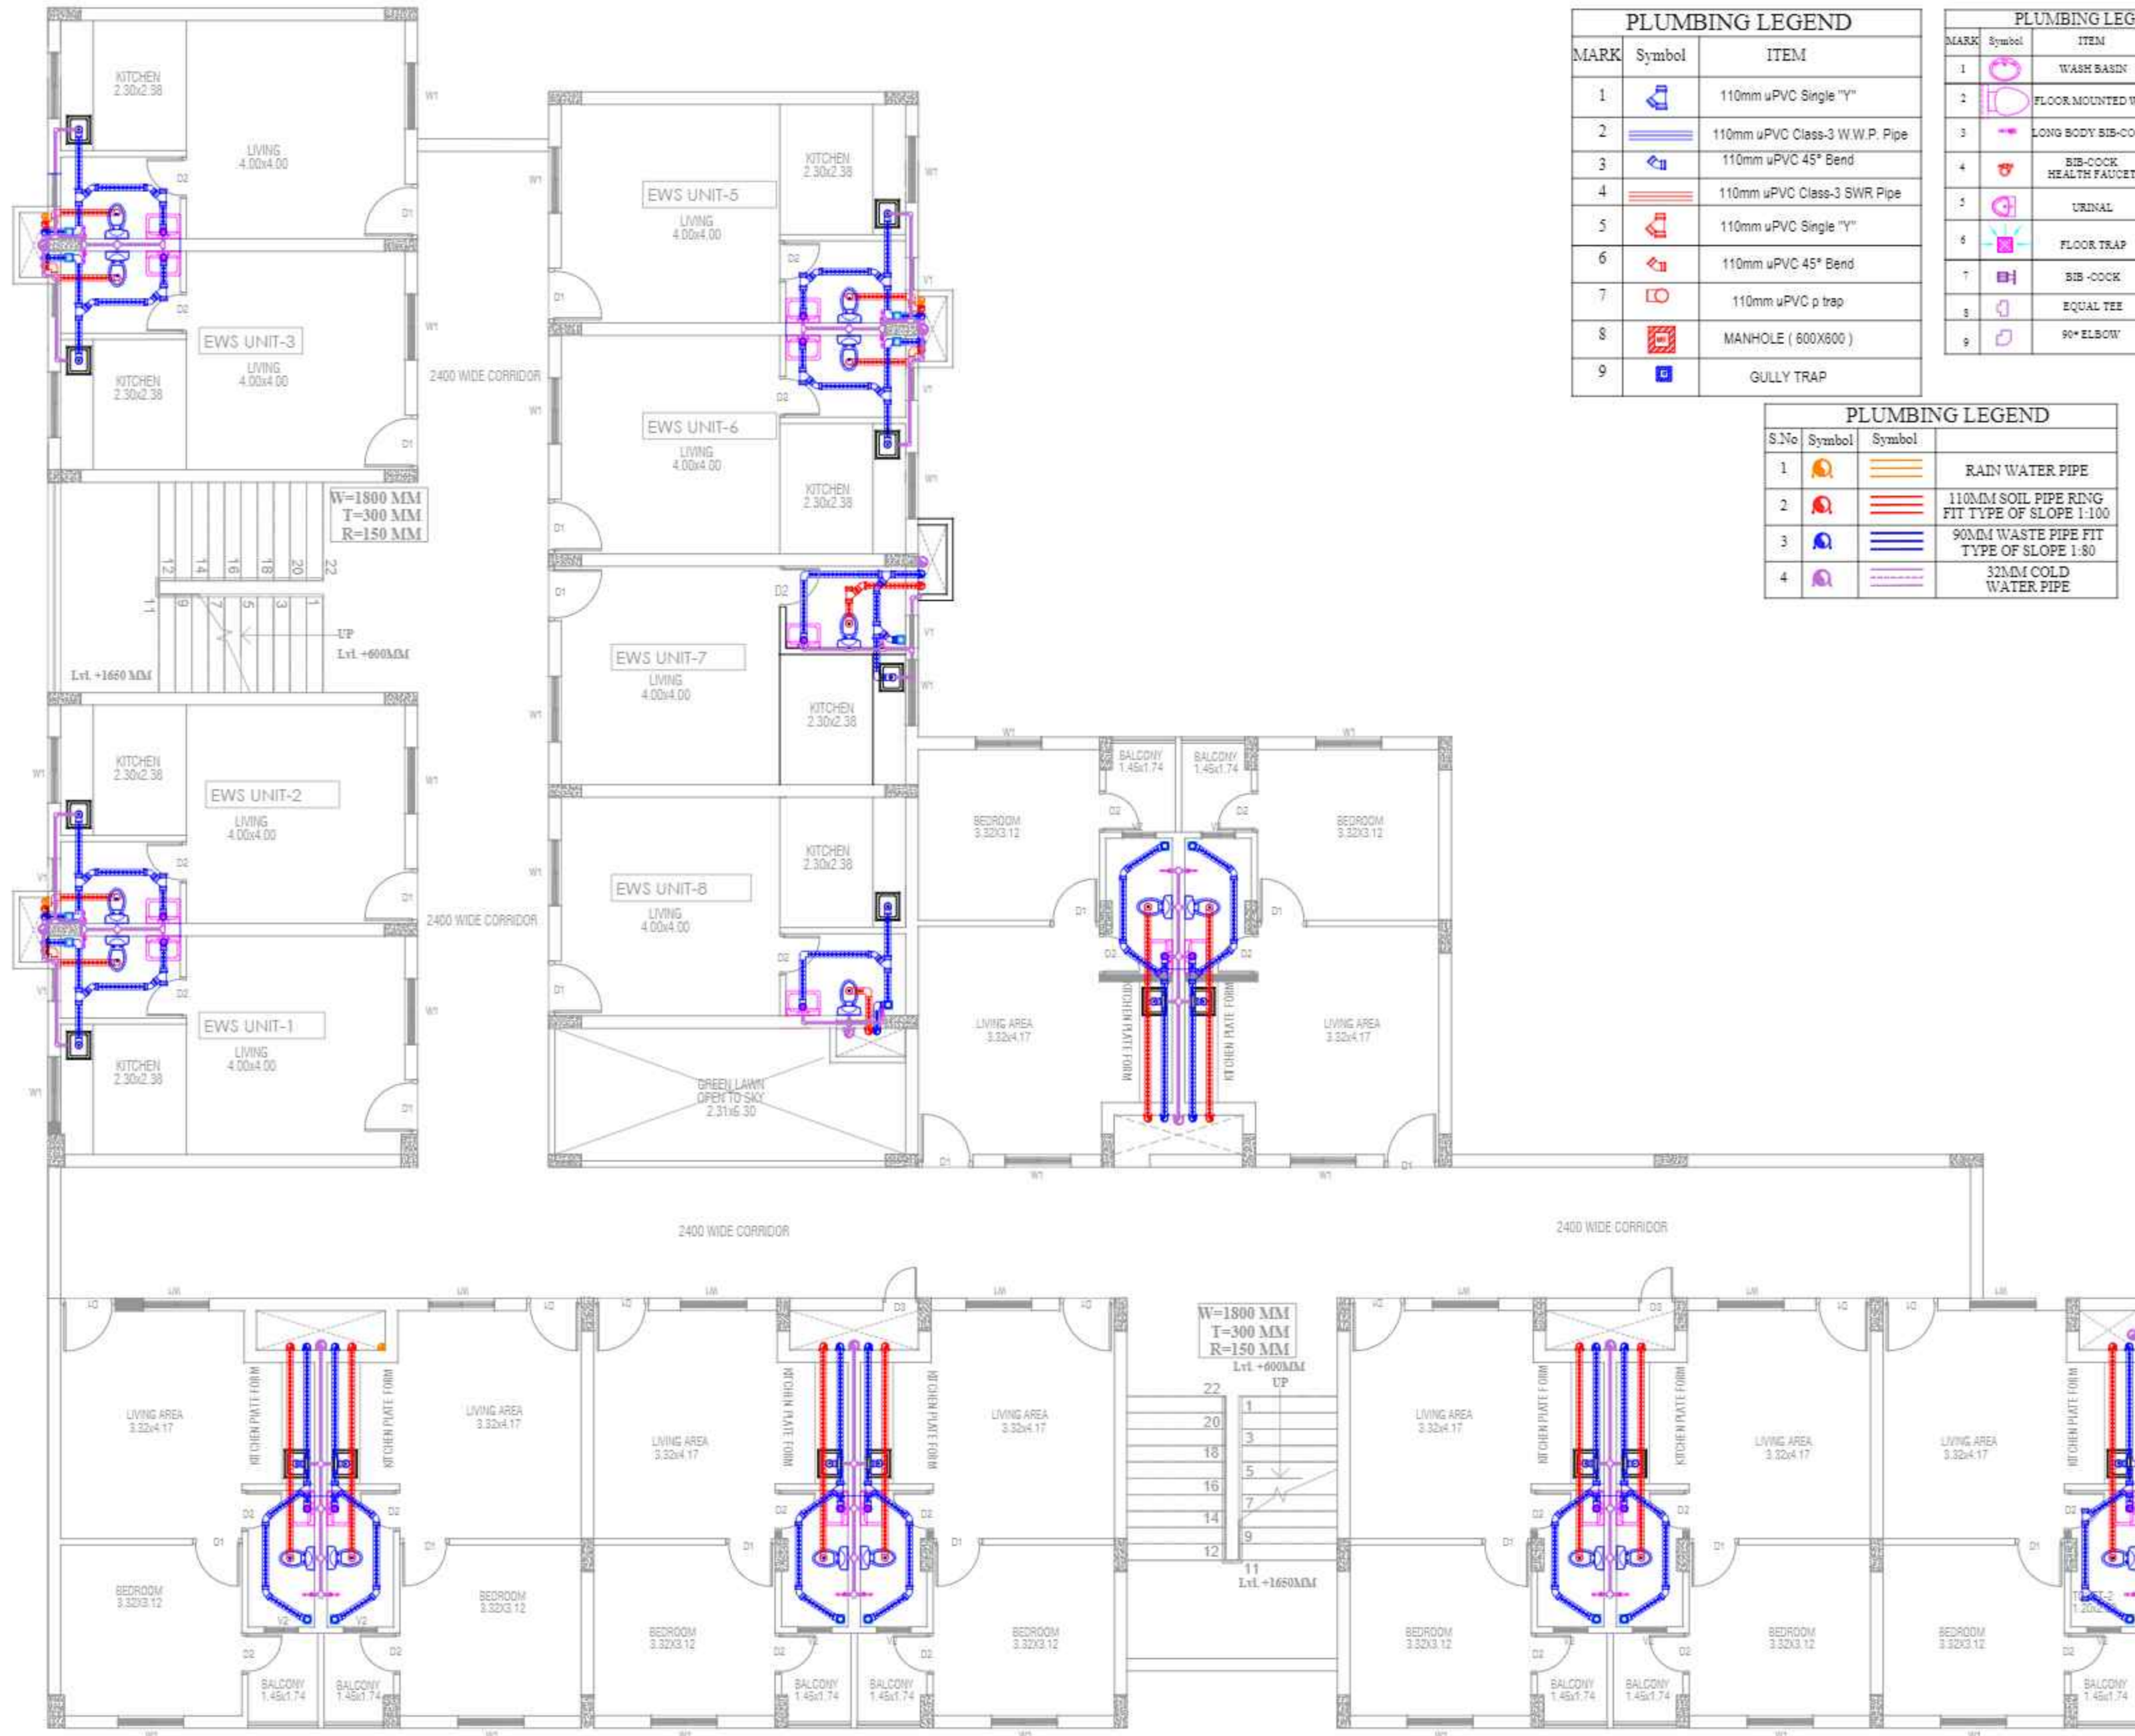

MARK	Symbol	ITEM
1		110mm uPVC Single "Y"
2		110mm uPVC Class-3 W.W.P. Pipe
3		110mm uPVC 45° Bend
4		110mm uPVC Class-3 SWR Pipe
5		110mm uPVC Single "Y"
6		110mm uPVC 45° Bend
7		110mm uPVC p trap
8		MANHOLE ( 600X600 )
9		GULLY TRAP

MARK	Symbol	ITEM	HEIGHT (FROM FLOOR FINISH LEVEL)
1		WASH BASIN	LVL+650MM
2		FLOOR MOUNTED W.C.	LVL+450MM
3		LONG BODY BIB-COCK	LVL+900MM
4		BIB-COCK HEALTH FAUCET	LVL+150MM
5		URINAL	600 MM FROM PFL
6		FLOOR TRAP	NT
7		BIB-COCK	LVL+1000MM
8		EQUAL TEE	
9		90° ELBOW	

S.No	Symbol	Symbol	ITEM
1			RAIN WATER PIPE
2			110MM SOIL PIPE RING FIT TYPE OF SLOPE 1:100
3			90MM WASTE PIPE FIT TYPE OF SLOPE 1:80
4			32MM COLD WATER PIPE

REVISIONS OF DRAWINGS		
MARK	DATE	DESCRIPTION

- GENERAL NOTES**
- ALL DIMENSIONS ARE IN MM UNLESS OTHERWISE SPECIFIED.
  - ALL ARCHITECTURE & STRUCTURE DRAWINGS TO BE READ TOGETHER ALONG WITH ALL SERVICE DETAIL DRAWING.
  - ALL DIMENSION MUST BE CHECKED ON SITE & WITH OTHER DRAWING BEFORE EXECUTION.
  - DRAWING NOT TO BE SCALED, ONLY MENTIONING DIMENSION TO BE FOLLOWED.
  - ANY DISCREPANCY, IF FOUND IN DRAWING OR ON SITE THE SAME WILL BE INFORMED TO CONSULTANTS OR ENGINEER IN CHARGE FOR PROPER CLARIFICATION.

PROJECT DETAILS		
<b>CLIENT</b>		
Shri. Raghav Agrawal S/O Shri Ram Agrawal B/O 1349 BARHADGU DABAYALA PLOT NO. 1014 JALSAKEL COLONY MARIANT ROAD MATAPURA		
<b>ARCHITECT CONSULTANT</b>		
DERA Consultants Pvt. Ltd. 305, GEETA ENCLAVE, KRISHNA NAGAR, MATHURA 201004 Tel. : +91-5909871854, Email : office@dera.co.in		
(Authorised Signatory with Stamp)		
<b>PROJECT TITLE</b>		
SHRI VRINDA ENCLAVE		
<b>DRAWING TITLE</b>		
PLUMBING DETAIL THIRD FLOOR PLAN		
<b>DRAWING PURPOSE</b>		
FOR APPROVAL		
SCALE-	REVISION	DATE OF ISSUE-
		30/01/2023
DWG. NO.-		
PL-104		
SHEET SIZE	A1	SHEET NO.-
		04/05
DRAWN BY	HG	CHECKED BY
		DD

THIRD FLOOR PLAN  
L.I.G. AND E.W.S

THIS DRAWING IS THE PROPERTY OF THE DERA AND SHALL NOT BE COPIED OR USED IN ANY MANNER WITHOUT PRIOR PERMISSION.

**REVISIONS OF DRAWINGS**


MARK	DATE	DESCRIPTION

**GENERAL NOTES**

1. ALL DIMENSIONS ARE IN MM UNLESS OTHERWISE SPECIFIED.
2. ALL ARCHITECTURE & STRUCTURE DRAWINGS TO BE READ TOGETHER ALONG WITH ALL SERVICE DETAIL DRAWING.
3. ALL DIMENSIONS MUST BE CHECKED ON SITE & WITH OTHER DRAWING BEFORE EXECUTION.
4. DRAWING NOT TO BE SCALED, ONLY MENTIONING DIMENSION TO BE FOLLOWED.
5. ANY DISCREPANCY, IF FOUND IN DRAWING OR ON SITE THE SAME WILL BE INFORMED TO CONSULTANTS OR ENGINEER IN CHARGE FOR PROPER CLARIFICATION.

S.No	Symbol	Symbol	DESCRIPTION
1			RAIN WATER PIPE
2			110MM SOIL PIPE RING FIT TYPE OF SLOPE 1:100
3			90MM WASTE PIPE FIT TYPE OF SLOPE 1:80
4			32MM COLD WATER PIPE

MARK	Symbol	ITEM
1		FIRE FIGHTING LINE
2		DWS PRM 40MM/10
3		DWS CHARGE PRM 40MM/10

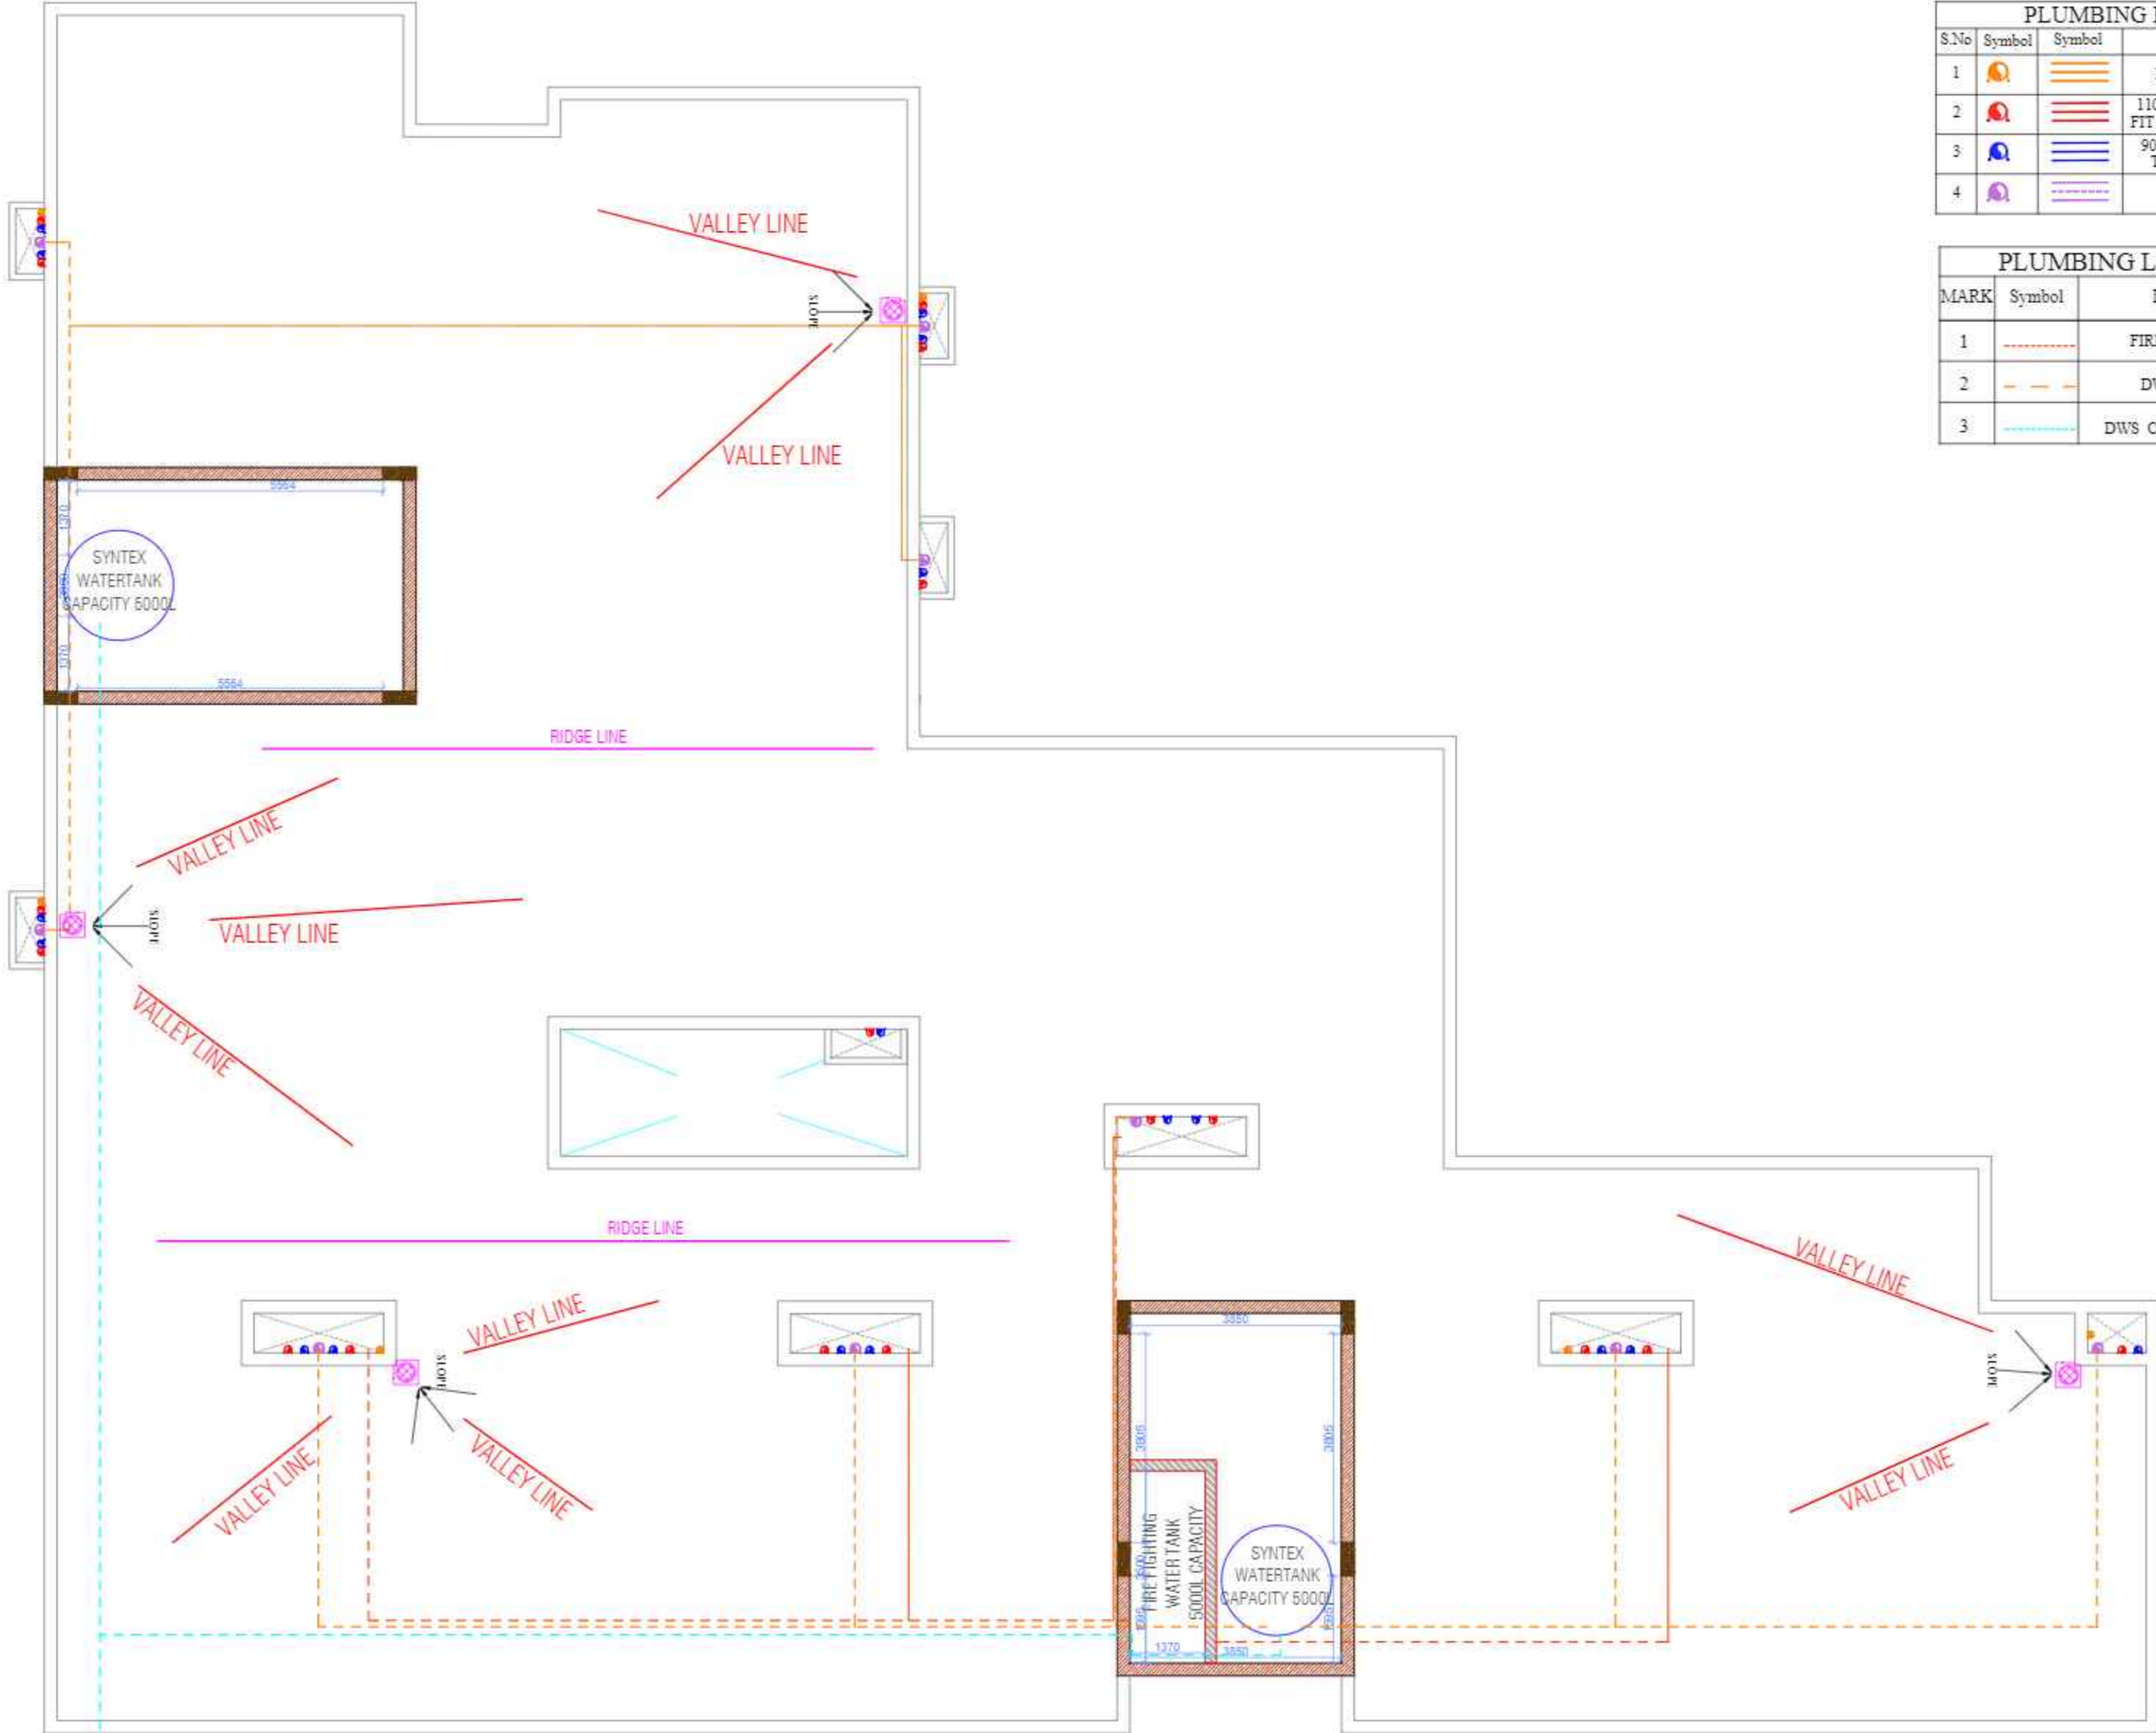

TERRACE FLOOR PLAN  
L.I.G. AND E.W.S

**PROJECT DETAILS**

**CLIENT**  
Shri Raghav Agrawal S/O Shri Ram Agrawal  
B/O 1349 BARHADANU DARIWALIA PLOT NO. 1314/1A/5422  
COLONY MABANI ROAD MATHURA

**ARCHITECT CONSULTANT**  
  
DERA Consultants Pvt. Ltd.  
305, GEETA ENCLAVE, KRISHNA NAGAR, MATHURA 201004  
Tel. : +91-8909871654, Email : office@dera.co.in  
(Authorised Signatory with Stamp)

**PROJECT TITLE**  
**SHRI VRINDA ENCLAVE**

**DRAWING TITLE**  
**PLUMBING DETAIL TERRACE FLOOR PLAN**

**DRAWING PURPOSE**  
FOR APPROVAL

SCALE-	REVISION	DATE OF ISSUE-
		30/01/2023

DWG. NO. - PL-105

SHEET SIZE	SHEET NO.
A1	05/05
DRAWN BY	CHECKED BY
HG	DD