

② UPPER GROUND FLOOR PLAN (+1800 LVL)
0:00

PLUMBING LEGEND:		
S.No.	SYM	DESCRIPTION
1.	①	1000 CI SOIL & VENT PIPE
2.	②	1000 CI WASTE & VENT PIPE
3.	③	DWS DN TAKE PIPE
4.	④	FWS DN TAKE PIPE
5.	⑤	320 DWS RISER PIPE
6.	⑥	250 FWS RISER PIPE
7.	⑦	110 OD uPVC RAIN WATER PIPE
8.	FD	FLOOR DRAIN (100x50) GI ELBOW
9.	FT	FLOOR TRAP (100x100)
10.	COP	CLEAN OUT PLUG (1000)
11.	FCO	FLOOR CLEAN OUT (1000)
12.	DWS	DOMESTIC WATER SUPPLY
13.	FWS	FLUSHING WATER SUPPLY
14.	KH	KHURRA (450x450)

NOTE:-
ALL DIMENSION ARE IN MM

Sl. NO.	DATE	DESCRIPTION	DRAWING NO.

REVISIONS

PROJECT TITLE :-
**COMMERCIAL
19911_2222_SIDHARTH
VIHAR-GHAZIABAD**


DRG. TITLE :-
**PLUMBING LAYOUT OF UPPER
GROUND FLOOR PLAN**

MEP CONSULTANTS:
Metaphor Consultant
212, 2nd Floor, SRBC Tower, Sec-9,
Vasundhara, Ghaziabad-201012
E-mail: info@metaphorconsultants.in
metaphorconsult@gmail.com
Tel: 120-4222878

EPC ARCHITECT :-
STUDIO RHIZOME
P-2/21 DLF Phase-2
Gurugram-122001
Unit 27, 18-20 Newton St.
Alexandria NSW 2015
Project Office : Gurugram
Phone - 0124-4351477
info@studiorhizome.com
www.studiorhizome.com

DETAILED BY :- VIVEK	CHECKED BY:- ANURAG	
DATE :- 01.04.2022	REVISION :- R0	
SCALE :-	DRG. NO :-	

NOTE:-
ALL DIMENSION ARE IN MM

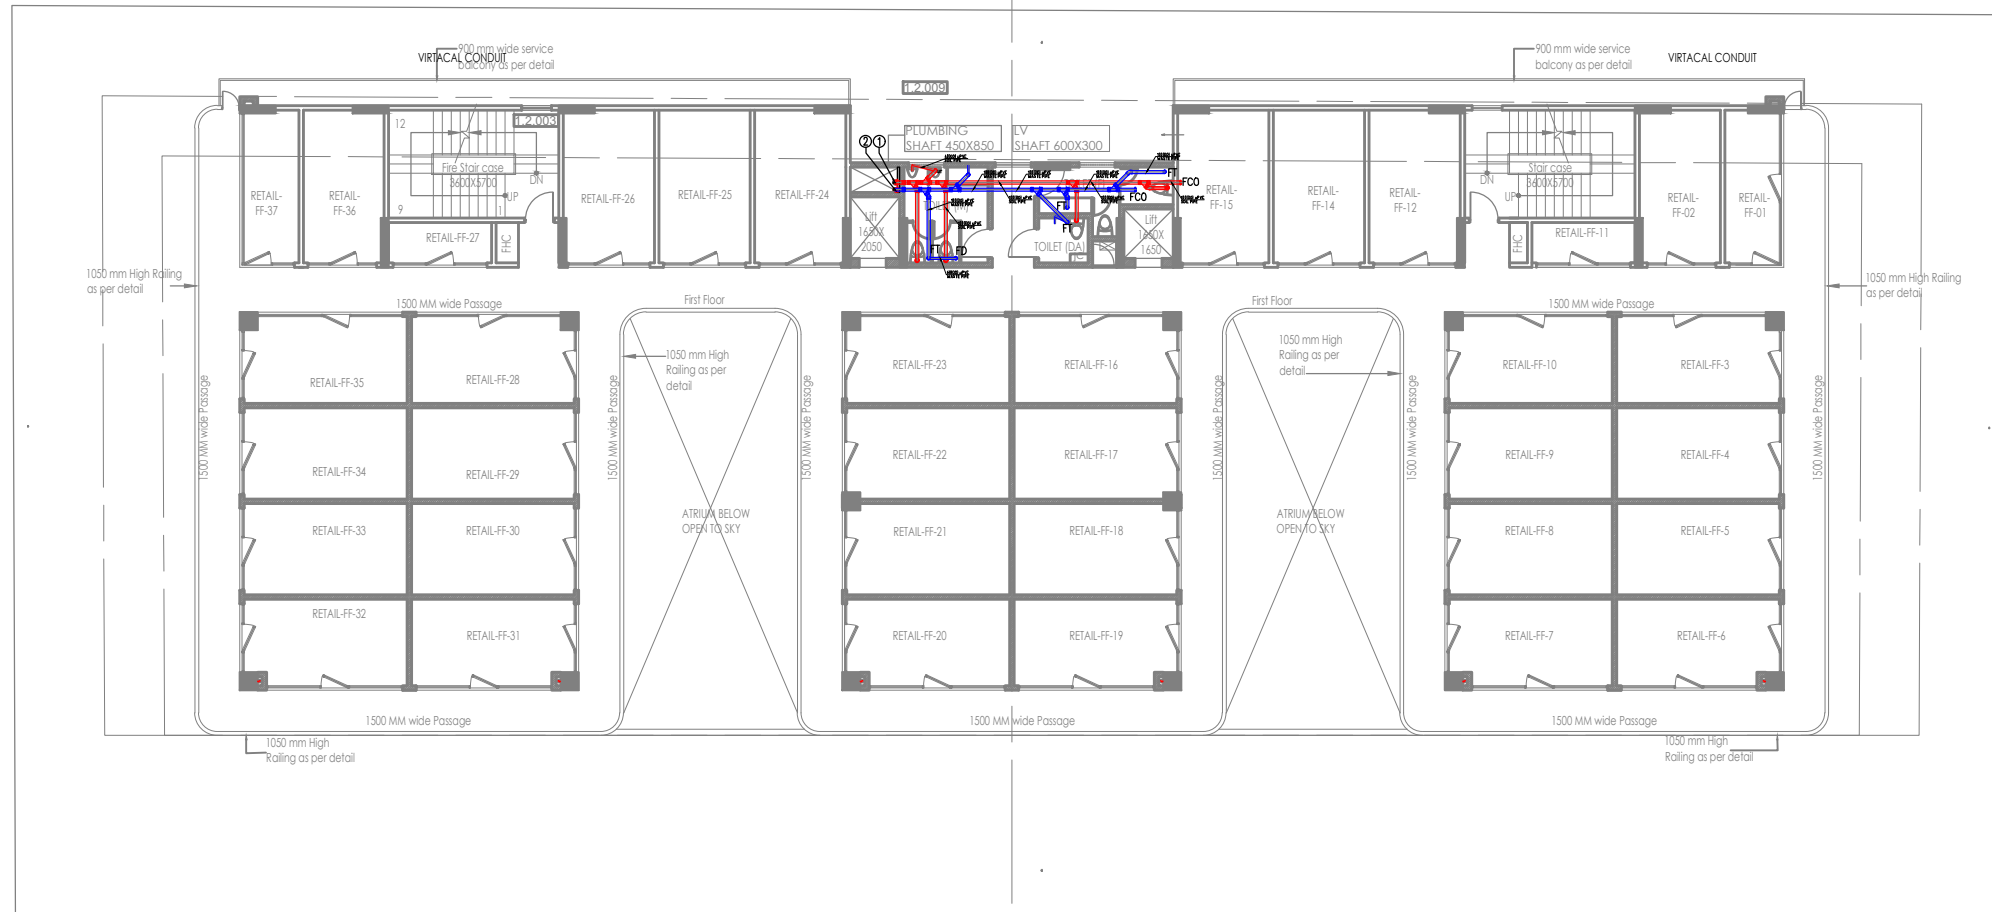

3 FIRST FLOOR PLAN (+5500LVL)
0:00

PLUMBING LEGEND:		
S.No.	SYM	DESCRIPTION
1.	①	100Ø CI SOIL & VENT PIPE
2.	②	100Ø CI WASTE & VENT PIPE
3.	③	DWS DN TAKE PIPE
4.	④	FWS DN TAKE PIPE
5.	⑤	32Ø DWS RISER PIPE
6.	⑥	25Ø FWS RISER PIPE
7.	⑦	110 OD uPVC RAIN WATER PIPE
8.	FD	FLOOR DRAIN (100x50) GI ELBOW
9.	FT	FLOOR TRAP (100x100)
10.	COP	CLEAN OUT PLUG (100Ø)
11.	FCO	FLOOR CLEAN OUT (100Ø)
12.	DWS	DOMESTIC WATER SUPPLY
13.	FWS	FLUSHING WATER SUPPLY
14.	KH	KHURRA (450x450)

Sl. NO.	DATE	DESCRIPTION	DRAWING NO.
---------	------	-------------	-------------

REVISIONS
PROJECT TITLE :-
**COMMERCIAL
19911_2222_SIDHARTH
VIHAR-GHAZIABAD**


DRG. TITLE :-
**PLUMBING LAYOUT OF
FIRST FLOOR PLAN**

MEP CONSULTANTS:
Metaphor Consultant
212, 2nd Floor, SRBC Tower, Sec-9,
Vasundhara, Ghaziabad-201012
E-mail: info@metaphorconsultants.in
metaphorconsult@gmail.com
Tel: 120-4222878

EPC ARCHITECT :-
STUDIO RHIZOME
Architecture | Design | Urbanism
Gurugram | Sydney
P-2/21 DLF Phase-2
Gurugram-122001
Unit 27, 18-20 Newton St.
Alexandria NSW 2015
Project Office : Gurugram
Phone - 0124-4351477
info@studiorhizome.com
www.studiorhizome.com

DETAILED BY :- VIVEK	CHECKED BY:- ANURAG	
DATE :- 01.04.2022	REVISION :- R0	
SCALE :- ----	DRG. NO :-	

NOTE:-
ALL DIMENSION ARE IN MM

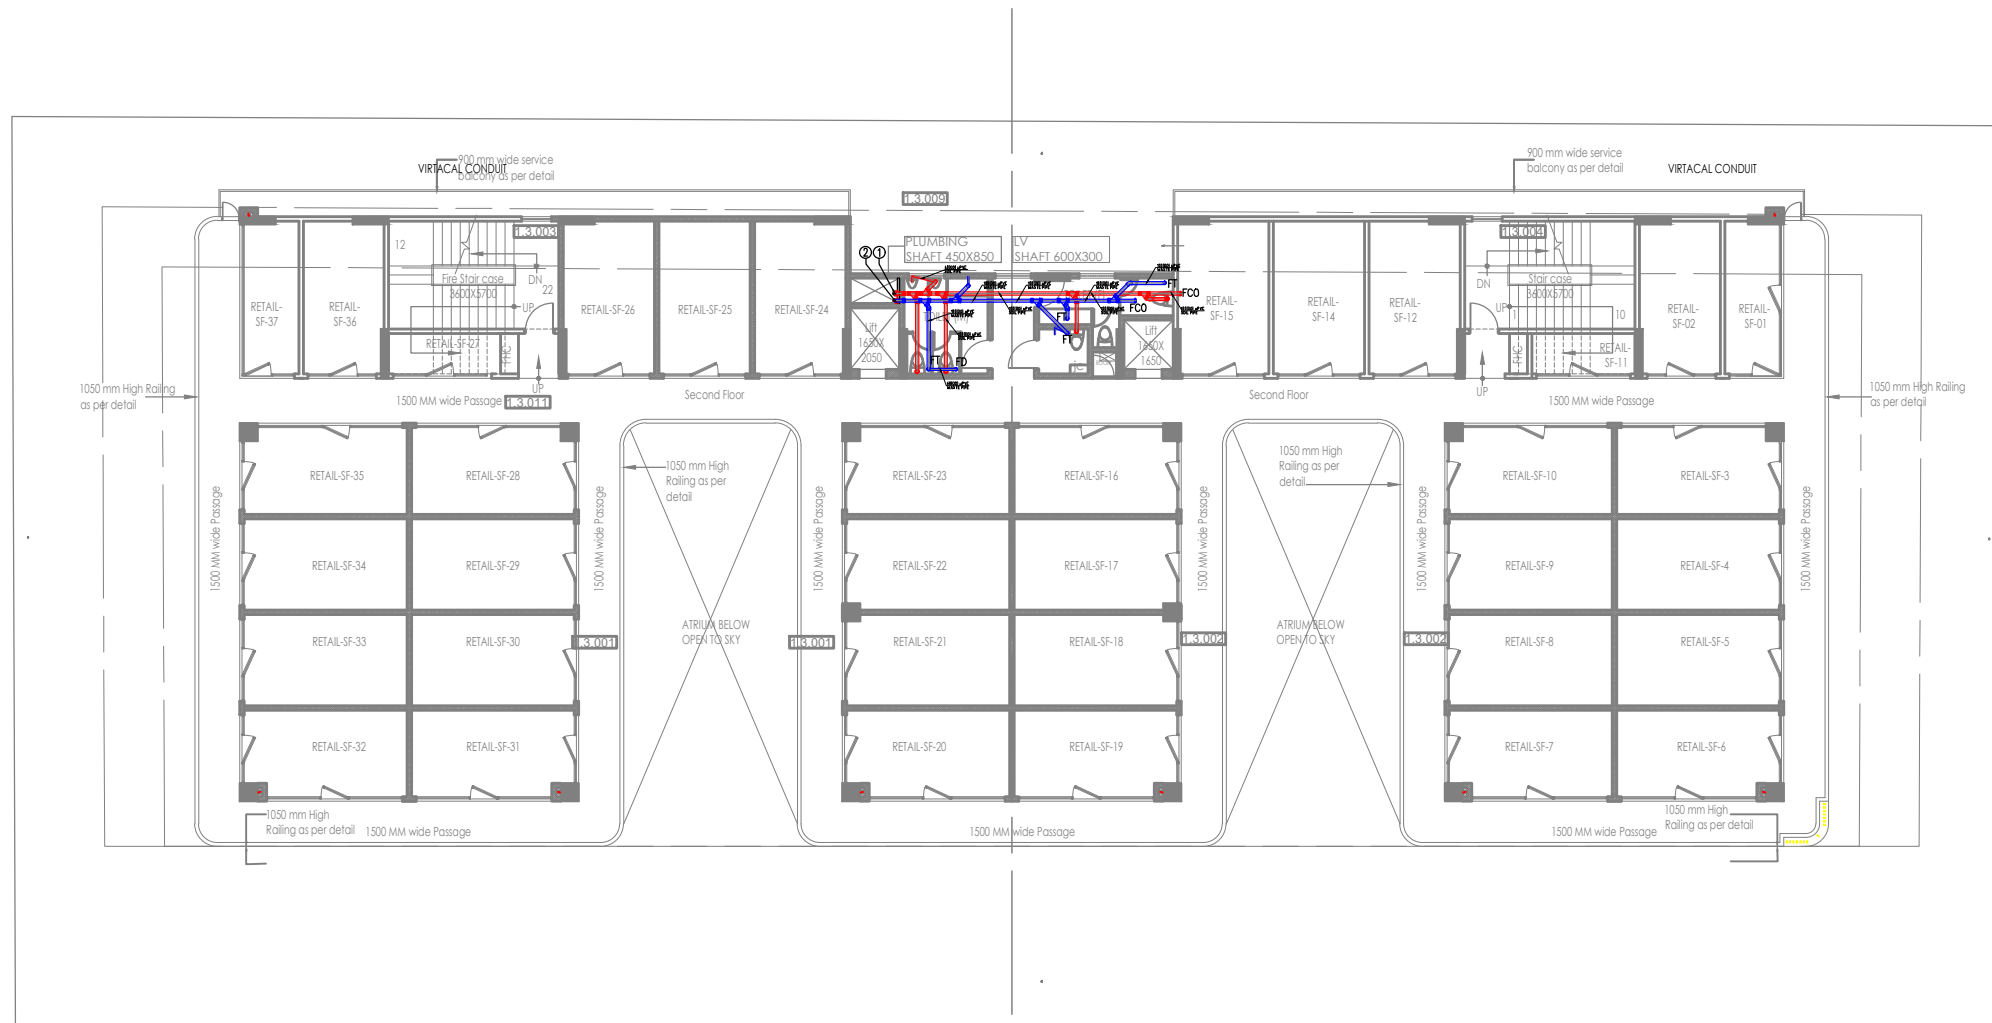

3 SECOND FLOOR PLAN (+8750 LVL)
0:00

PLUMBING LEGEND:

S.No.	SYM	DESCRIPTION
1.	①	100Ø CI SOIL & VENT PIPE
2.	②	100Ø CI WASTE & VENT PIPE
3.	③	DWS DN TAKE PIPE
4.	④	FWS DN TAKE PIPE
5.	⑤	32Ø DWS RISER PIPE
6.	⑥	25Ø FWS RISER PIPE
7.	⑦	110 OD uPVC RAIN WATER PIPE
8.	FD	FLOOR DRAIN (100x50) GI ELBOW
9.	FT	FLOOR TRAP (100x100)
10.	COP	CLEAN OUT PLUG (100Ø)
11.	FCO	FLOOR CLEAN OUT (100Ø)
12.	DWS	DOMESTIC WATER SUPPLY
13.	FWS	FLUSHING WATER SUPPLY
14.	KH	KHURRA (450x450)

Sl. NO.	DATE	DESCRIPTION	DRAWING NO.
---------	------	-------------	-------------

REVISIONS

PROJECT TITLE :-
**COMMERCIAL
19911_2222_SIDHARTH
VIHAR - GHAZIABAD**


DRG. TITLE :-
**PLUMBING LAYOUT OF
SECOND FLOOR PLAN**

MEP CONSULTANTS:
Metaphor Consultant
212, 2nd Floor, SRBC Tower, Sec-9,
Vasundhara, Ghaziabad-201012
E-mail: info@metaphorconsultants.in
metaphorconsult@gmail.com
Tel: 120-4222878

EPC ARCHITECT :-
STUDIO RHIZOME
Architecture | Design | Urbanism
Gurugram | Sydney
P-2/21 DLF Phase-2
Gurugram-122001
Unit 27, 18-20 Newton St.
Alexandria NSW 2015
Project Office : Gurugram
Phone - 0124-4351477
info@studiorhizome.com
www.studiorhizome.com

DETAILED BY :- VIVEK	CHECKED BY:- ANURAG	
DATE :- 01.04.2022	REVISION :- R0	
SCALE :- ----	DRG. NO :-	

NOTE:-
ALL DIMENSION ARE IN MM

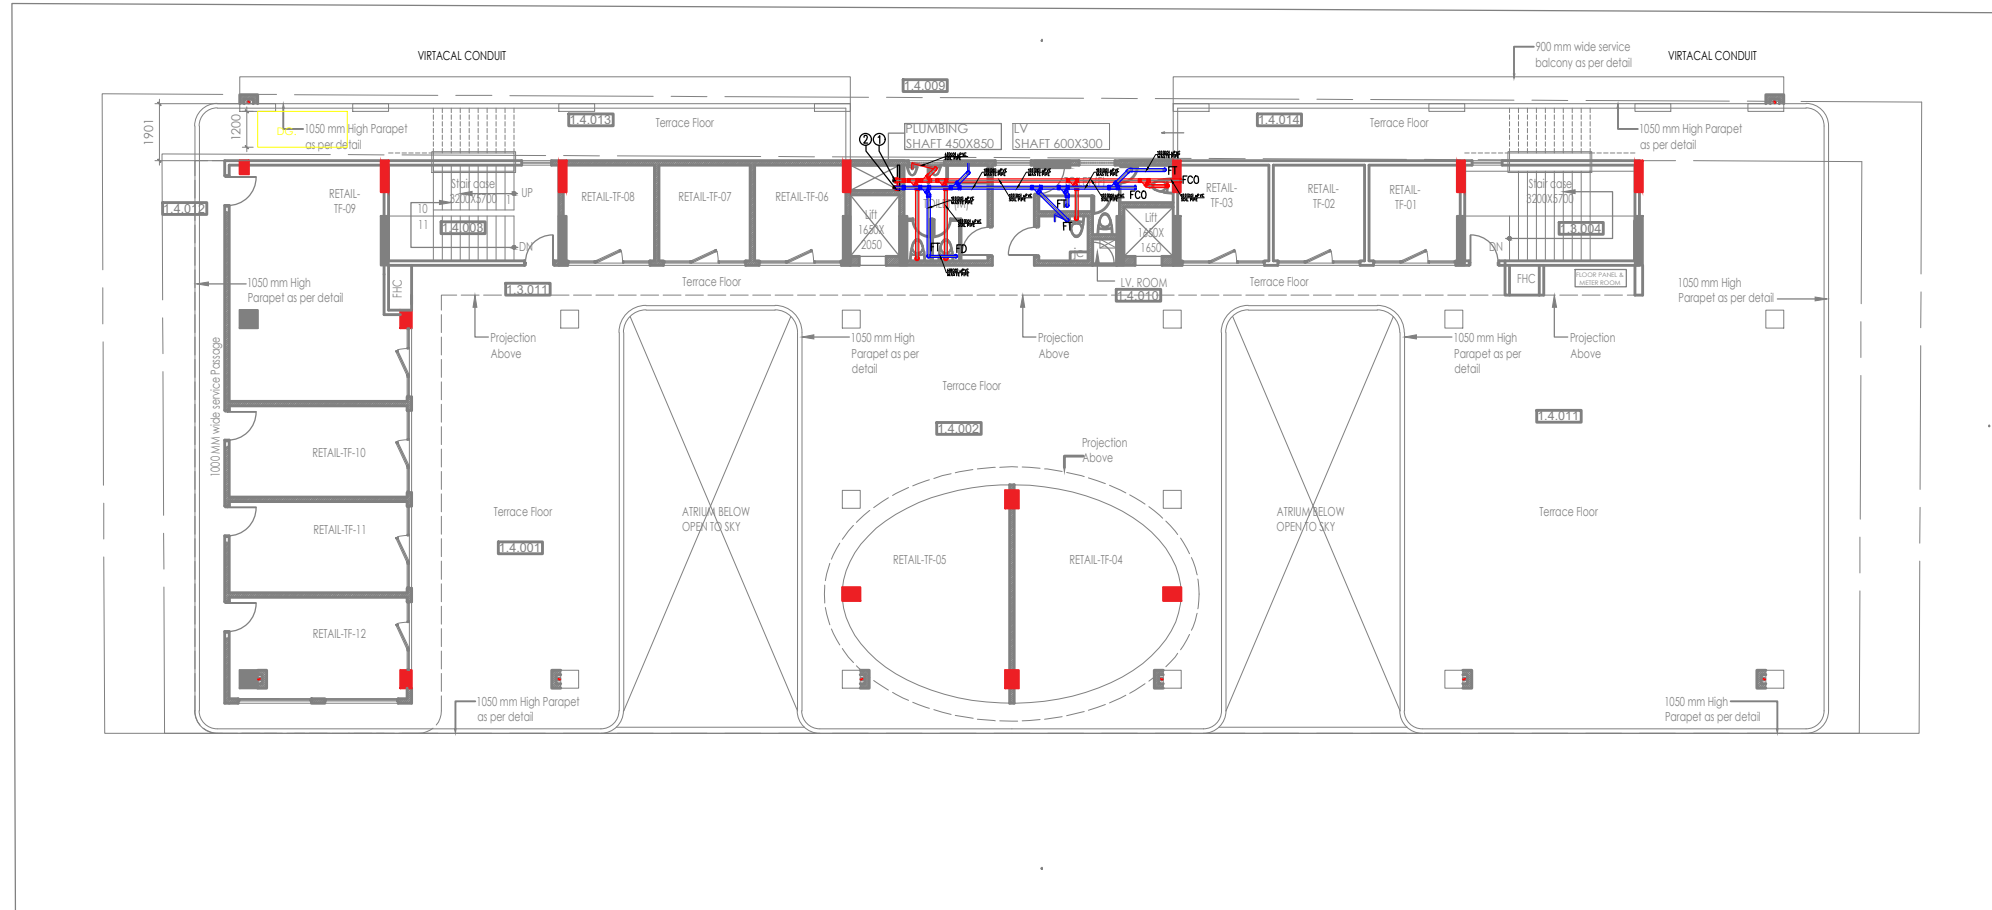

3 THIRD FLOOR PLAN (+12000 LVL)
0:00

PLUMBING LEGEND:		
S.No.	SYM	DESCRIPTION
1.	①	100Ø CI SOIL & VENT PIPE
2.	②	100Ø CI WASTE & VENT PIPE
3.	③	DWS DN TAKE PIPE
4.	④	FWS DN TAKE PIPE
5.	⑤	32Ø DWS RISER PIPE
6.	⑥	25Ø FWS RISER PIPE
7.	⑦	110 OD uPVC RAIN WATER PIPE
8.	FD	FLOOR DRAIN (100x50) GI ELBOW
9.	FT	FLOOR TRAP (100x100)
10.	COP	CLEAN OUT PLUG (100Ø)
11.	FCO	FLOOR CLEAN OUT (100Ø)
12.	DWS	DOMESTIC WATER SUPPLY
13.	FWS	FLUSHING WATER SUPPLY
14.	KH	KHURRA (450x450)

Sl. NO.	DATE	DESCRIPTION	DRAWING NO.
---------	------	-------------	-------------

REVISIONS

PROJECT TITLE :-

COMMERCIAL
19911_2222_SIDHARTH
VIHAR-GHAZIABAD

DRG. TITLE :-


PLUMBING LAYOUT OF
THIRD FLOOR PLAN


MEP CONSULTANTS:


Metaphor Consultant
 212, 2nd Floor, SRBC Tower, Sec-9,
 Vasundhara, Ghaziabad-201012
 E-mail: info@metaphorconsultants.in
 metaphorconsult@gmail.com
 Tel: 120-4222878

EPC ARCHITECT :-


STUDIO RHIZOME
 Architecture | Design | Urbanism
 Gurugram | Sydney
 P-2/21 DLF Phase-2
 Gurugram-122001
 Unit 27, 18-20 Newton St.
 Alexandria NSW 2015
Project Office : Gurugram
 Phone - 0124-4351477
 info@studiorhizome.com
 www.studiorhizome.com

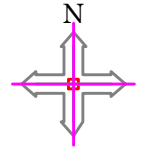DETAILED BY :- VIVEK	CHECKED BY:- ANURAG	
DATE :- 01.04.2022	REVISION :- R0	
SCALE :- -----	DRG. NO :-	

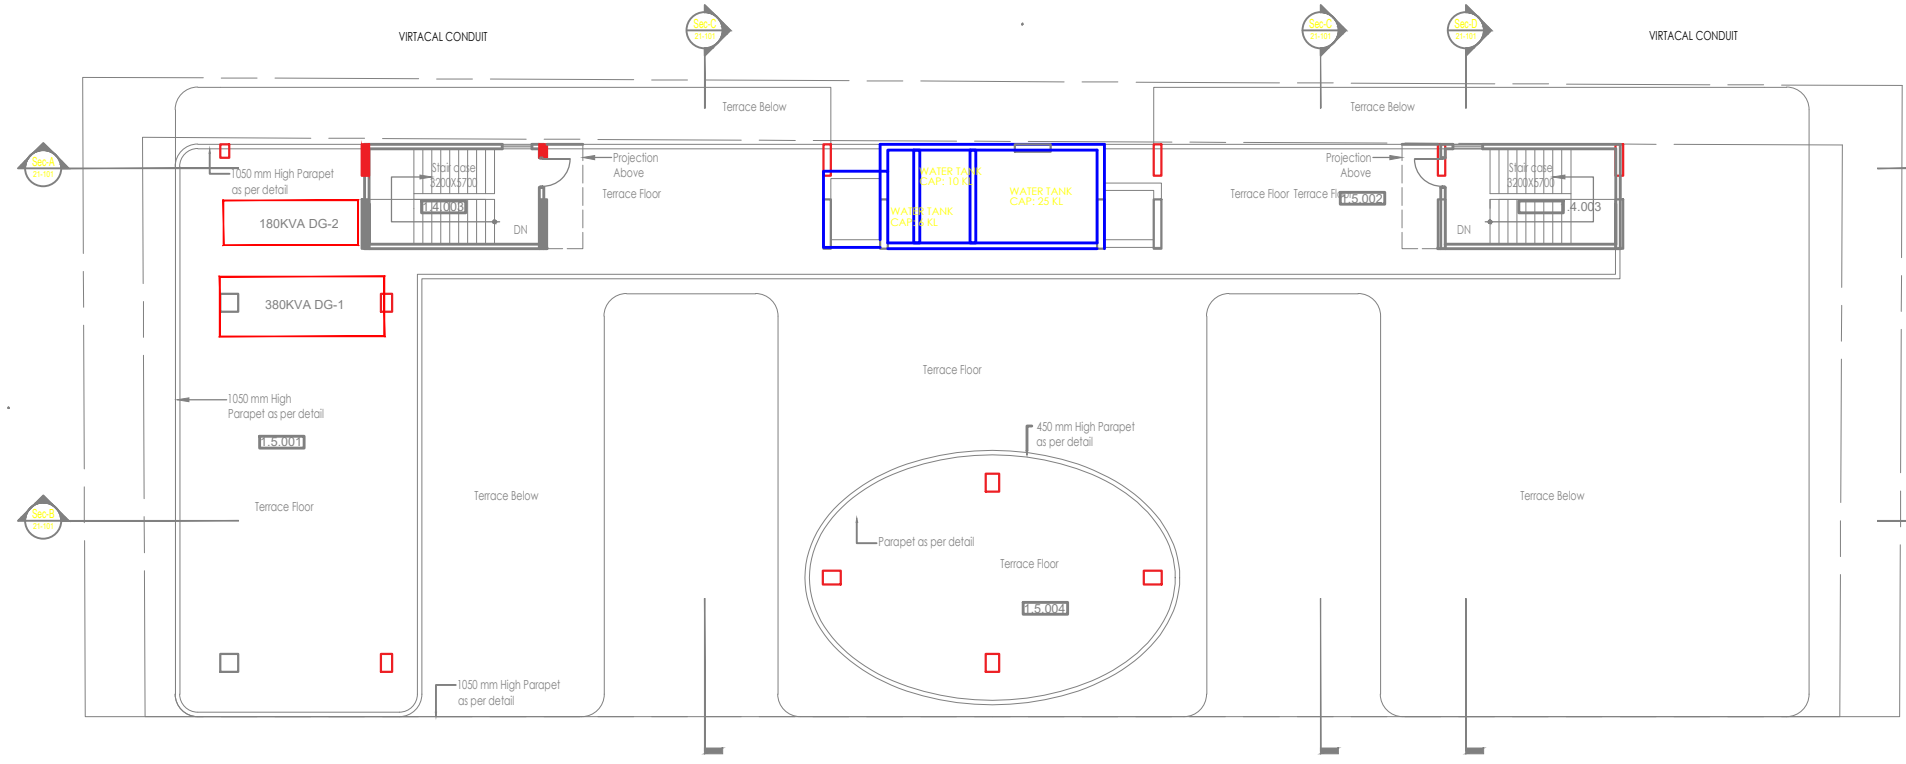

3 TERRACE PLAN (+14950 LVL)
0:00

PLUMBING LEGEND:		
S.No.	SYM	DESCRIPTION
1.	①	100Ø CI SOIL & VENT PIPE
2.	②	100Ø CI WASTE & VENT PIPE
3.	③	DWS DN TAKE PIPE
4.	④	FWS DN TAKE PIPE
5.	⑤	32Ø DWS RISER PIPE
6.	⑥	25Ø FWS RISER PIPE
7.	⑦	110 OD uPVC RAIN WATER PIPE
8.	FD	FLOOR DRAIN (100x50) GI ELBOW
9.	FT	FLOOR TRAP (100x100)
10.	COP	CLEAN OUT PLUG (100Ø)
11.	FCO	FLOOR CLEAN OUT (100Ø)
12.	DWS	DOMESTIC WATER SUPPLY
13.	FWS	FLUSHING WATER SUPPLY
14.	KH	KHURRA (450x450)

NOTE:-
ALL DIMENSION ARE IN MM


Sl. NO.	DATE	DESCRIPTION	DRAWING NO.
---------	------	-------------	-------------

REVISIONS
PROJECT TITLE :-
COMMERCIAL
19911_2222_SIDHARTH
VIHAR – GHAZIABAD

DRG. TITLE :-
PLUMBING LAYOUT OF
TERRACE FLOOR PLAN

MEP CONSULTANTS:
 212, 2nd Floor, SRBC Tower, Sec-9,
Vasundhara, Ghaziabad-201012
E-mail: info@metaphorconsultants.in
metaphorconsult@gmail.com
Tel: 120-4222878

EPC ARCHITECT :-
 P-2/21 DLF Phase-2
Gurugram-122001
Unit 27, 18-20 Newton St.
Alexandria NSW 2015
Project Office : Gurugram
Phone - 0124-4351477
info@studiorhizome.com
www.studiorhizome.com

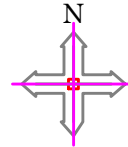DETAILED BY :- VIVEK	CHECKED BY:- ANURAG	
DATE :- 01.04.2022	REVISION :- R0	
SCALE :- -----	DRG. NO :-	