


 


OTHER PLOT

GH-11

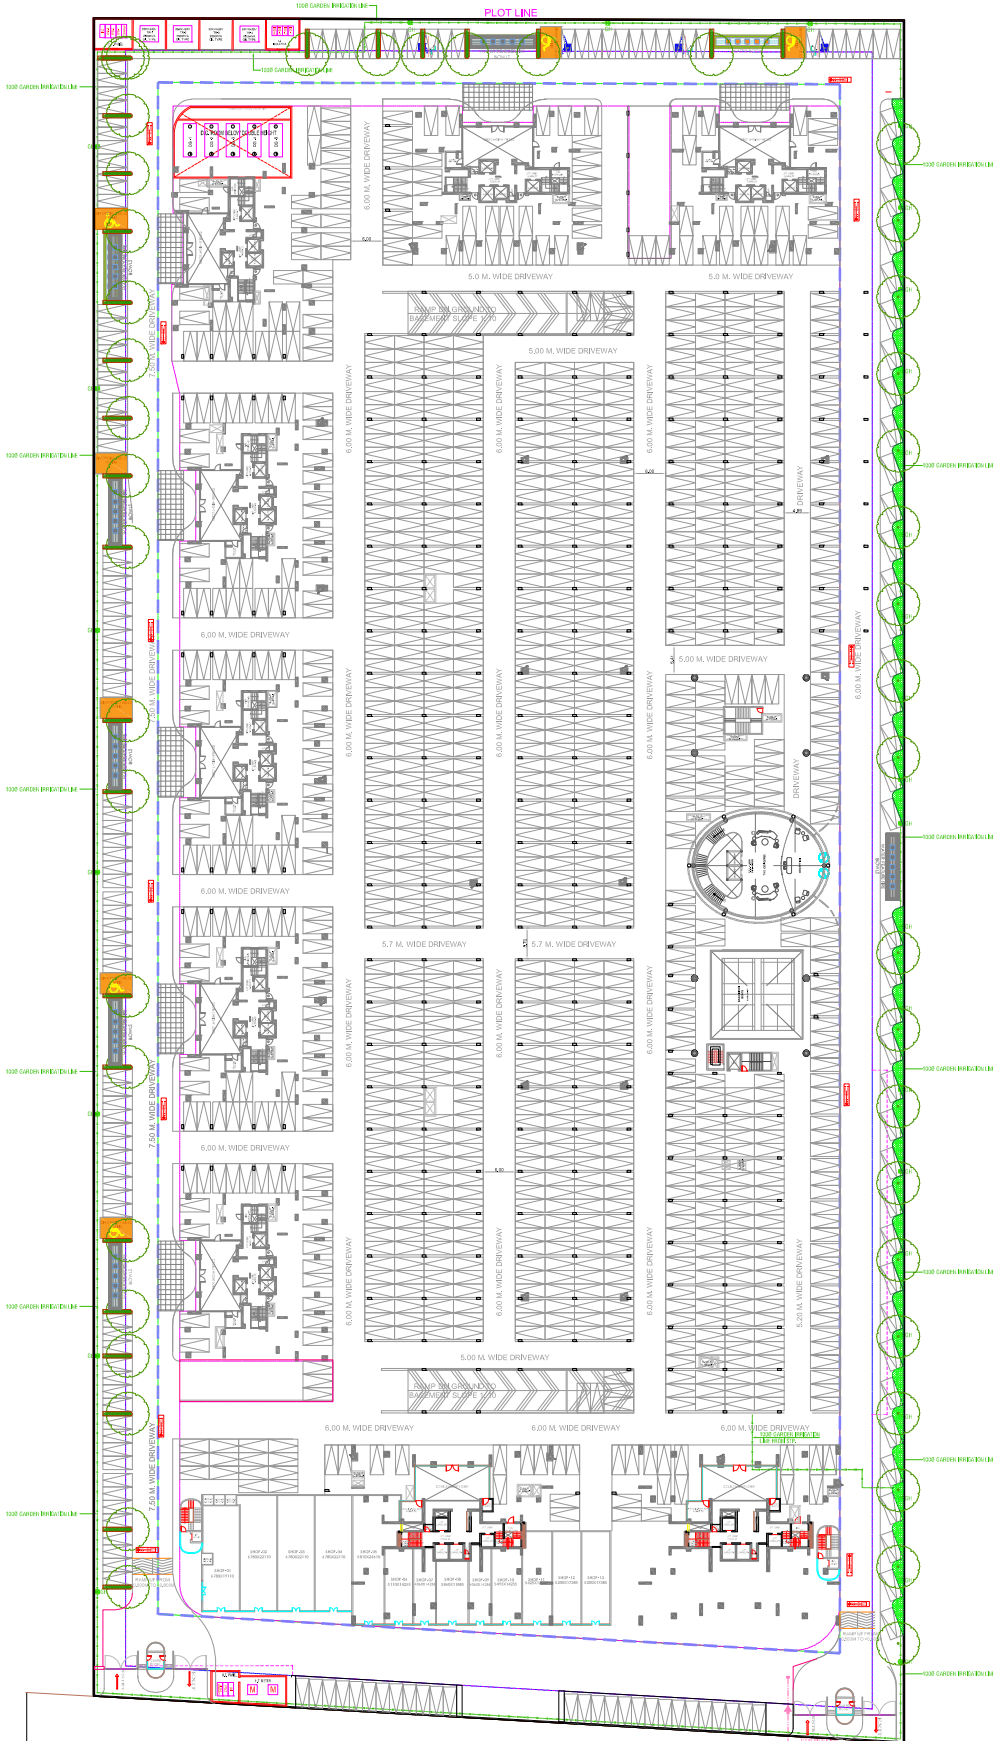


45.0 Mt. WIDE ROAD

CLIENT :- GAURSONS PROMOTERS PRIVATE LIMITED GAUR BIZ PARK PLOT NO.-1, ABHAY KHAND-II, INDIRAPURAM, GHAZIABAD	
PROJECT :- PROPOSED GROUP HOUSING PROJECT GAUR CHRYSALIS AT PLOT NO. GH-12, SECTOR-22 D, YEIDA, GREATER NOIDA, U.P.	
TITLE :- WATER SUPPLY LAYOUT PLAN	
<input checked="" type="checkbox"/> SUBMISSION 	
OWNER'S SIGN	For Gaursons Promoters Pvt. Ltd.  Authorised Signatory
ARCHITECT SIGN	 HARGOVIND SHARMA ARCHITECT 10/10, PLOT NO. 12, SECTOR 22 D, YEIDA, GREATER NOIDA, U.P.
ST/TL FLOOR PLAN	DRG. NO. :-

OTHER PLOT

GH-11

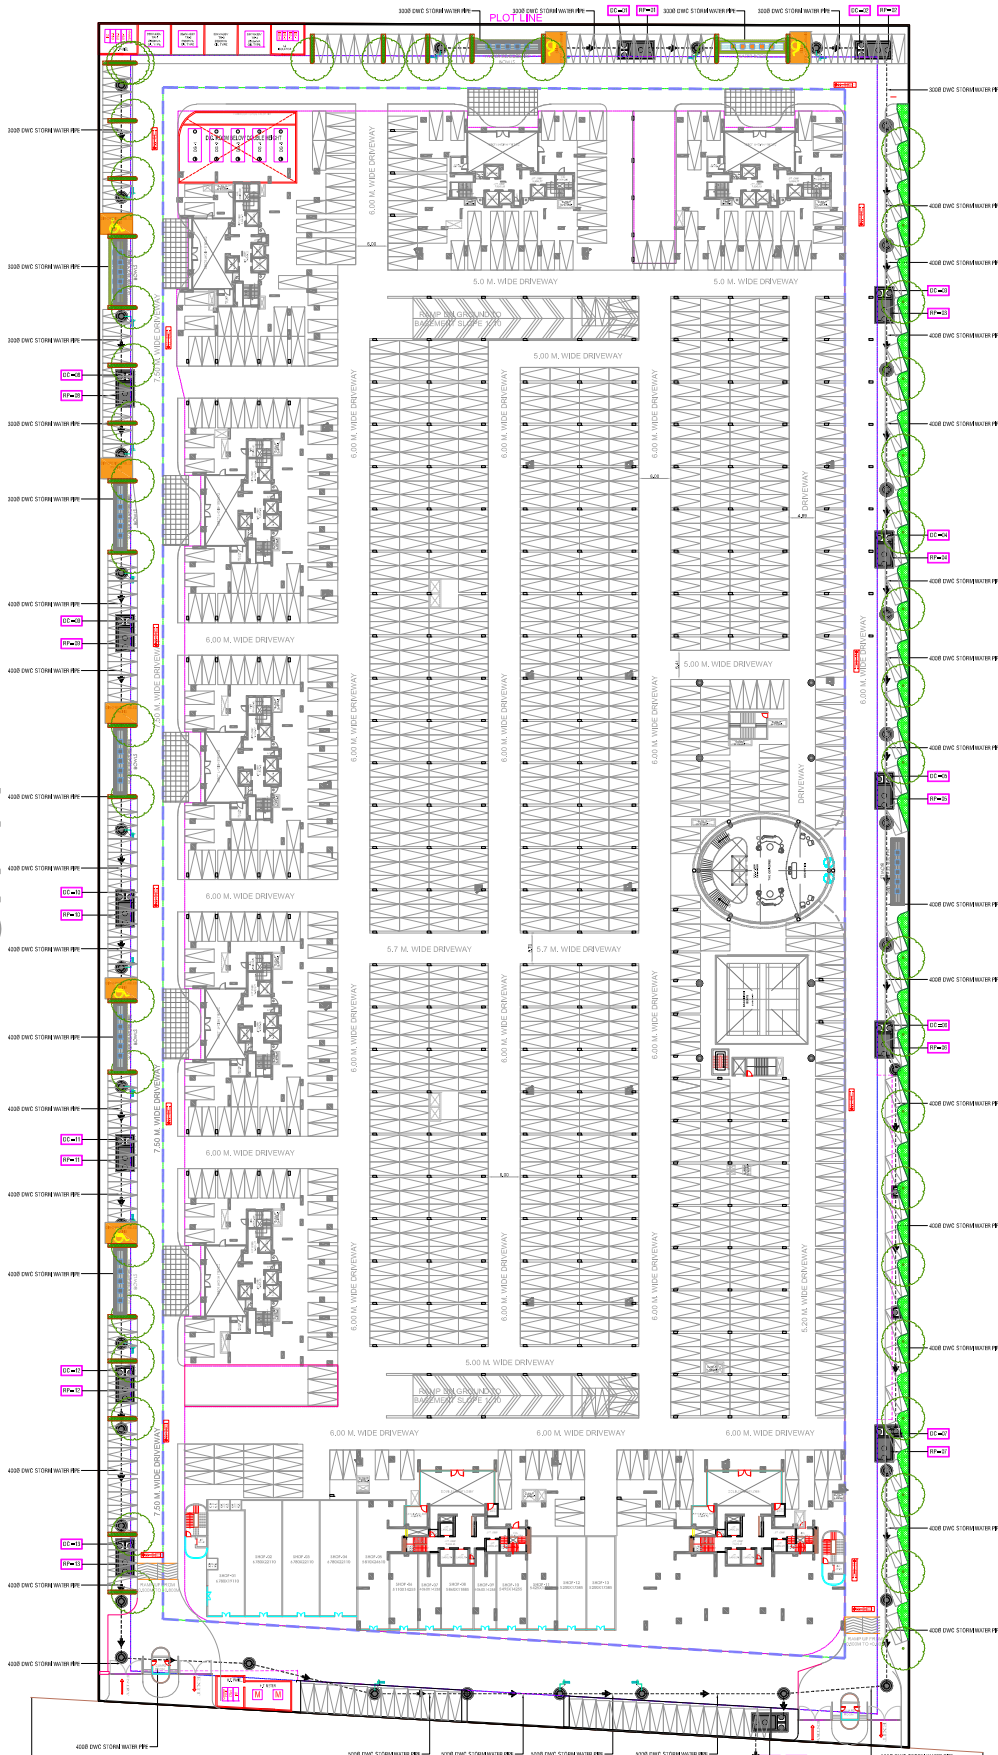

PLUMBING & PPE SERVICES LEGEND:

	SEWER MANHOLE WITH 600 DIA. RPP MANHOLE COVER
	STORM WATER MANHOLE WITH 600 DIA. RPP MANHOLE COVER
	SEWER MANHOLE WITH 1500 DIA. RPP MANHOLE COVER
	STORM WATER MANHOLE WITH 1500 DIA. RPP MANHOLE COVER
	CATCH TRAP WITH 1500 DIA. RPP MANHOLE COVER
	EXTERNAL SEWER LINE
	EXTERNAL STORM WATER LINE
	1500 DIA. RPP MANHOLE WITH 1500 DIA. RPP MANHOLE COVER
	600 DIA. RPP MANHOLE WITH 600 DIA. RPP MANHOLE COVER
	EXTERNAL FIRE HYDRANT LINE
	EXTERNAL FIRE HYDRANT WITH 1500 DIA. RPP MANHOLE COVER

45.0 Mt. WIDE ROAD

CLIENT :- GAURSON'S PROMOTERS PRIVATE LIMITED
GAUR BIZ PARK PLOT NO.-1, ABHAY KHAND-II,
INDRAPURAM, GHAZIABAD

PROJECT :- PROPOSED GROUP HOUSING PROJECT
GAUR CHRYSALIS AT PLOT NO. GH-12,
SECTOR-22 D, YEIDA, GREATER NOIDA, U.P.

TITLE :- **DRAINAGE LAYOUT PLAN**

SUBMISSION

OWNER'S SIGN

ARCHITECT SIGN

STILT FLOOR PLAN DRG. NO. :-