
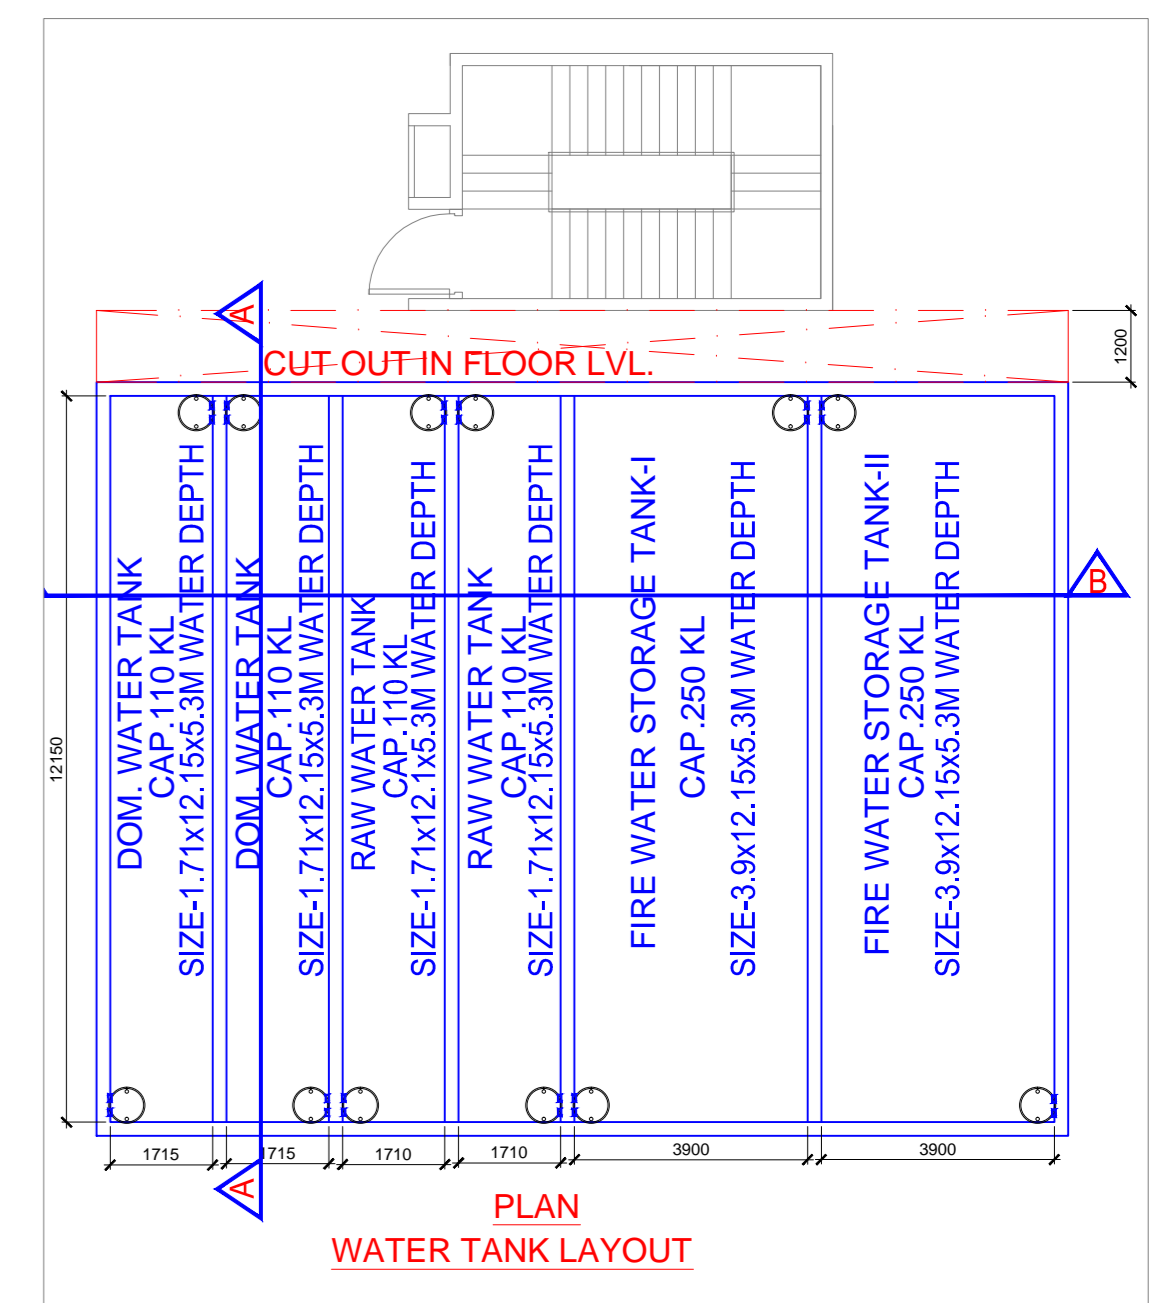
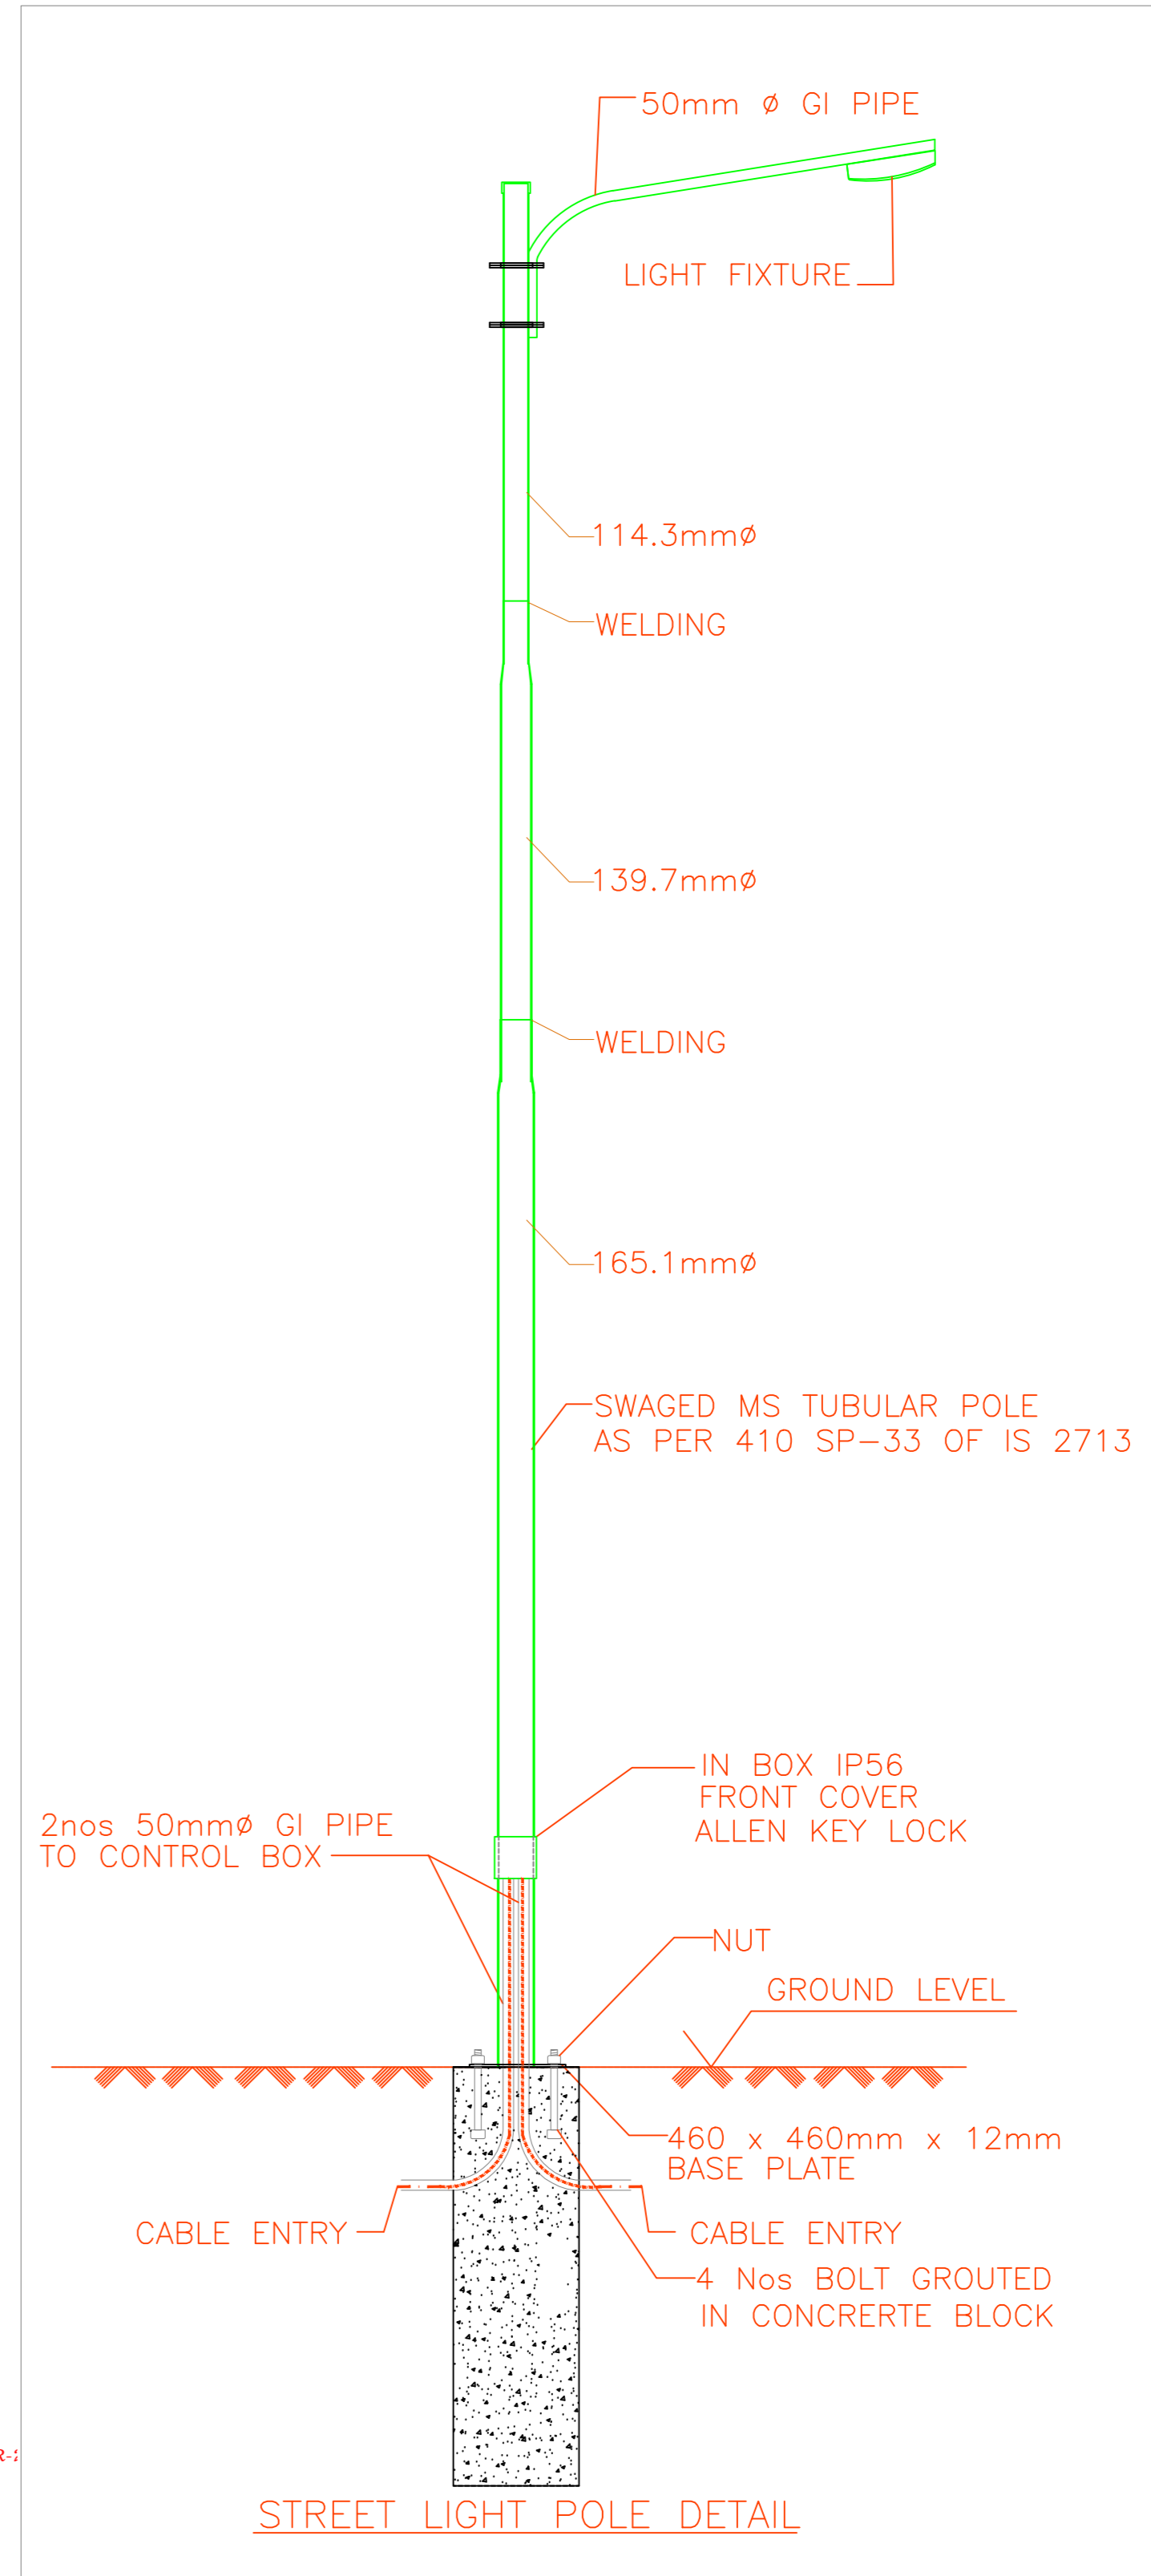


45.0 M. WIDE PEDESTRIAN ENTRY

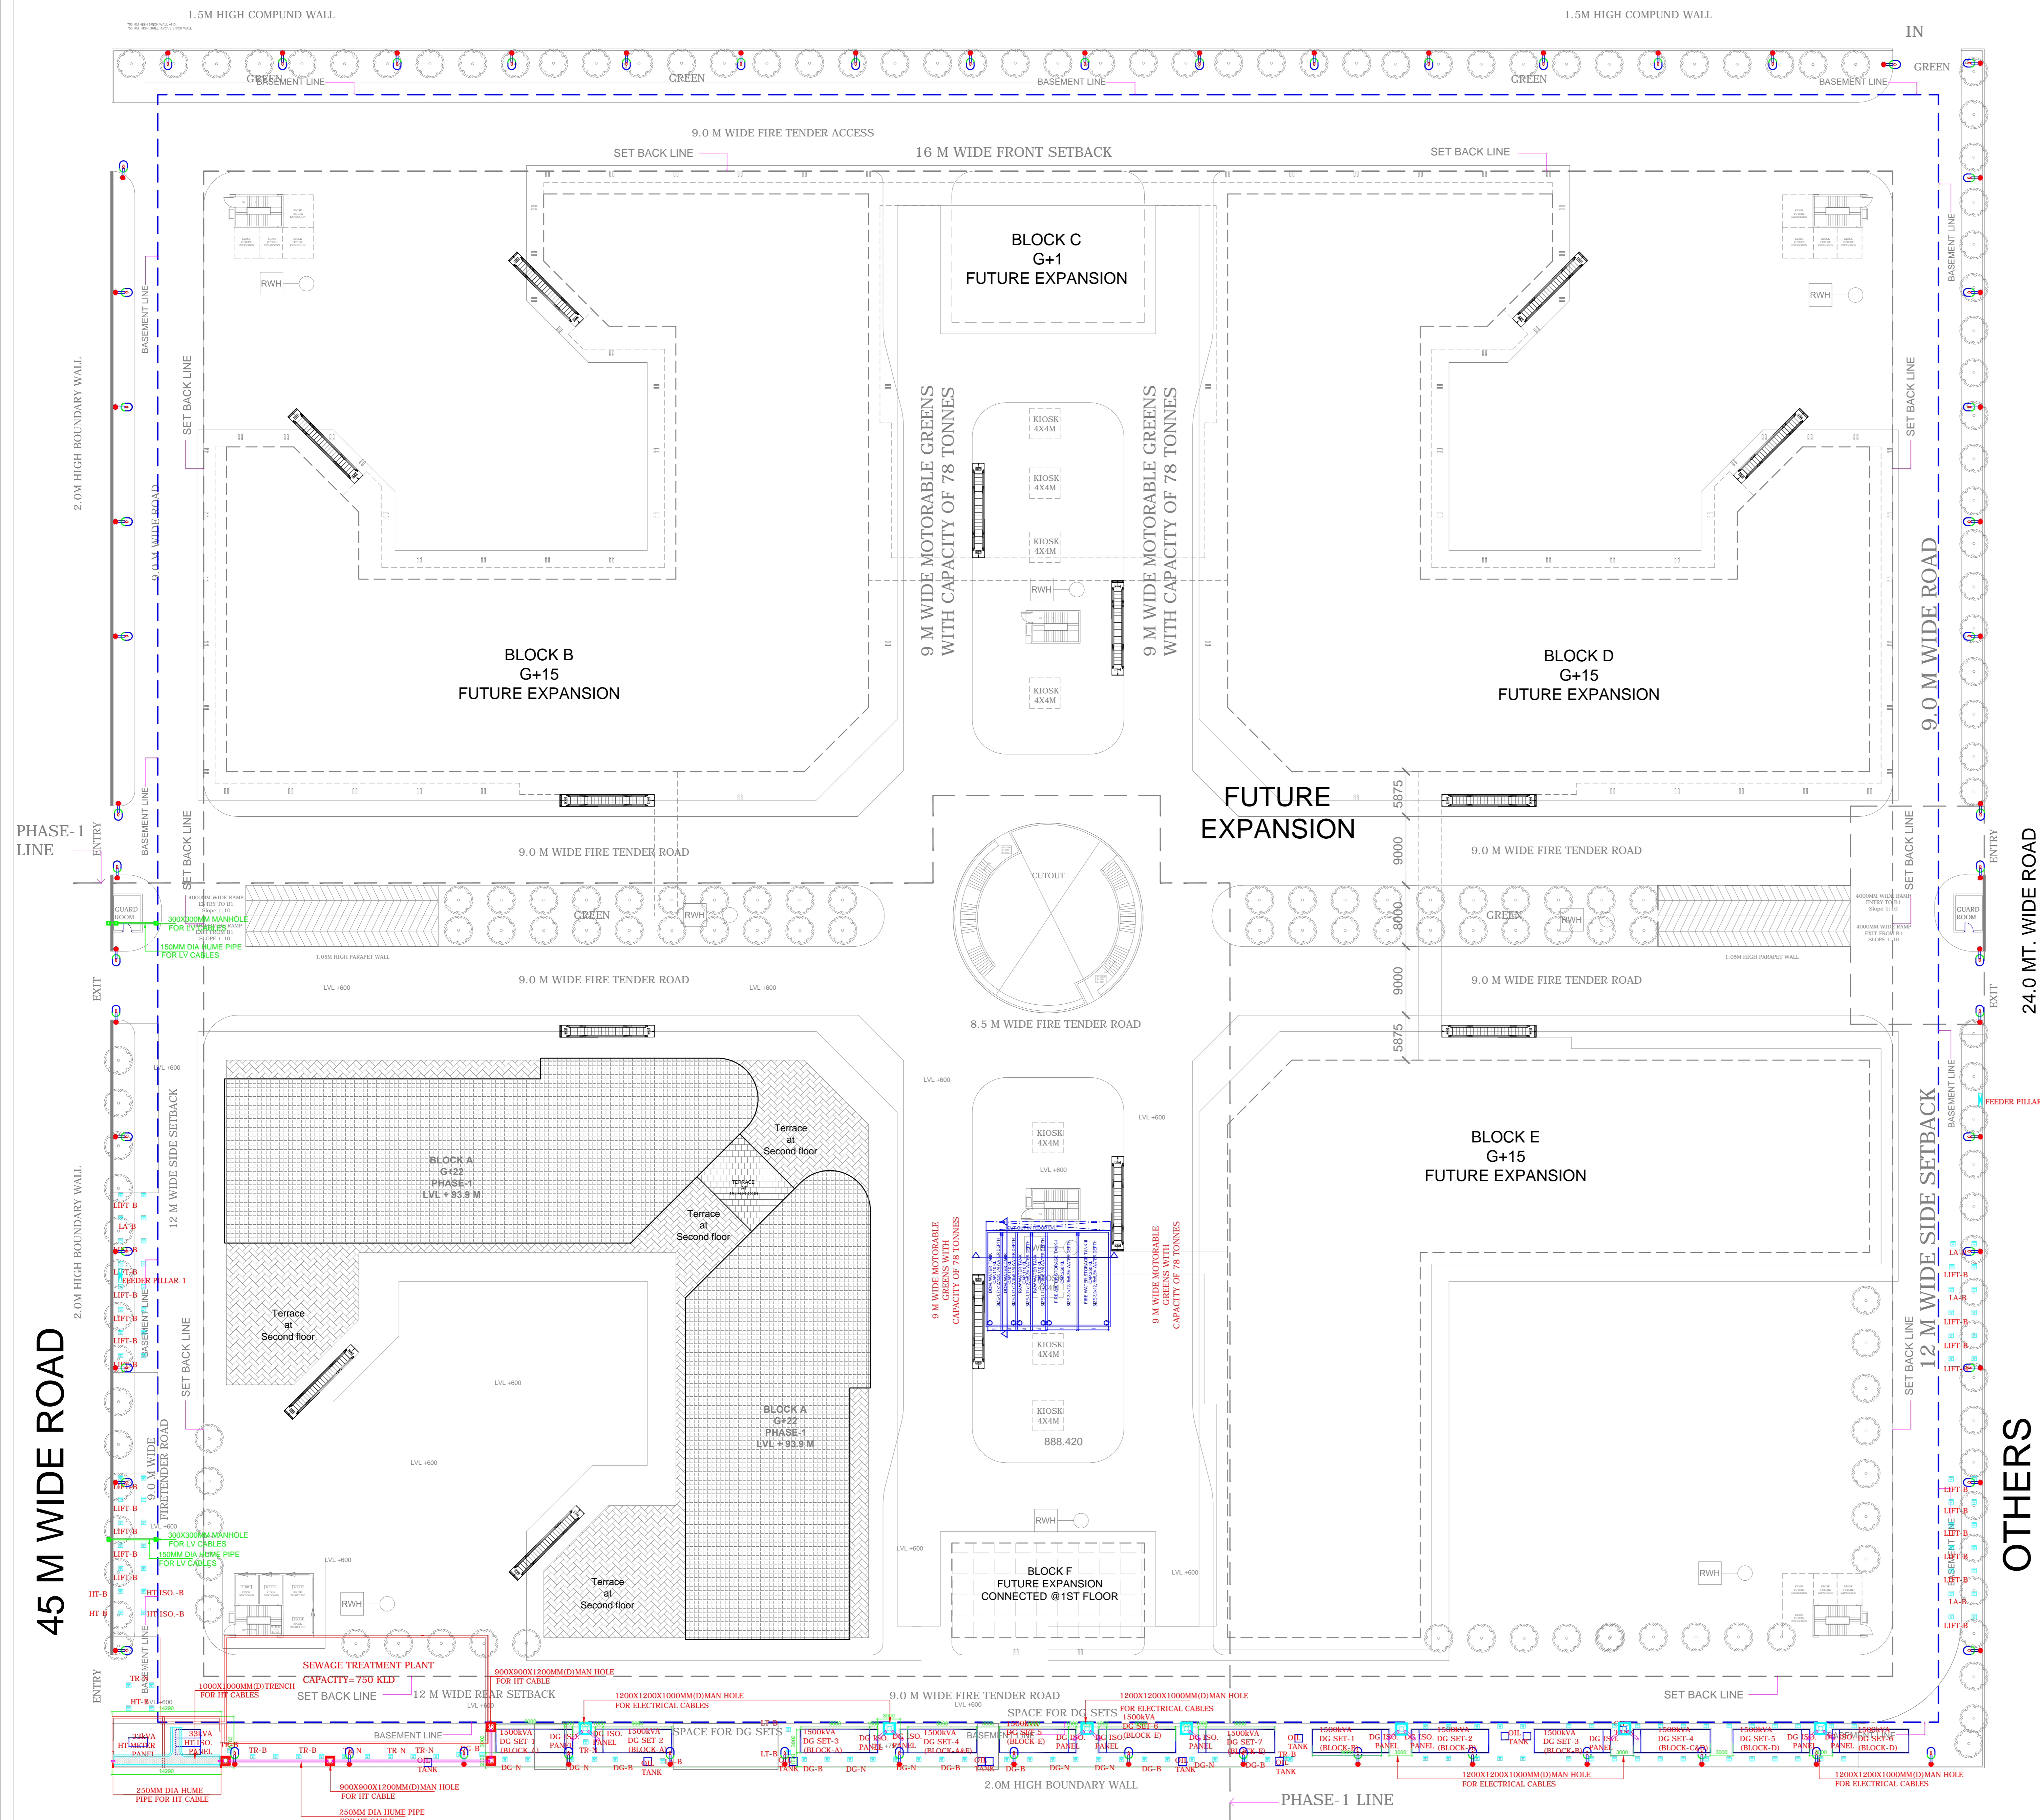

SUBMISSION DRAWING

NO	DATE	REVISION DISCRPTION

IT/ITES BUILDING
PLOT NO. 1A, Sector 140A,
Noida, Uttar Pradesh 201305

CLIENT
FAIRFOX ITINFRA PRIVATE LIMITED
REGD ADDRESS- PLOT NO. DV-GH-98C, SEC. TECHZONE IV,
GREATER NOIDA WEST, UTTAR PRADESH

STRUCTURE CONSULTANT
NNC DESIGN INTERNATIONAL
CONSULTING STRUCTURAL ENGINEERS
G-70, 2nd FLOOR, JASWANT PLAZA, NEAR KALINDI KUNJ MAIN SARITA
VIHAR ROAD, OKHLA, NEW DELHI-110025 PHONE NO.: +91-11-26940734/5/6/7/8
FAX: 26940738 E-Mail: nnc_consultants@yahoo.com
Web: www.nncdesigninternational.com

MEP CONSULTANT
MULTIPLE SERVICES CONSULTANT
253/B, Rajpur Khurd Extension,
Chattarpur, New Delhi-110068
Ph. no. -8920225677/8920228058
mscipc@gmail.com

LANDSCAPE CONSULTANT
INTEGRAL DESIGNS
LANDSCAPE ARCHITECTURE & URBAN DESIGN
E-90, JASWANT NETAJI MARKET DELHI -110021
TEL: 24116584, 24113072
email: designintegral@gmail.com

ARCHITECT
DESIGN FORUM
ARCHITECTURE & URBAN DESIGN TOWN PLANNING
K-47, KAILASH COLONY, NEW DELHI -110048
PH. NO:- 011-46556600, FAX:- 011-46556601
www.designforuminternational.com

Date : 25-11-2021
Scale : 1:300
Rev. No. R1

Sheet Title
SITE PLAN ELECTRICAL PLAN

Sheet No.
MSC/DF/NOIDA/IT/SP/FF-01