




KEY PLAN

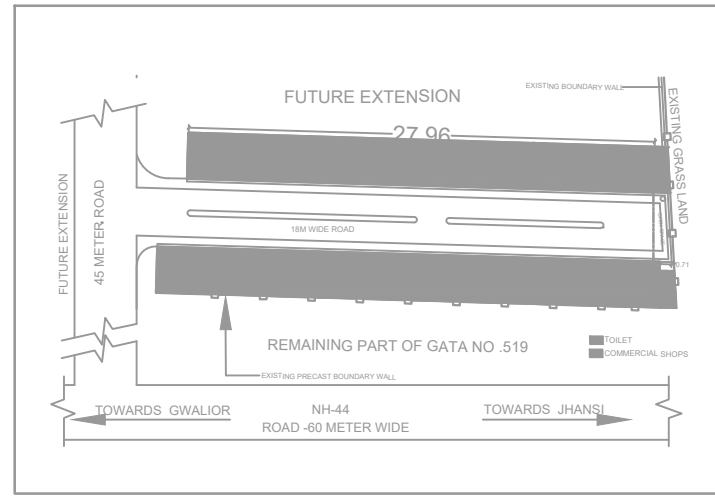

SITE PLAN

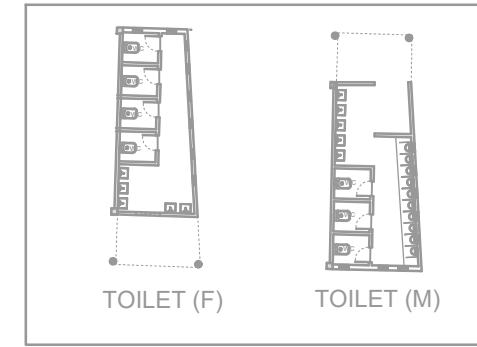

TOILET BLOCK

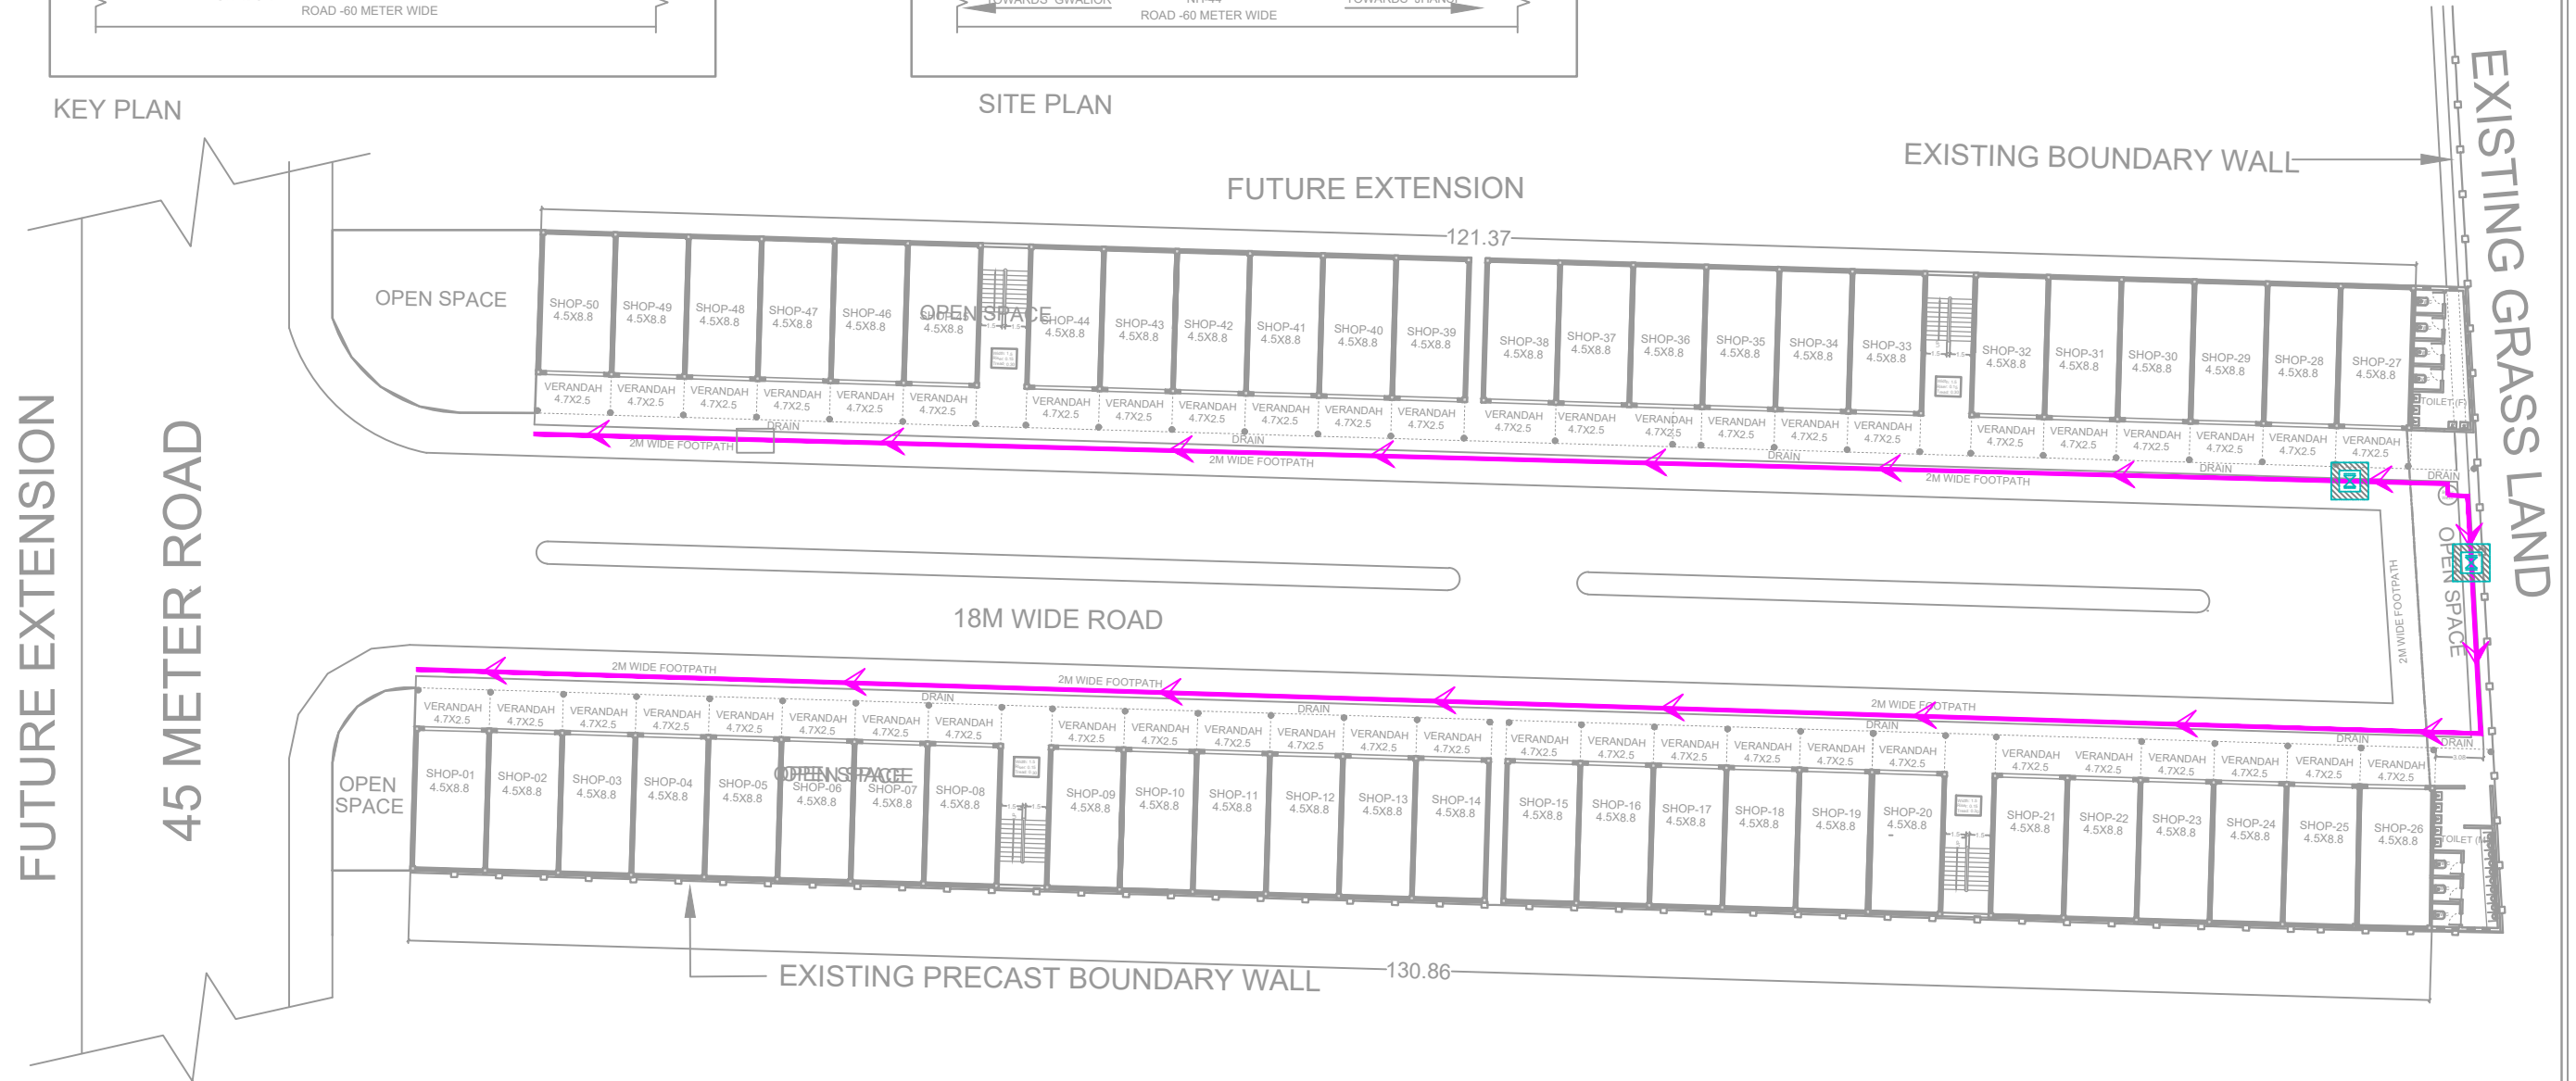

**JHANSI DEVELOPMENT AUTHORITY**  
 Infront of, Commissioner Compound,  
 Circuit House Rd, Gwal Toli, Jhansi,  
 Uttar Pradesh 284003

PROJECT NAME:  
**PROPOSED 50 SHOPS AT  
 TRANSPORT NAGAR PHASE-1,  
 JHANSI**

DRAWING TITLE:  
**WATER SUPPLY LAYOUT PLAN**

DATE: SCALE:  
 N.T.S.



Legend:	
Symbol	Description
	63MM DIA HDPE PIPE FOR SUPPLY WATER
	VALVE CHAMBER

J.E.	A.E.	E.E.
T.P.	SECRETARY	V.C.