

END TOWER
CONDITION


UNIT - 01 (2 BHK)

KASSIA - G1-B

JUNCTION TOWER
CONDITION

UNIT - 02 (2 BHK)

TYPICAL FLOOR PLAN (TYPE-D)

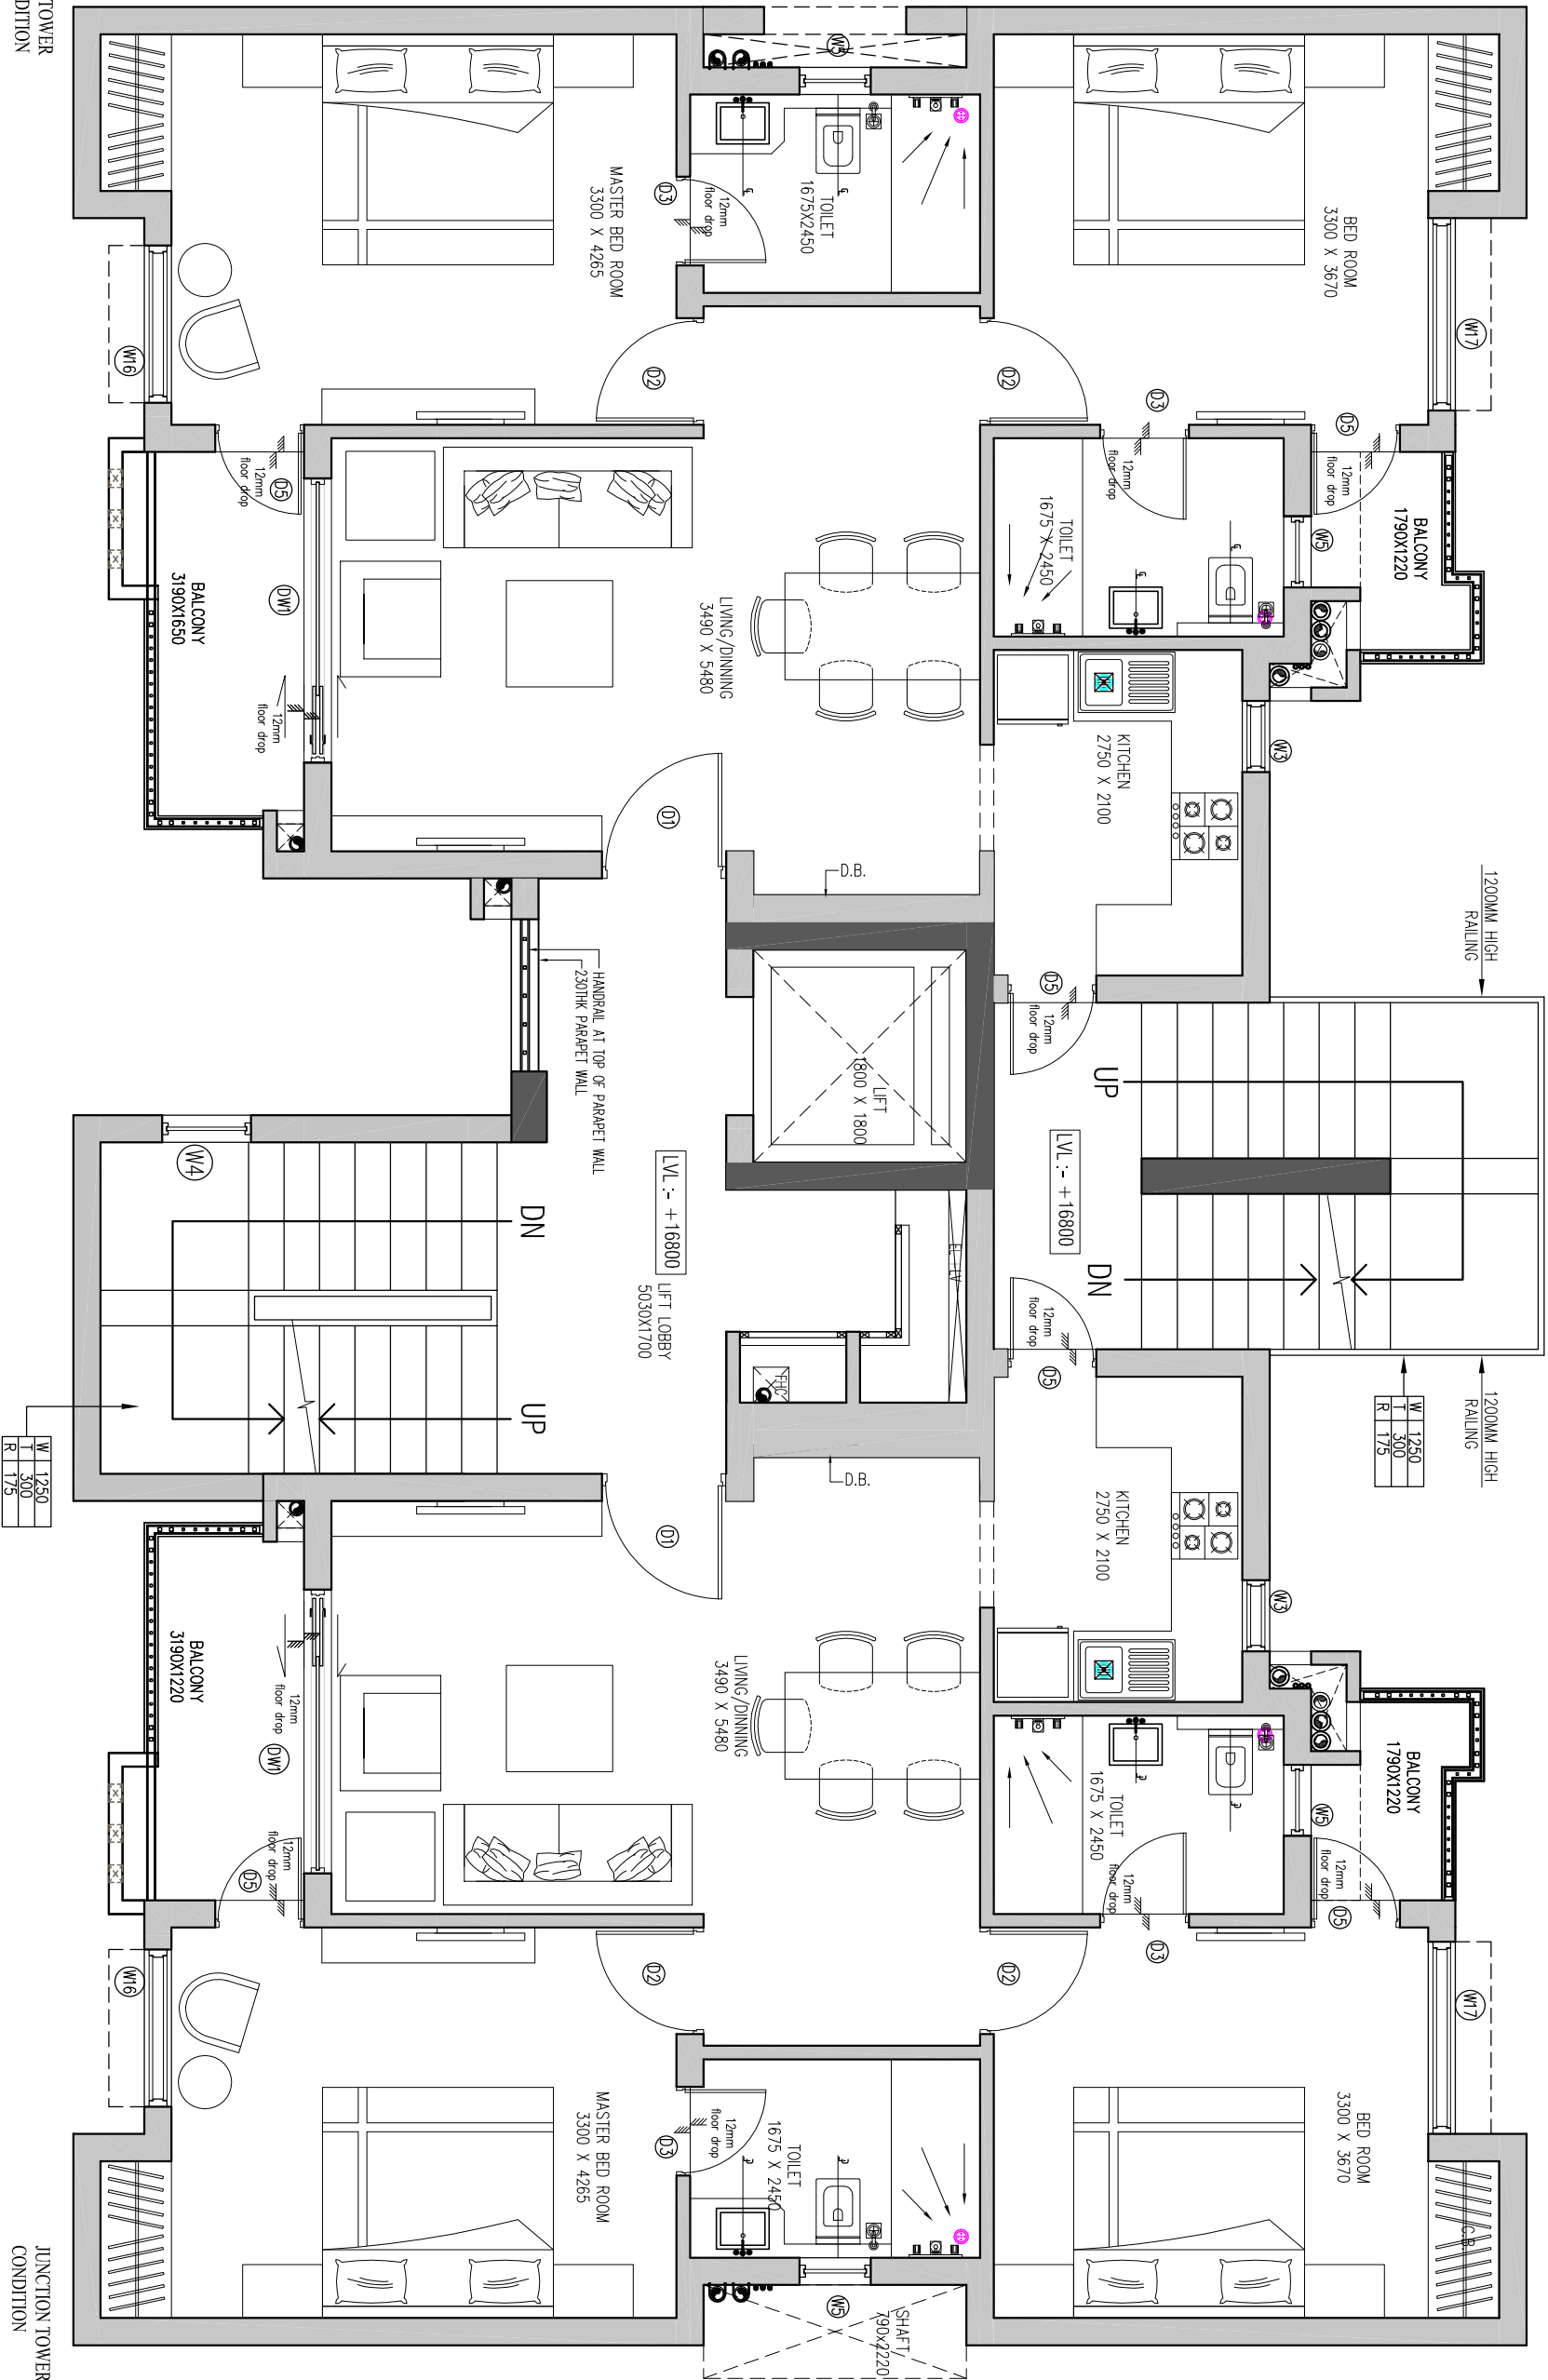

NOTES

SPECIFICATION

- DRAWING AND DIMENSIONS ARE ONLY TO BE READ AND NOT SCALED.
- ALL DIMENSIONS GIVEN ARE IN METERS. ALL DIMENSIONS ARE GIVEN IN METERS.
- THE DRAWING SHALL BE READ IN CONJUNCTION WITH RELEVANT ARCHITECTURAL SPECIFICATIONS AND SERVICES DRAWINGS.
- ALL DIMENSIONS ARE TO BE TAKEN AS SHOWN AND NOT IN EXCESS OF THE DIMENSIONS SHOWN.
- ALL DIMENSIONS ARE TO BE TAKEN AS SHOWN AND NOT IN EXCESS OF THE DIMENSIONS SHOWN.

CONSULTANTS	NAME	PHONE NO.
PROJECT MANAGER	-----	-----
STRUCTURE	MNC Design International	011-26820107
PLUMBING	V S Kalinga & Assoc Pvt Ltd	011-26821075
ELECTRICAL	V S Kalinga & Assoc Pvt Ltd	011-26821075
MECHANICAL	V S Kalinga & Assoc Pvt Ltd	011-26821075
LANDSCAPE	Shakti D P	011-41944442

DATE	07/06/2012	REV	NO	NORTH
SCALE	1:50	REV	NO	
DESIGNED BY	-----	REV	NO	
CHECKED BY	-----	REV	NO	
QUANTITY	-----	REV	NO	
ARCHITECTS	-----	REV	NO	

PROJECT :-	JAI PRAKASH ASSOCIATES LIMITED
GROUP HOUSING KASSIA - AT JAYPEE GREENS SPORTS CITY SDZ SECTOR-25 GAUTAM BUDDH NAGAR (UP)	
SHEET TITLE	TYPICAL FLOOR PLAN-2ND TO 5TH (TYPE-D)
DRG. NO.	JPK1/GFC/IDAR/103/R1
DATE	07/06/2012
SCALE	1:50
DESIGNED BY	-----
CHECKED BY	-----
QUANTITY	-----
ARCHITECTS	-----

NOTES

SPECIFICATION

- DRAWING AND DIMENSIONS ARE ONLY TO BE READ AND NOT SCALED.
- QUESTIONS OR COMMENTS SHOULD BE SUBMITTED TO THE ARCHITECT IN WRITING.
- THE DRAWING SHALL BE USED IN CONJUNCTION WITH RELEVANT ARCHITECTURAL, STRUCTURAL, AND SERVICES DRAWINGS.
- ALL DIMENSIONS GIVEN IN DRAWING ARE WITH REFERENCE TO THE R.F.L. AS SHOWN.
- ANY DISCREPANCY BETWEEN THE ARCHITECTURAL, STRUCTURAL, OR SERVICES DRAWINGS MUST BE BROUGHT TO THE ATTENTION OF THE ARCHITECT BY THE CONTRACTOR OR PROJECT MANAGER BEFORE PROCEEDING WITH THE SAME.

CONSULTANTS

PROJECT MANAGER	NAME	PHONE NO.
STRUCTURE	THIRU SANKAR Jeyarajendran	011-46552012
FOUNDATION	V S Sankar & Assoc P. Ltd.	011-46552015
ELECTRICAL	V S Sankar & Assoc P. Ltd.	011-46552015
HVAC	V S Sankar & Assoc P. Ltd.	011-46552015
LANDSCAPE	Srinidhi P.	011-41044442

DATE - 01/12/2012	REV. NO	NORTH
SCALE - 1/32	REV. NO	
PREPARED BY - R.T.	R-3	
CHECKED BY - G.S.		
QUANTITY - 02		
ARCHITECTS -		
DESIGN FORUM INTERNATIONAL		
ARCHITECTS ENGINEERS & INTERIOR DESIGNERS		
K-47 KALAKASH CONDOY, NEW DELHI - 110070		
PHONE: 91-11-46556600 , 46558593 , 46556601		

CLIENT :- JAPRAKASH ASSOCIATES LIMITED

PROJECT :- GROUP HOUSING KASSIA-1AT JAYPEE GREENS SPORTS CITY, SDZ SECTOR-25, GAUTAM BUDDH NAGAR (U.P.)

SHEET TITLE TYPICAL FLOOR PLAN-2ND TO 5TH (TYPE-E)

DWG. NO. JPK1/06C/TE/AR/103

DATE - 01/12/2012

SCALE - 1/32

PREPARED BY - R.T.

CHECKED BY - G.S.

QUANTITY - 02


ARCHITECTS -

DESIGN FORUM INTERNATIONAL

ARCHITECTS ENGINEERS & INTERIOR DESIGNERS

K-47 KALAKASH CONDOY, NEW DELHI - 110070

PHONE: 91-11-46556600 , 46558593 , 46556601

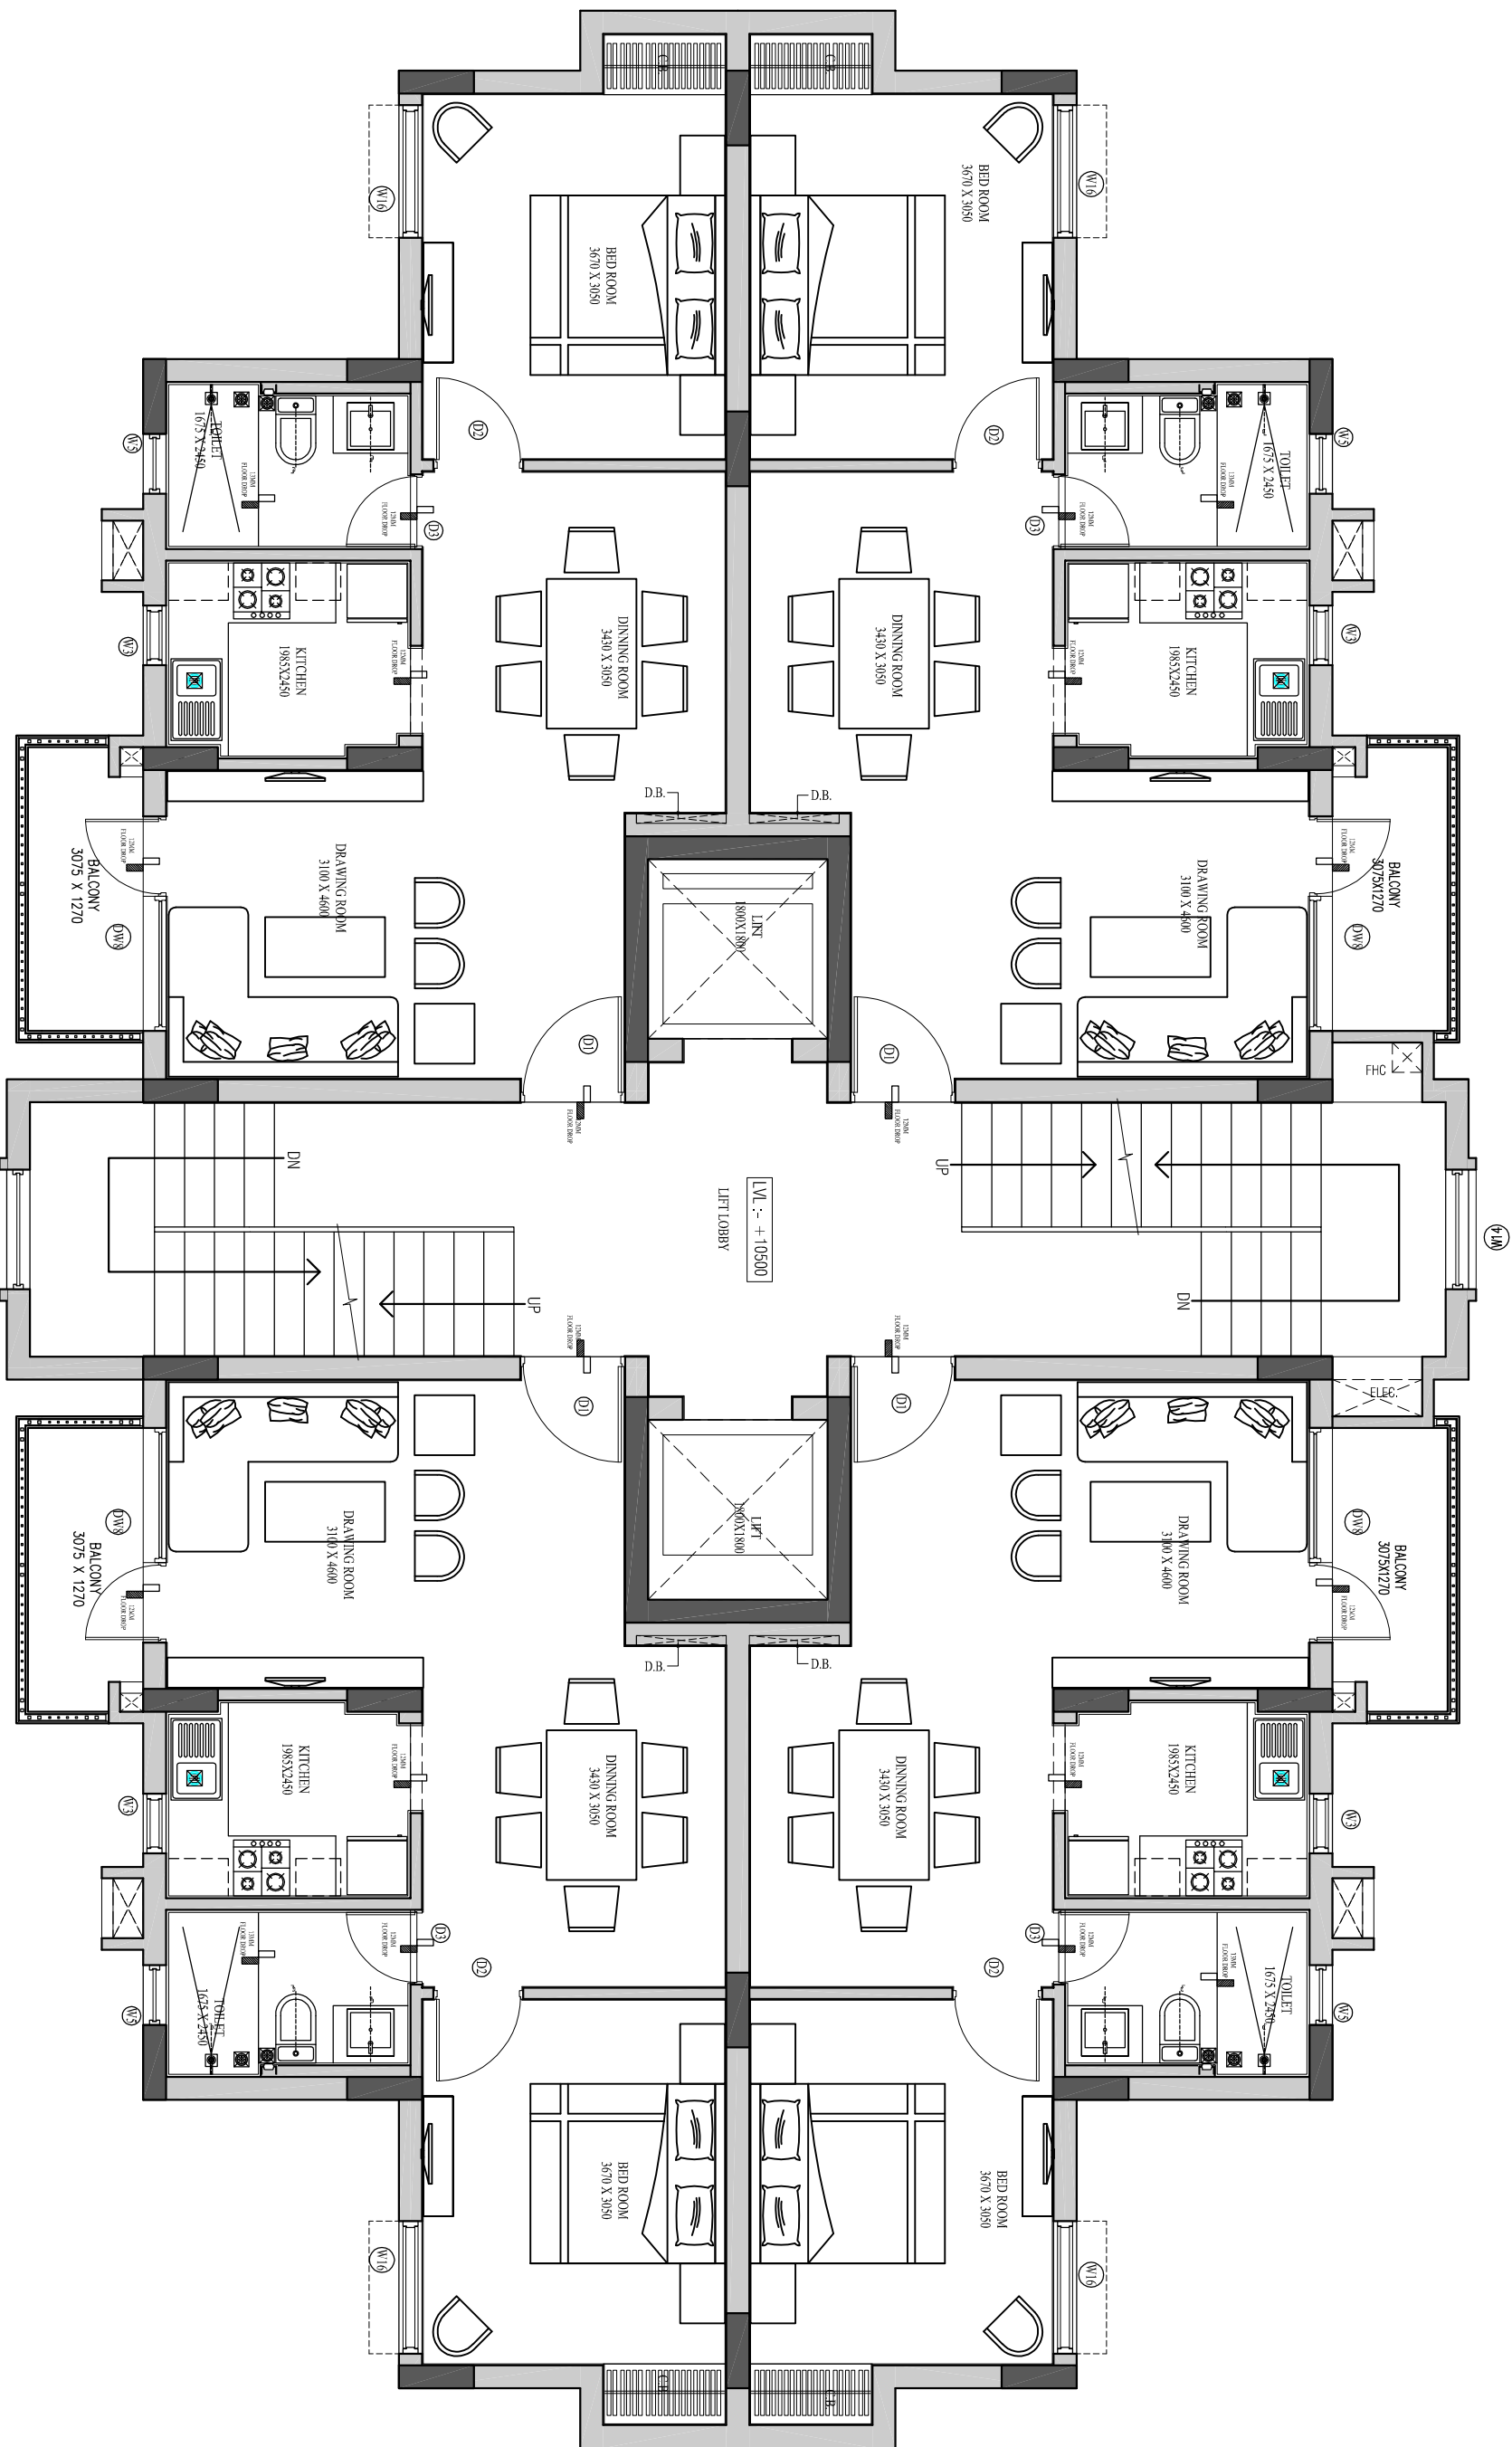

UNIT - 01 (1 BHK)

KASSIA - G1-B

UNIT - 01 (1 BHK)

TYPICAL FLOOR PLAN (TYPE-E)