


LEGEND- SIZE OF MH & DEPTH		
TYPE	SIZE OF MH	DEPTH OF MH
(A)	910MM DIA	FOR DEPTHS ABOVE 0.90M AND UP TO 1.65M
(B)	1220MM DIA	FOR DEPTHS ABOVE 1.651M AND UP TO 2.30M
(C)	1520MM DIA	FOR DEPTHS ABOVE 2.301M AND UP TO 9.0M
(D)	1820MM DIA	FOR DEPTHS ABOVE 9.001M AND UP TO 14.0M

LEGEND PLUMBING	
1100 uPVC WASTE PIPE	---
1100 uPVC SOIL PIPE	---
1600 uPVC SOIL & WASTE PIPE	---
3000 SEWER LINE	---
1500 SEWER BY PASS LINE	---
CLEAN OUT PLUG	---
FLOW	---
SEWER MANHOLE	---
TOP OF SLAB	TOS
BOTTOM OF CUTOUT	BOC

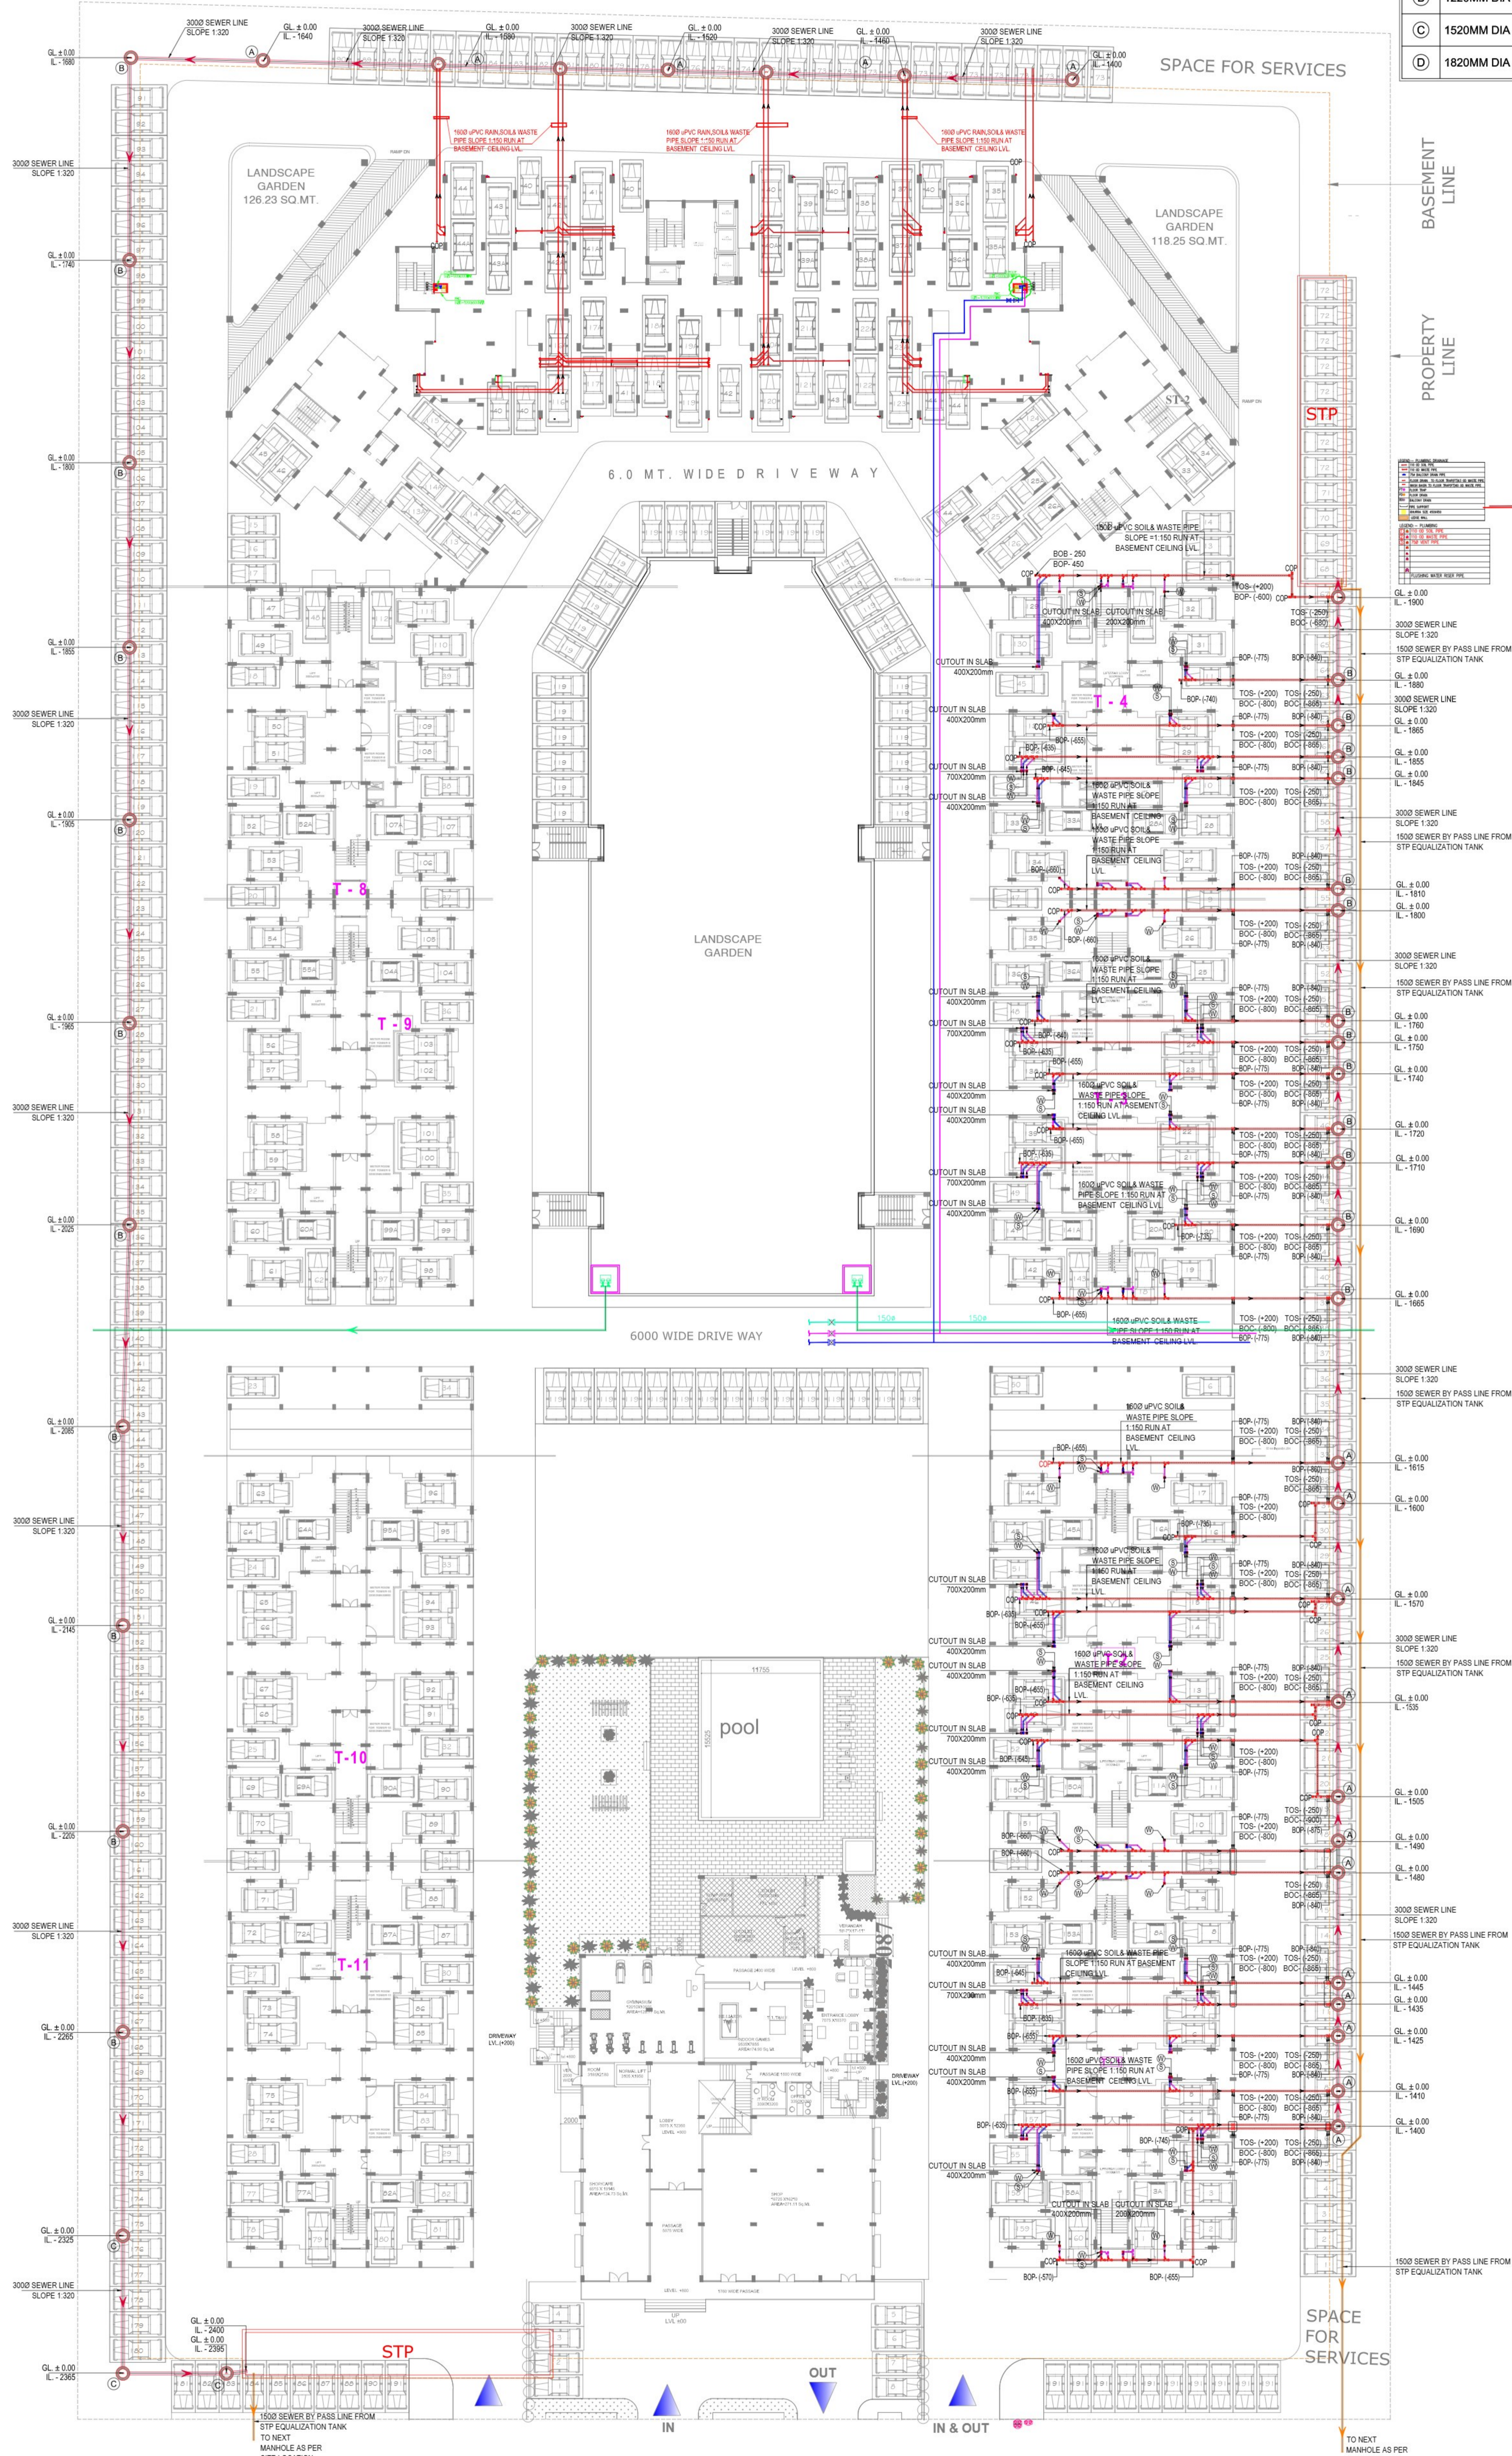

PROJECT:-
 PROPOSED GROUP HOUSING-02, AT INTEGRATED TOWNSHIP (BBD GREEN CITY) FOR VIRAJ CONSTRUCTIONS PVT LTD. AT VILLAGE SEMRA ON KHASRA NUMBERS 180, 181, 182, 183,, LUCKNOW

DRAWING TITLE:-
 APARTMENT NORTH POINT
 SEWERAGE LAYOUT
 STILT FLOOR PLAN

MEP CONSULTANT
 DESIGN CENTRE CONSULTING ENGINEERS
 PVT LTD
 OFFICE NO. 44 TO 47, 4TH FLOOR
 AGRA PLAZA, DABER CHOK
 MINDA, GORAKHPUR, UP
 PHONE: 0120-433241, 433242

NO. OF PRINT	DATE	ISSUED TO	REMARKS

This drawing is a "copyright" contents of this drawing or part thereof may not be used or reproduced without the permission of the architect.

REVISION	DATE	DESCRIPTION	BY	DATE

PROJECT INCH. 2024-11-2024
SCALE N.T.S.
DEALT BY MIKKI
DRAWING NO. DCCE/1325/BBD/PL/STILT#01
CHECKED BY NITIN
APPROVED BY
COMPUTER PATH CI/R/C/BBD

ARCHITECTS :-
 DESIGN CELL
 VIRAJ CONSTRUCTIONS
 PVT LTD.