



LEGEND	
BORE WELL LINE	-----
BORE WELL	⊗

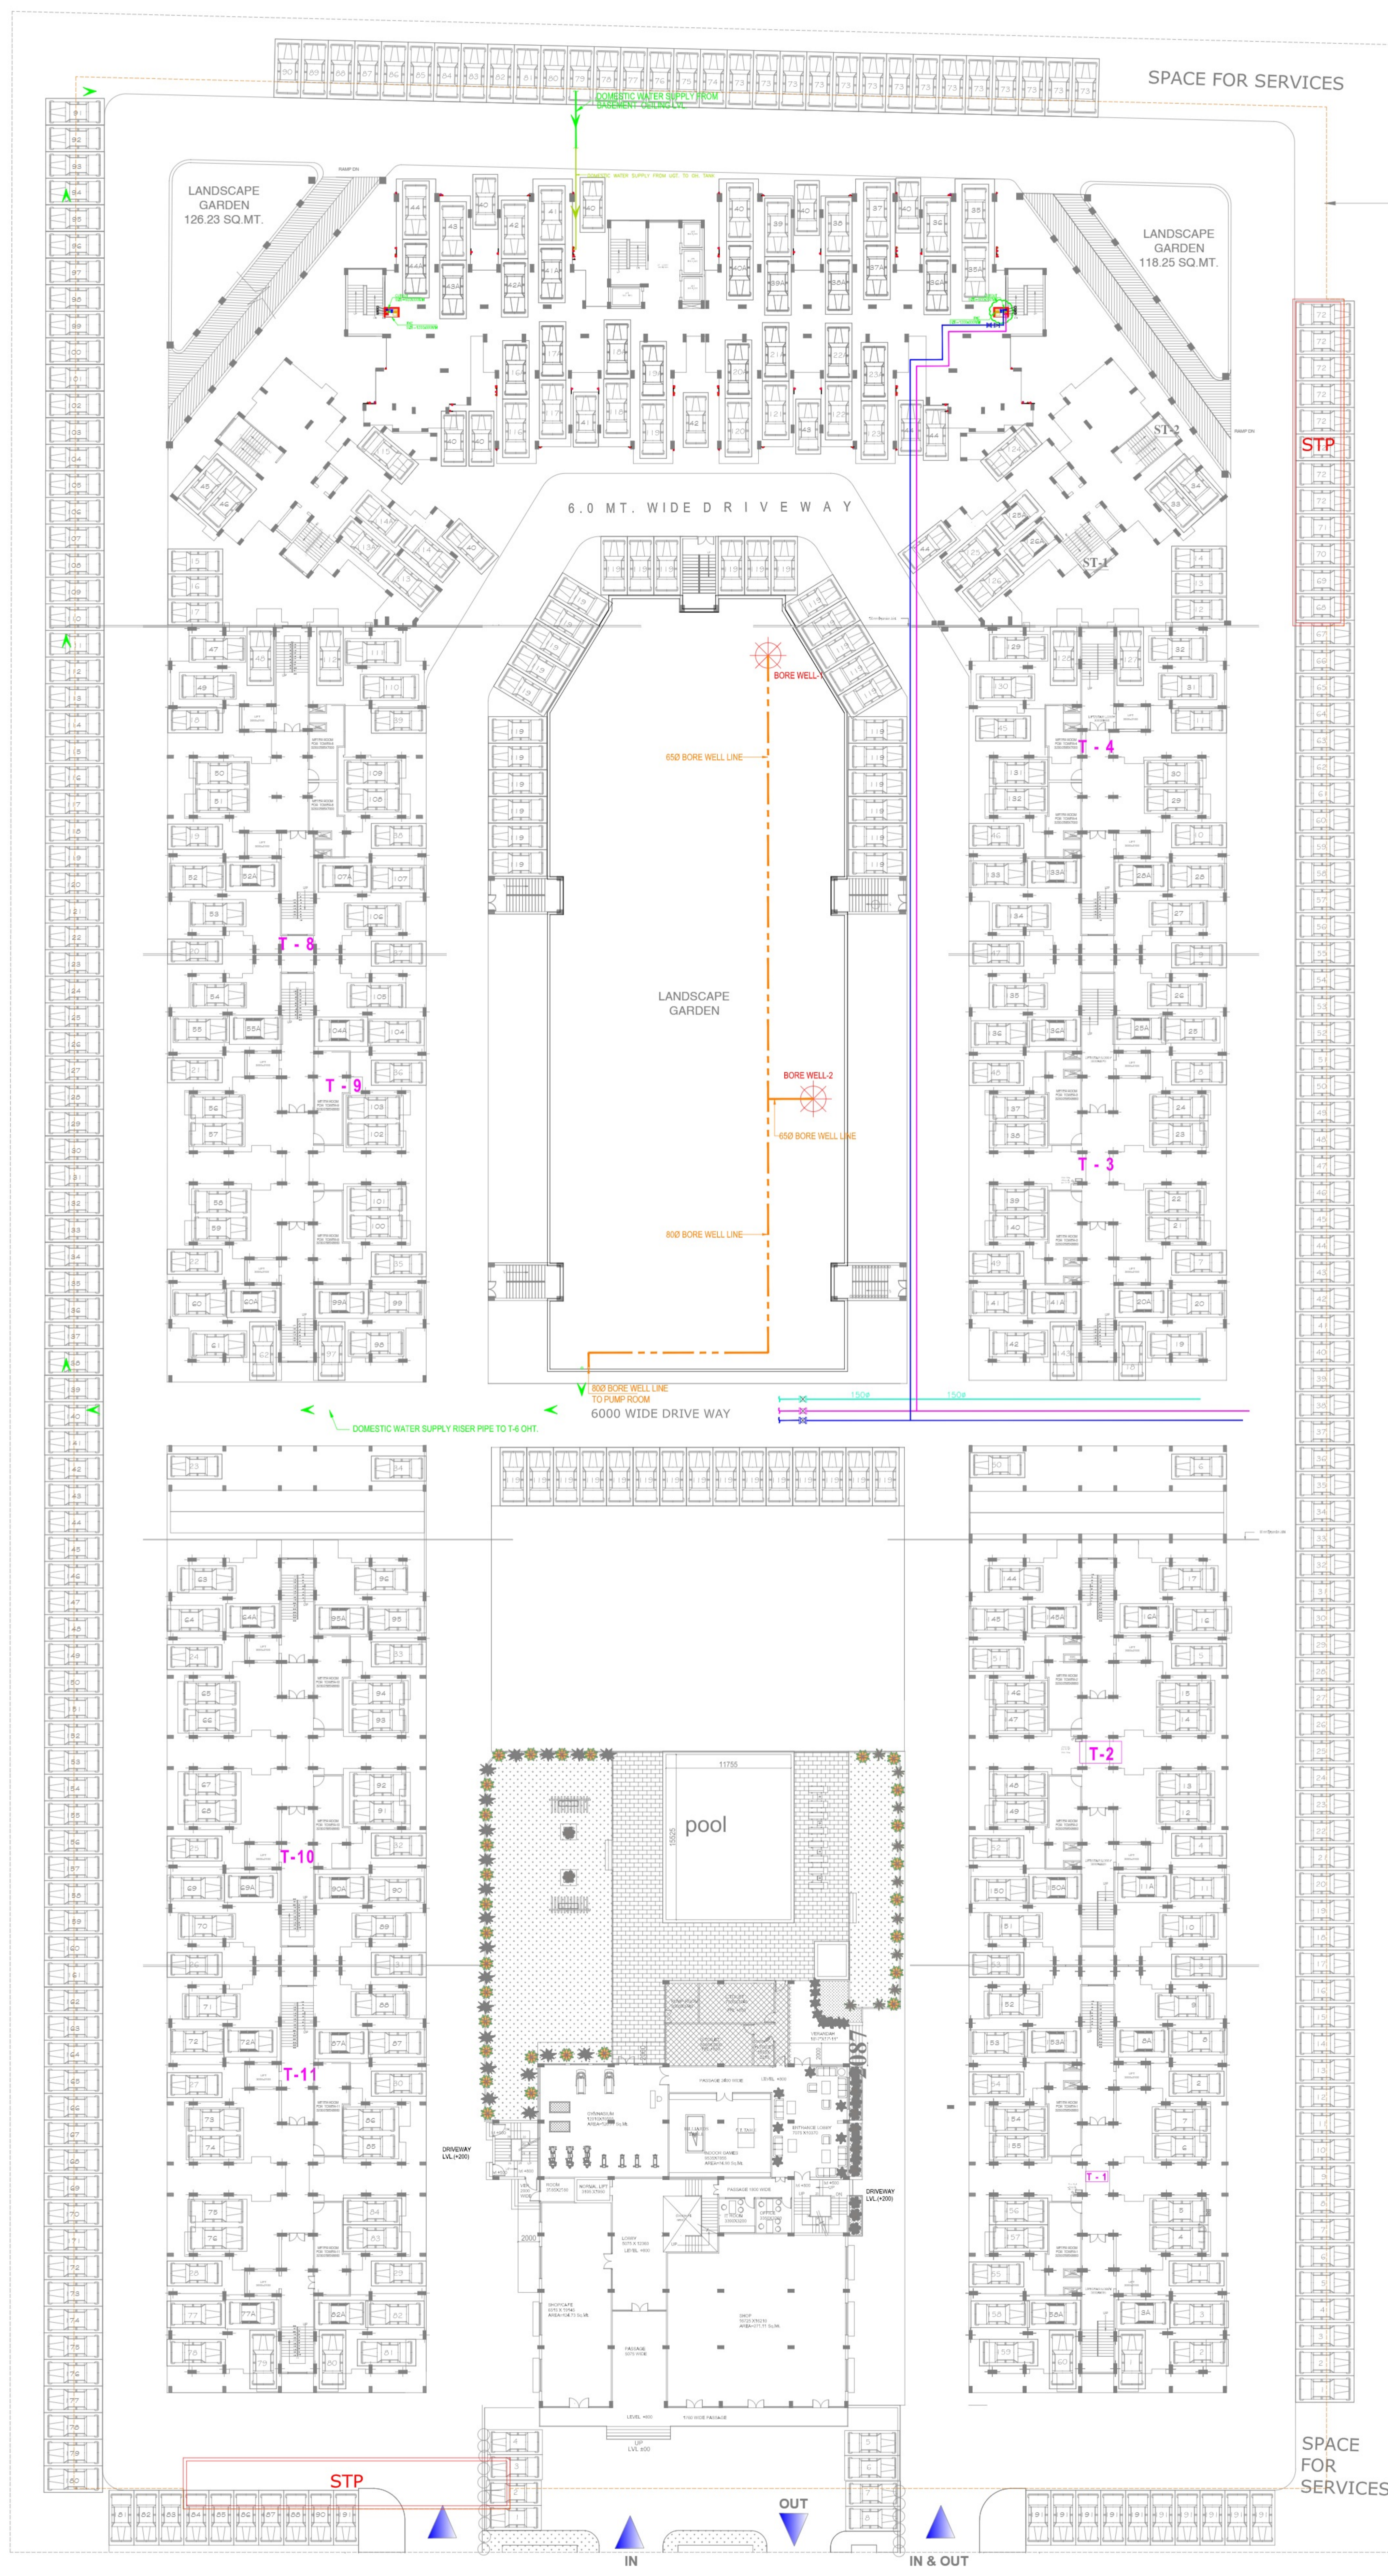

1. 100mm dia. UPVC pipe	---
2. 150mm dia. UPVC pipe	---
3. 200mm dia. UPVC pipe	---
199. 10000mm dia. UPVC pipe	---

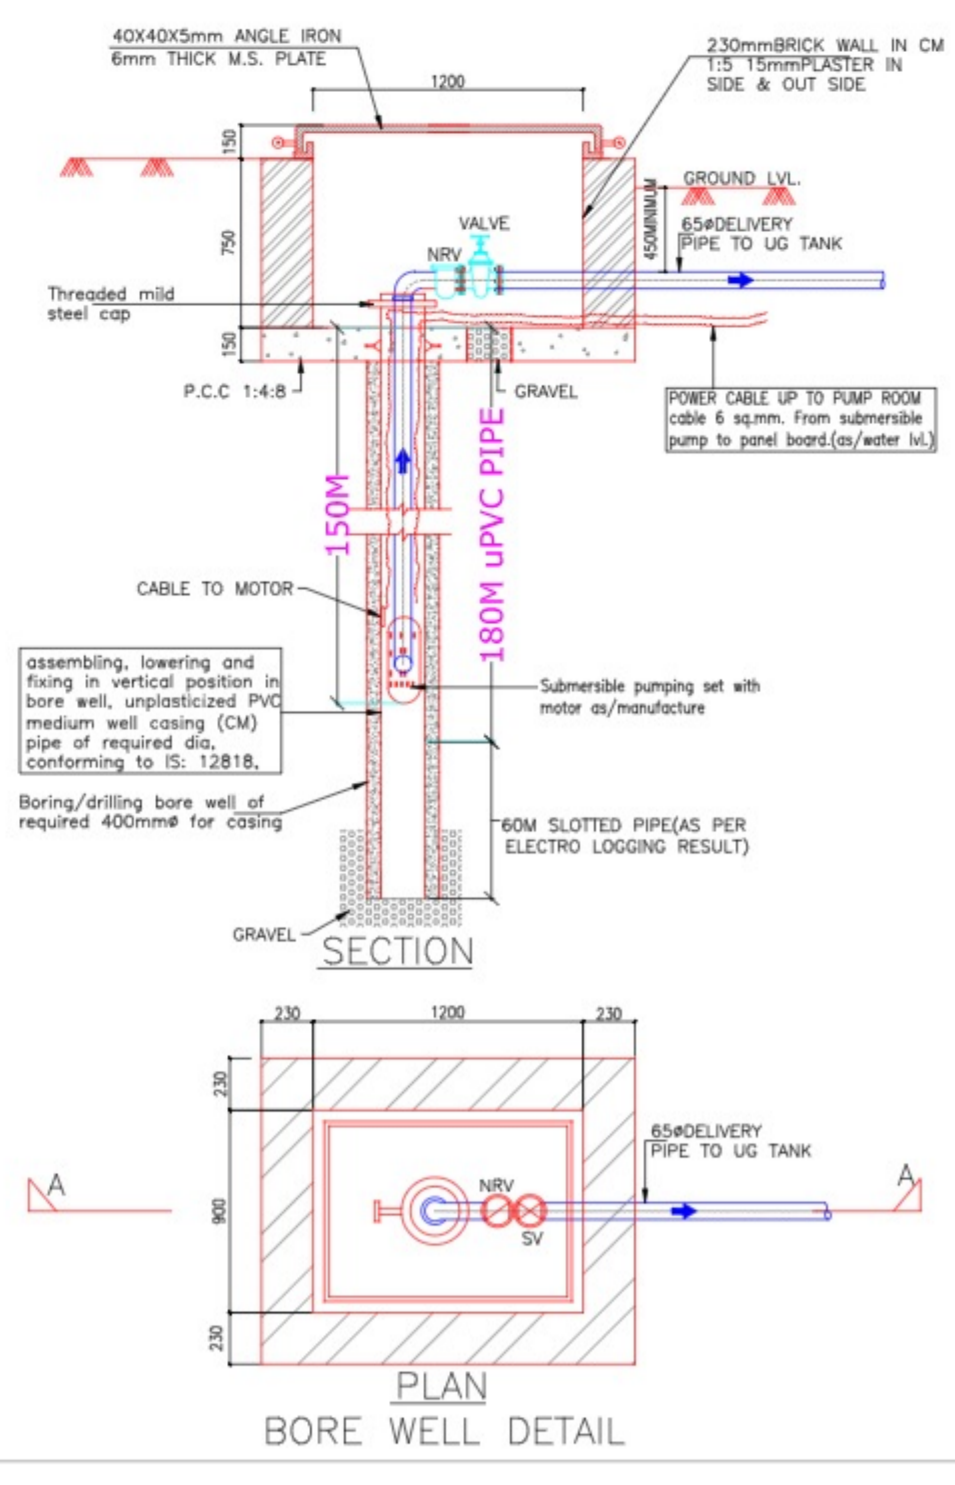

**PROJECT:-**  
 PROPOSED GROUP HOUSING-02, AT INTEGRATED TOWNSHIP ( BBD GREEN CITY) FOR VIRAJ CONSTRUCTIONS PVT LTD. AT VILLAGE SEMRA ON KHASRA NUMBERS 180, 181, 182, 183., LUCKNOW

**DRAWING TITLE:-**  
 APARTMENT  
**NORTH POINT**  
**WATER SUPPLY LAYOUT**  
**STILT FLOOR PLAN**

**MEP CONSULTANT**  
 DESIGN CENTRE CONSULTING ENGINEERS  
 PVT LTD  
 OFFICE NO. 44 TO 47, 4TH FLOOR  
 AGRA PLAZA, GABRIEL CHOKER  
 WINDING, CHANDNAR, UP  
 PHONE: 0120-433241/433242

NO. OF PRINT	DATE	ISSUED TO	REMARKS

This drawing is a "copyright" contents of this drawing or part thereof my not be used or reproduced without the permission of the architect.

REVISION	DATE	DESCRIPTION	BY

**DATE** 2024-11-2024  
**SCALE** N.T.S.  
**PROJECT INCH.**  
**DEALT BY** MIKKI  
**DRAWING NO.** DCCE/1325/BBD/WS/STILT/04  
**CHECKED BY** NITIN  
**APPROVED BY**  
**COMPUTER PATH** CI/RC/BBD

**ARCHITECTS :-**  
**DESIGN CELL**  
**VIRAJ CONSTRUCTIONS**  
**PVT LTD.**