


# ELECTRICAL TRANSFORMER [33/11 KV & 11/0.415 KV] & HT CABLE ROUTE LAYOUT, SHRI RADHA GULMOHAR, MATHURA.

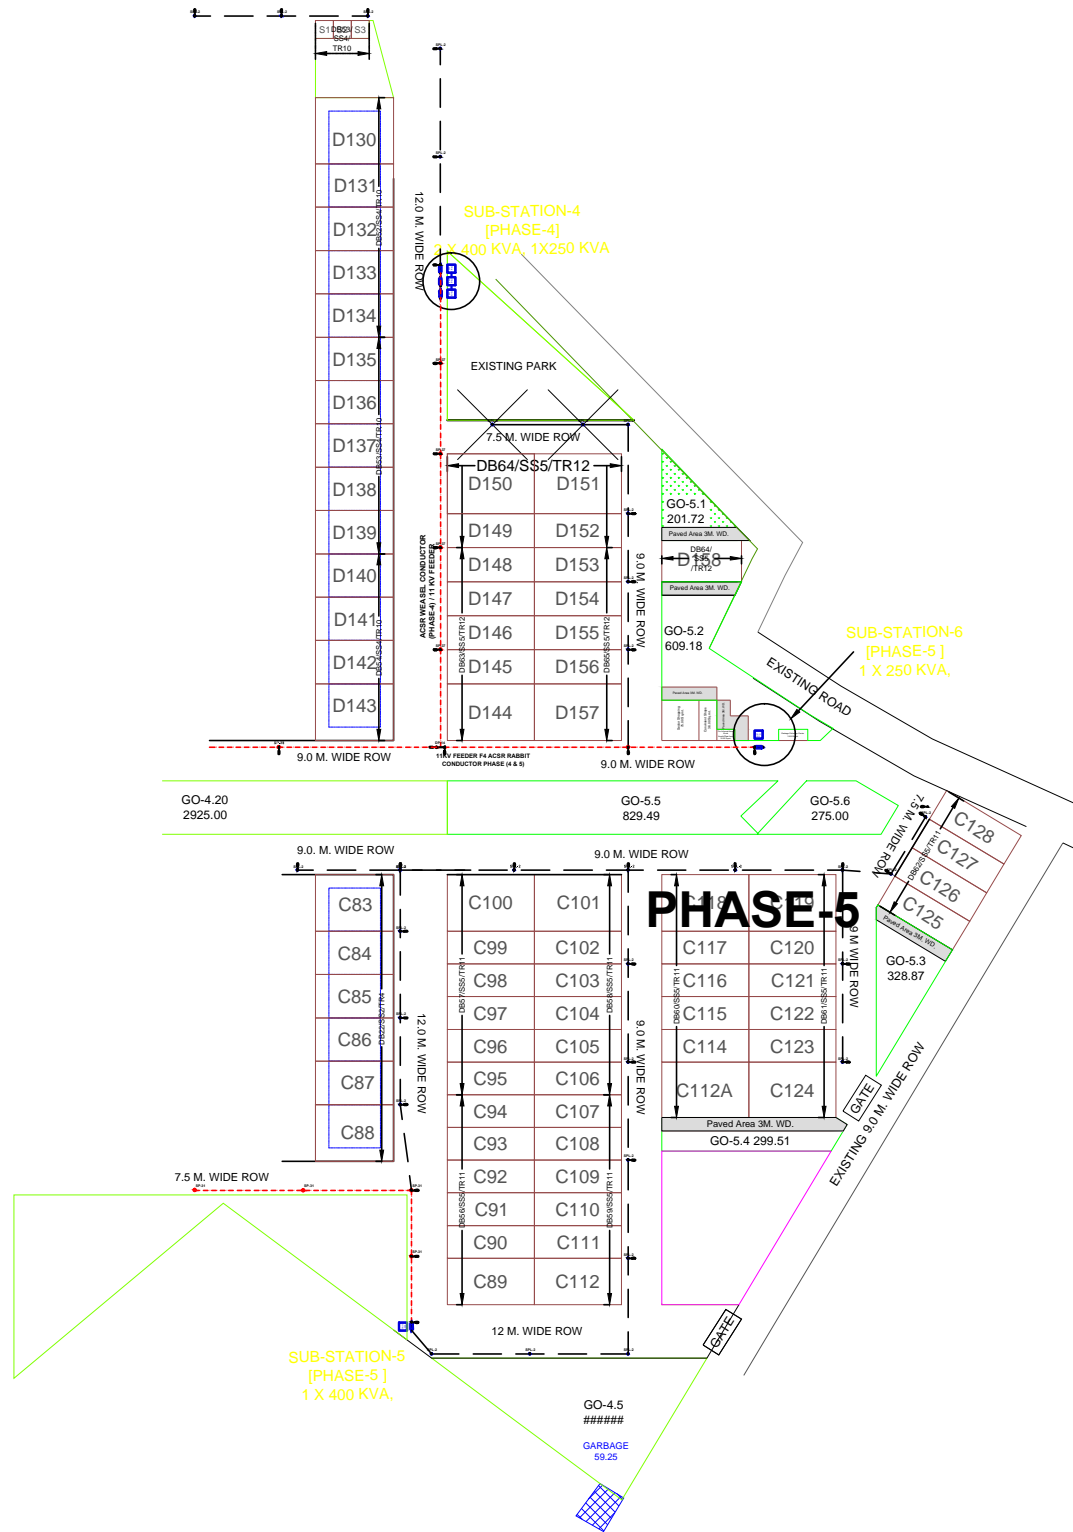

--- LT LINE

S.NO.	SYMBOL	DESCRIPTION
1.		DOUBLE POLE
2.		SINGLE POLE
3.		11/0.415 KV TRANSFORMER
4.		MCCB BOX
5.		ACSR DOG / RABBIT CONDUCTOR

<b>Revision Notes:</b>		<b>Sheet No.:</b> 1/1	<b>ELECTRICAL CONSULTANTS:</b>	<b>PROJECT:</b>
<b>Rev. No.</b>	<b>Date</b>	<b>Description</b>	<b>Drawn By:</b> Er. NISHANT SINGH	SHRI RADHA GULMOHAR
R1	14.10.22	AREA TAKEN AS PER FAR AND ABC CONDUCTOR	<b>Checked By:</b> Er. ANIL K. GOYAL	
			<b>Date:</b> 4.2.2023	<b>DRAWING TITLE:</b>
			<b>Rev. No.</b> (R1) <b>NORTH:</b>	ELECTRICAL LAYOUT

**EMCOTECH**  
ENGINEERS & AUDITORS  
PVT. LIMITED  
1, Ellora Complex, Khandari Crossing,  
Surya Nagar, Agra-282002.  
E- mail: ansh13579@gmail.com