


DREAM TOWN

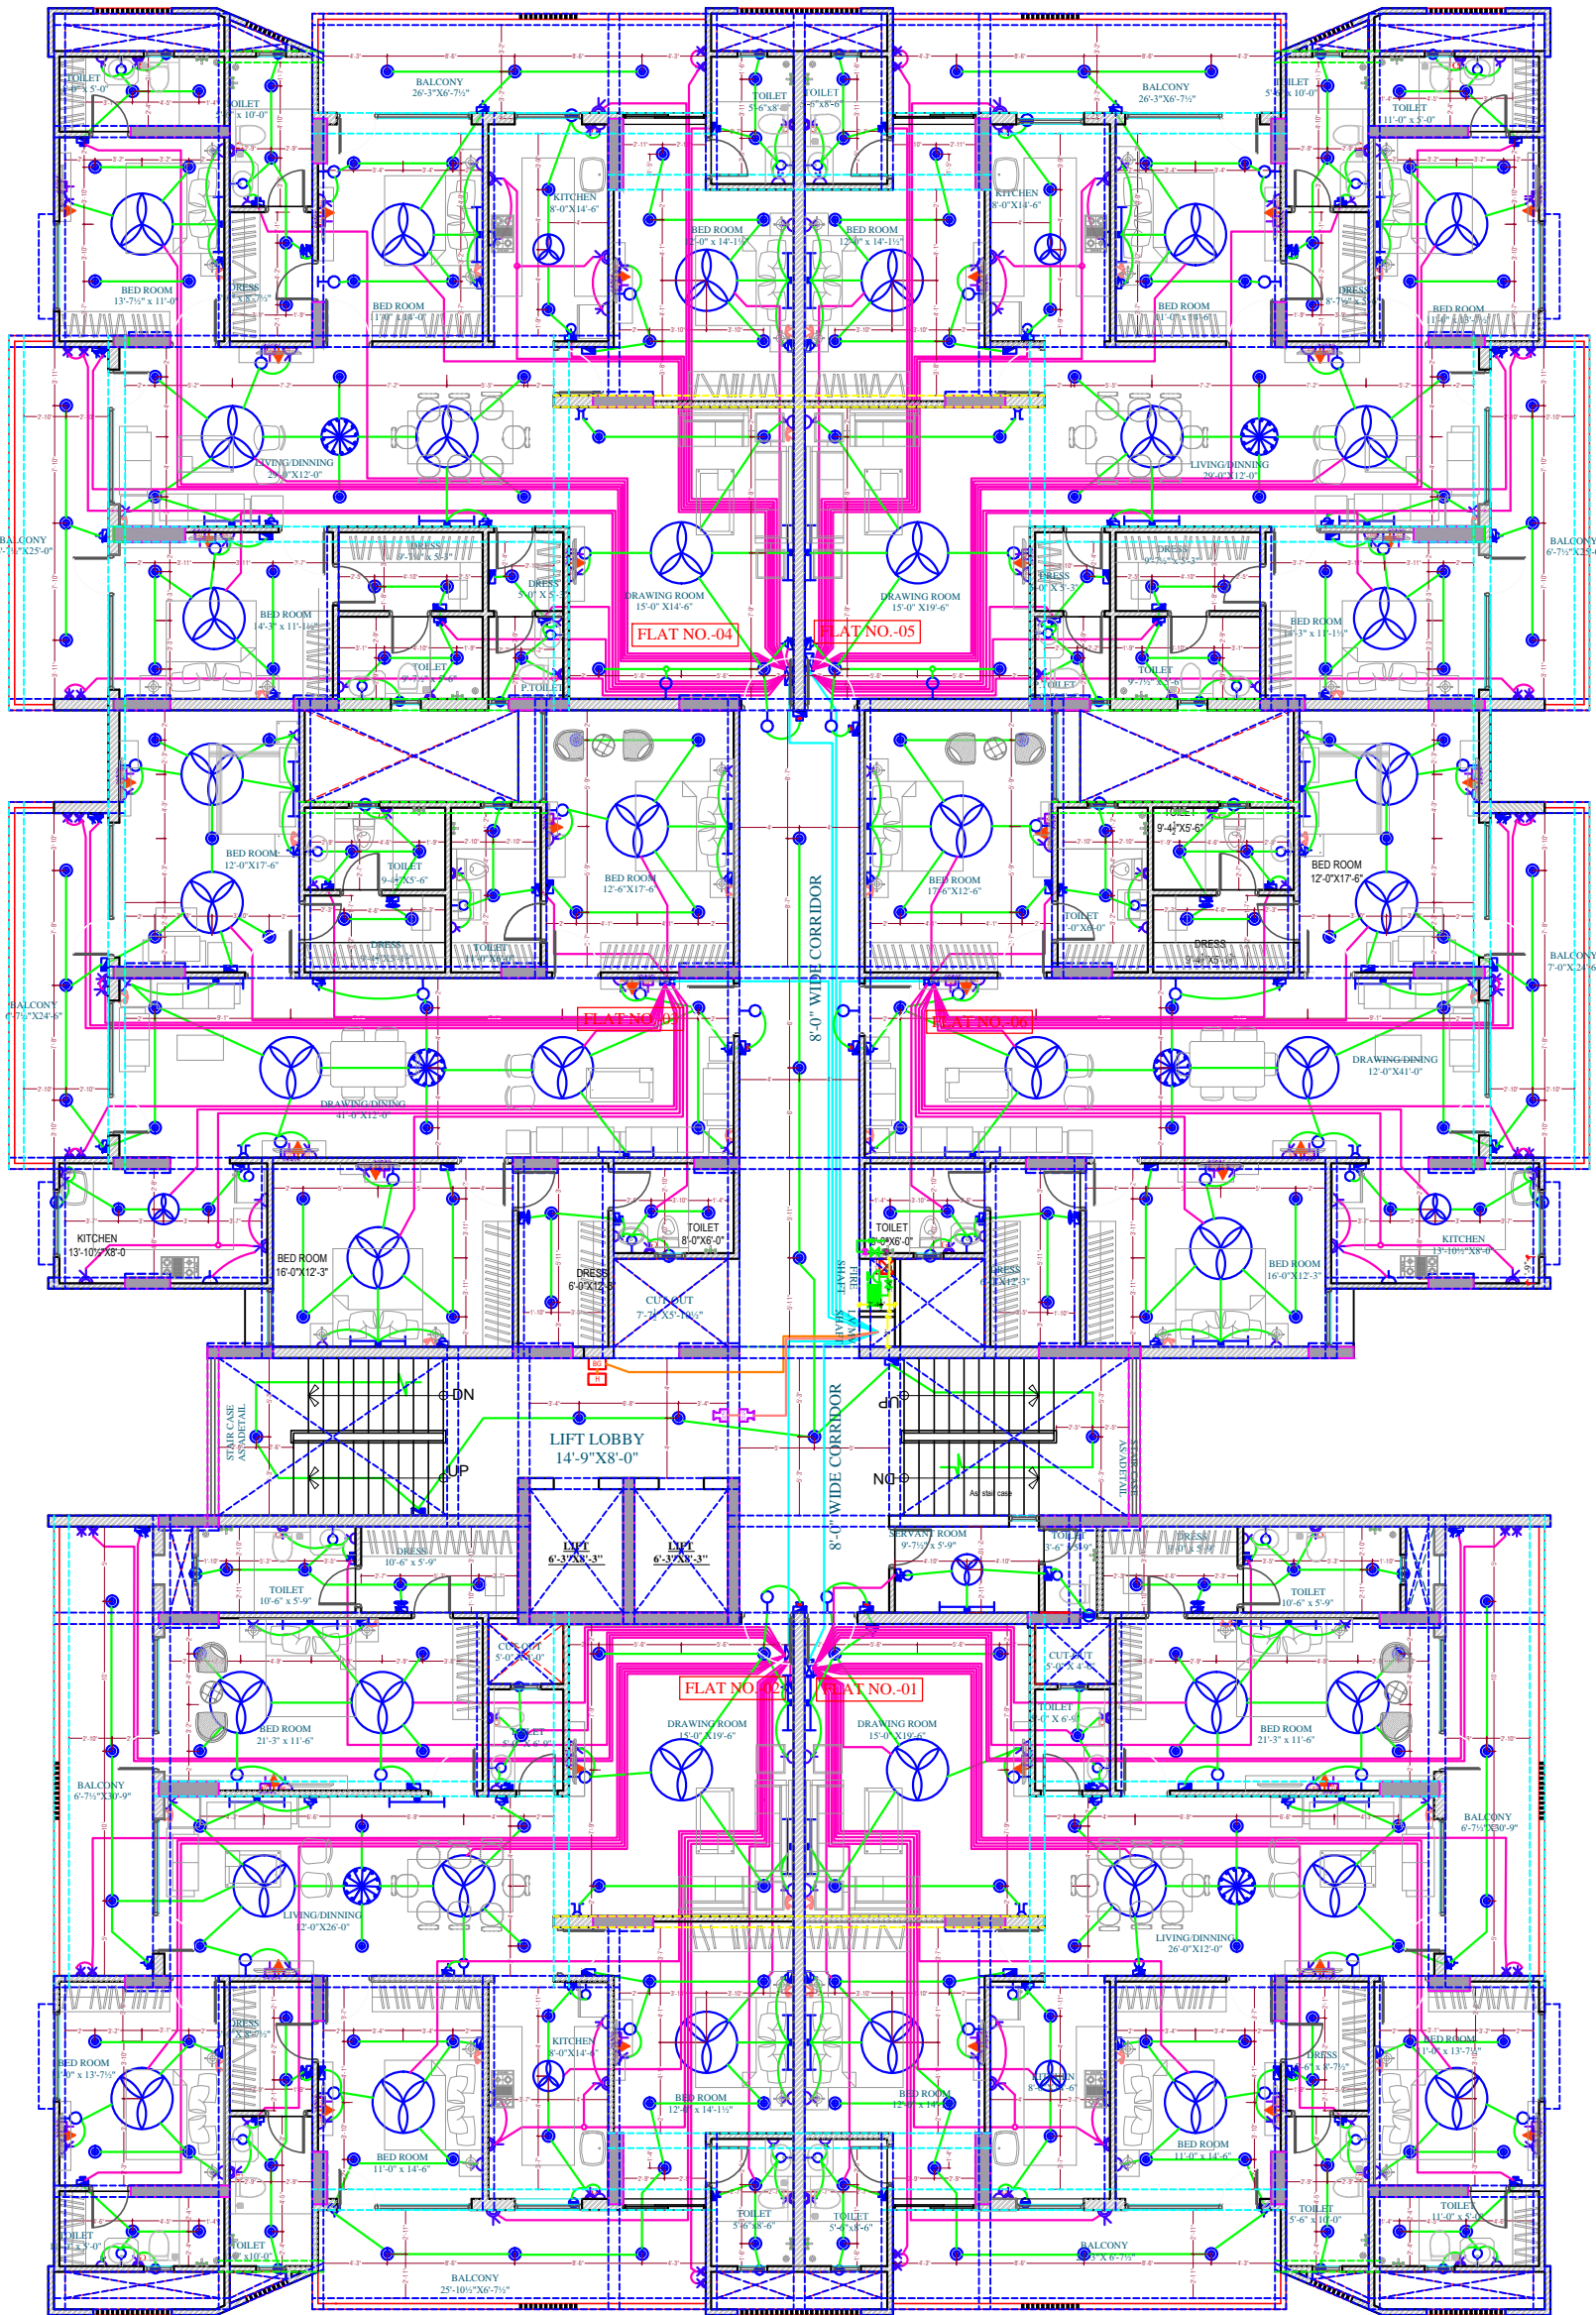

LEGEND			
NO	DESCRIPTION	SYMBOL	FROM FFL
1.	CEILING FAN		CEILING
2.	EXHAUST		6'-0\"/>
3.	WALL FAN POINT		6'-0\"/>
4.	A C POINT(WINDOW AC)		1'-0\"/>
5.	A C POINT(SPLIT AC)		AS PER SITE
6.	3 PHASE POINT		AS PER SITE
7.	A C SOCKET		AS PER SITE
8.	3 AMP POWER PLUG POINT(GENERAL)		1'-0\"/>
9.	GYSER SOCKET 16 AMP		6'-0\"/>
10.	3 AMP POWER PLUG POINT(KITCHEN)		1'-0\"/> ABOVE KITCHEN SLAB
11.	5 AMP PLUG POINT (BED SIDE)		2'-6\"/>
12.	6 AMP SOCKET (CHIMNEY)		7'-0\"/>
13.	1000 AMP POWER PLUG POINT (FOR TV)		1'-6\"/>
14.	2 NOS 6 AMP SOCKET		1'-6\"/>
15.	6 AMP PLUG POINT (GENERAL)		4'-0\"/>
16.	KEY TAG		4'-0\"/>
17.	INVERTOR SOCKET		1'-6\"/>
18.	SWITCH BOARD WITH OUT 6 AMP SOCKET		4'-0\"/>
19.	SWITCH BOARD WITH 6 AMP SOCKET		4'-0\"/>
20.	BELT		4'-0\"/>
21.	GYSER SWITCH 16 AMP		4'-0\"/>
22.	PROJECTOR POINT		3'-6\"/>
23.	TOILET POINT (ON BED SIDE)		2'-6\"/>
24.	TELEPHONE POINT (GENERAL)		1'-0\"/>
25.	TV POINT (GENERAL)		2'-6\"/>
26.	LANS POINT		2'-6\"/>
27.	CEILING LIGHT 2X2'		CEILING
28.	CEILING LIGHT		CEILING
29.	CHANDILLER		CEILING
30.	40W TUBE LIGHT ON CEILING		CEILING
31.	BULB HOLDER ON SIDE WALL		7'-3\"/>
32.	TUBE LIGHT ON WALL		7'-3\"/>
33.	BULKHEAD Feature		2'-6\"/>
34.	DISTRIBUTION BOX		5'-0\"/>
35.	BELL		7'-3\"/>
36.	CONDUIT CIRCUIT (25MM)		CEILING
37.	CONDUIT POINT WIRING (25MM)		CEILING
38.	CONDUIT SUB MAIN WIRING (25MM)		CEILING

LEGEND			
NO	DESCRIPTION	SYMBOL	QTY
1.	SMOKE DETECTOR		NIL
2.	FIRE EXIT		01 Nos
3.	MANUAL CALL POINT		01 Nos
4.	HOOTER		01 Nos
5.	25MM CONDUIT FIRE		

REVISIONS

DT.	NO.	ISSUED TO	CKD.

MEP CONSULTANTS :

SRAJAN ASSOCIATES
C-SCHEME, JAIPUR
Email :- snajaipur@hotmail.com

PROJECT TITLE
PROPOSED RESIDENTIAL APARTMENT AT DREAM TOWN GROUP HOUSING FIROZABAD
DRAWING TITLE
TYPICAL FLOOR ELECTRICAL PLAN

ARCHITECTS :
MISHRA GARG & ASSOCIATES
C-35, LAJPAT MARG, C-SCHEME, JAIPUR.

DEALT	CHECKED	DATE	NORTH

SCALE	JOB NO.	DRG. NO.

N.T.S.	3.101

