


50.00 M Wide Road

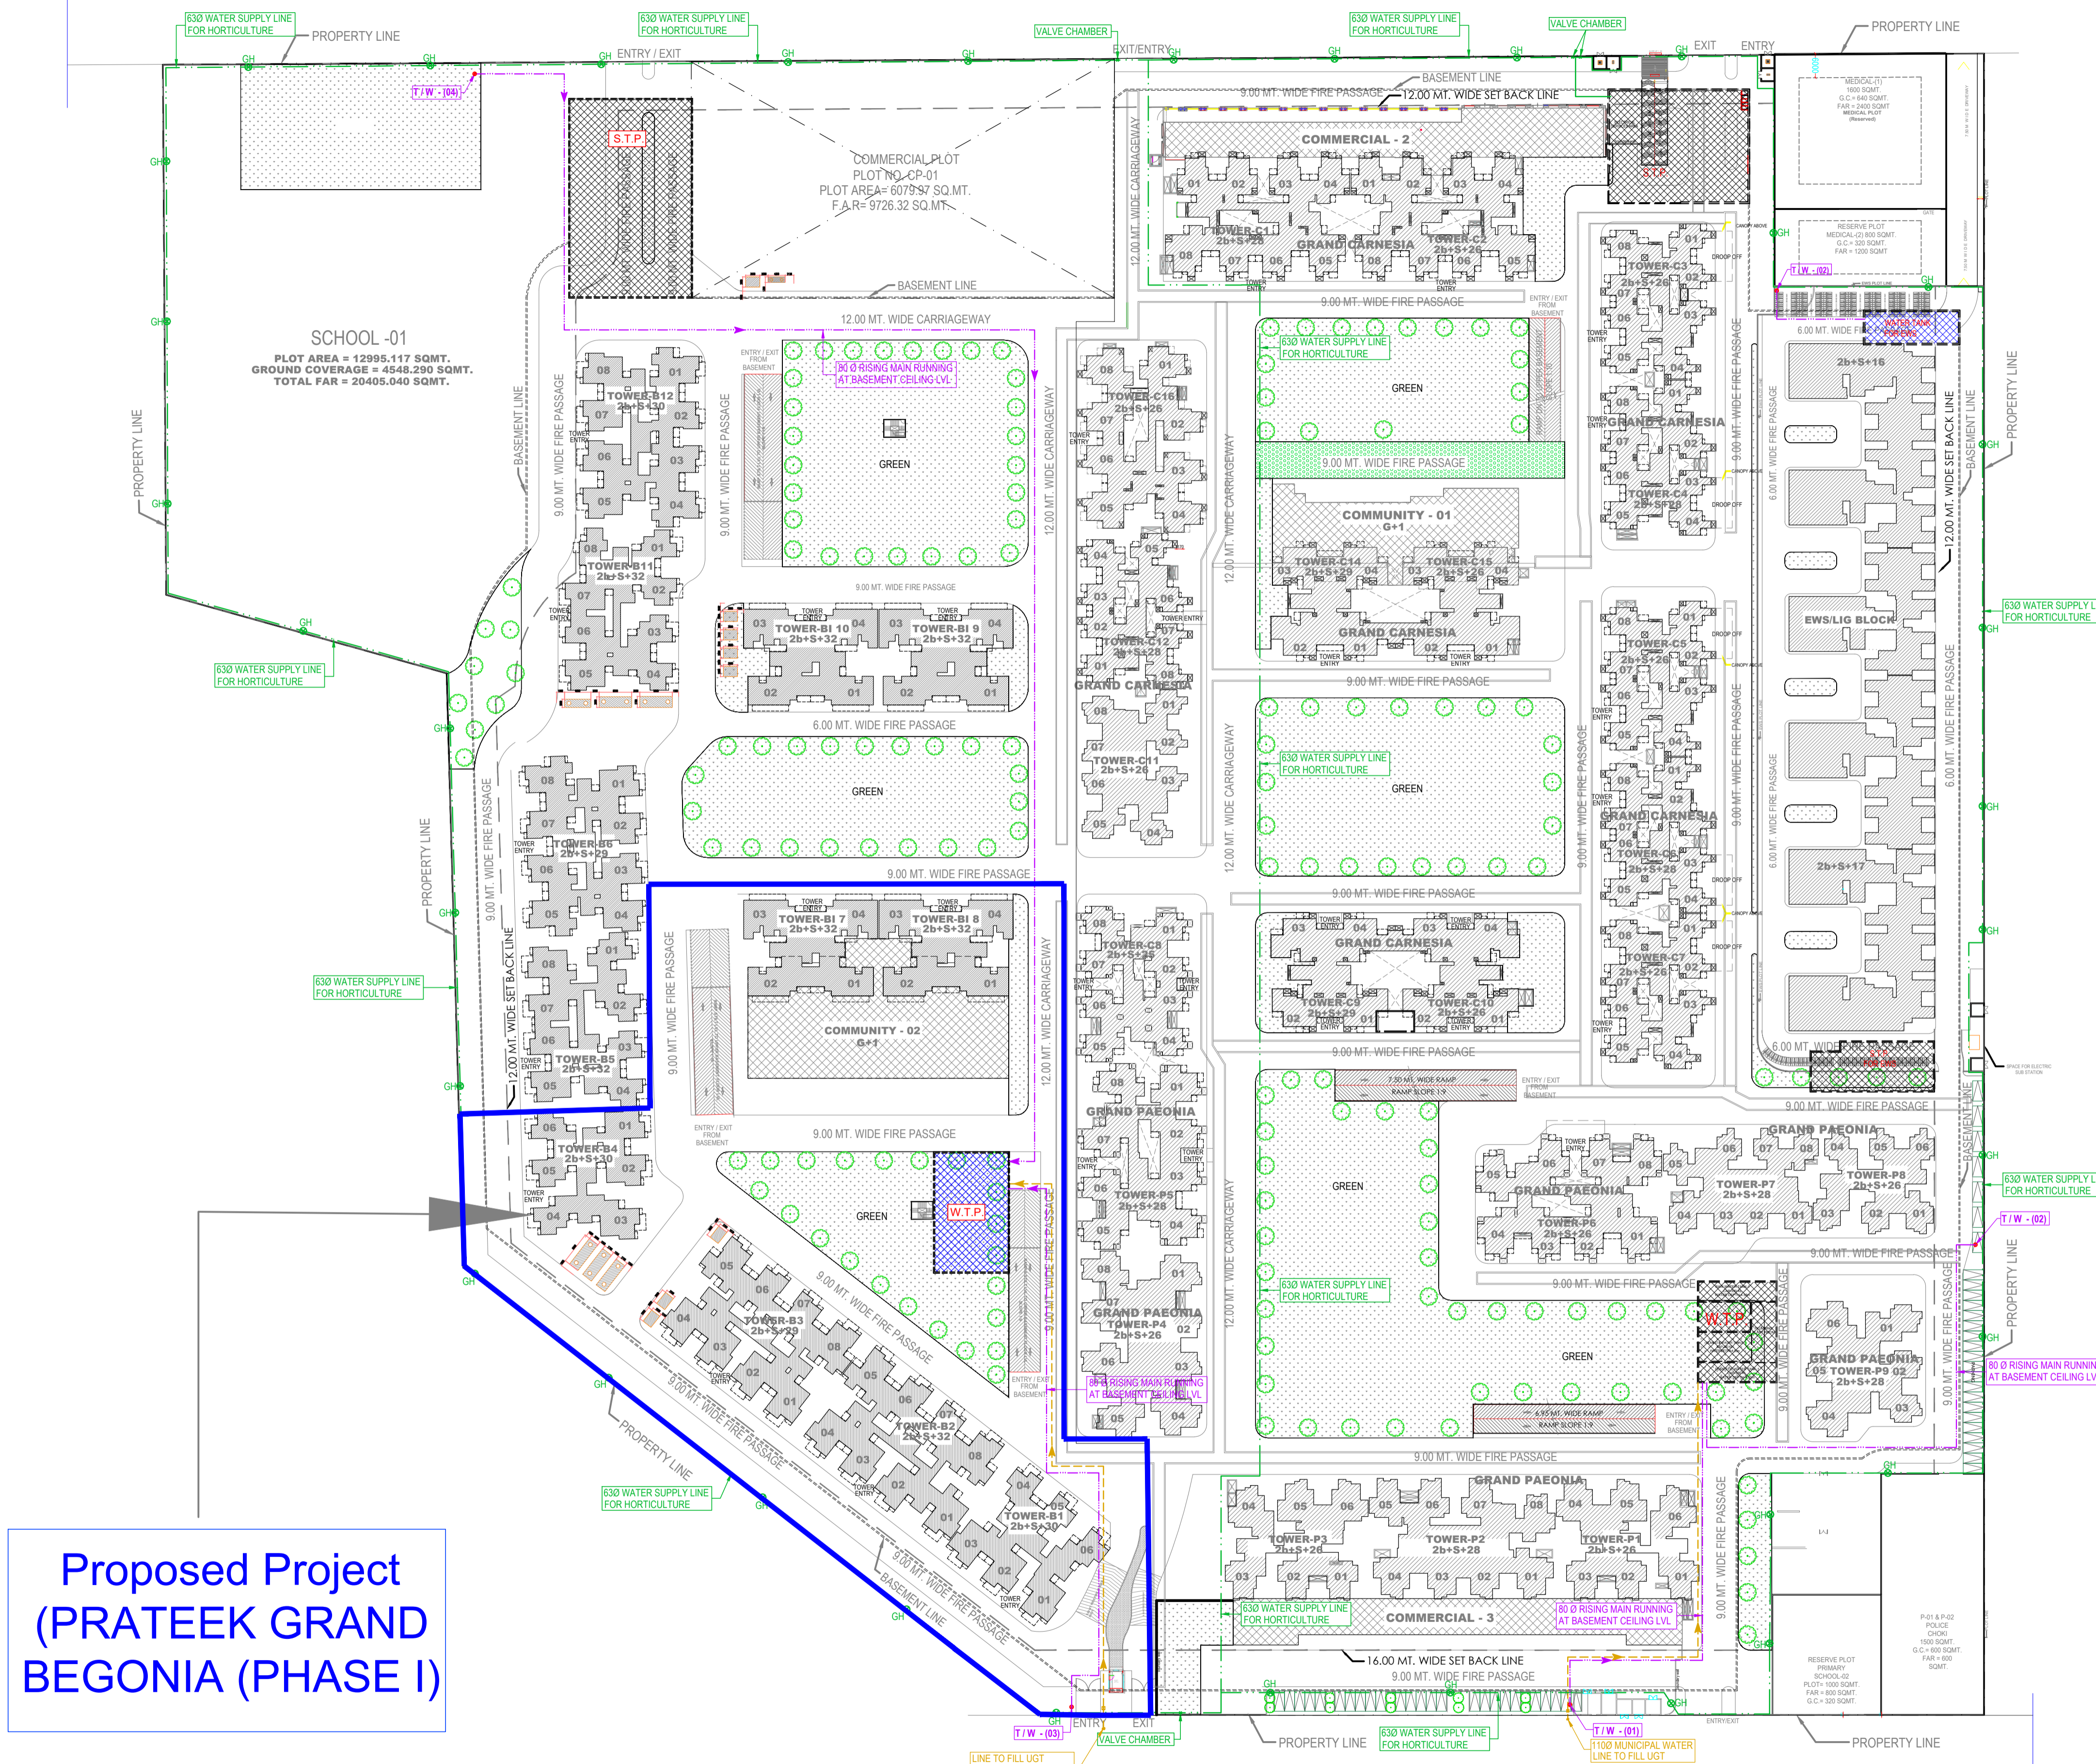

Proposed Project
(PRATEEK GRAND
BEGONIA (PHASE I))

LEGEND :

S. No.	SYMBOL	DESCRIPTION
1.		RISING MAIN LINE (FROM T/W TO U.G.T.)
2.		MUNICIPAL WATER SUPPLY PIPE LINE.
3.		RECYCLED WATER SUPPLY LINE FOR HORTICULTURE.
4.		PROPOSED TUBE WELL
5.		GARDEN HYDRANT
6.		MASONRY CHAMBER FOR ISOLATING VALVE
7.		BASEMENT RETAINING WALL

Rev. No.	Date	Revision

project
**PRATEEK GRAND CITY
SIDDHARTH VIHAR , GHAZIABAD**

title
SITE PLAN

subtitle
EXTERNAL WATER SUPPLY LAYOUT

drawing released for
 APPROVAL SUBMISSION
 ADVANCE COPY CONSTRUCTION

drw. no. PGC / SP / PL - 03 drawn by S.Bhandari

scale 1:900 @ A1 designed by Shakir Shabir

date 02.05.2022 checked by ANAND HAVELIA

architect
Architect Hafeez Contractor
29 Bank Street, Bombay 23, Tel: +91 22 22661920 — fax: +91 22 22664737
www.architecthafeezcontractor.com email: hafeez@hcontractor.com

services consultant
Consummate Engineering Services (P) Ltd.
Noida Office : B - 67, Sector - 67, Noida - 201 301
Tel : (0120) 2593500 (30 Lines)
Lko. Office : R 006, Rohtas Plumeria, Gomti Nagar, Lucknow
e mail : mail@cespl.in, website : www.cespl.in

75.00 M Wide Road