


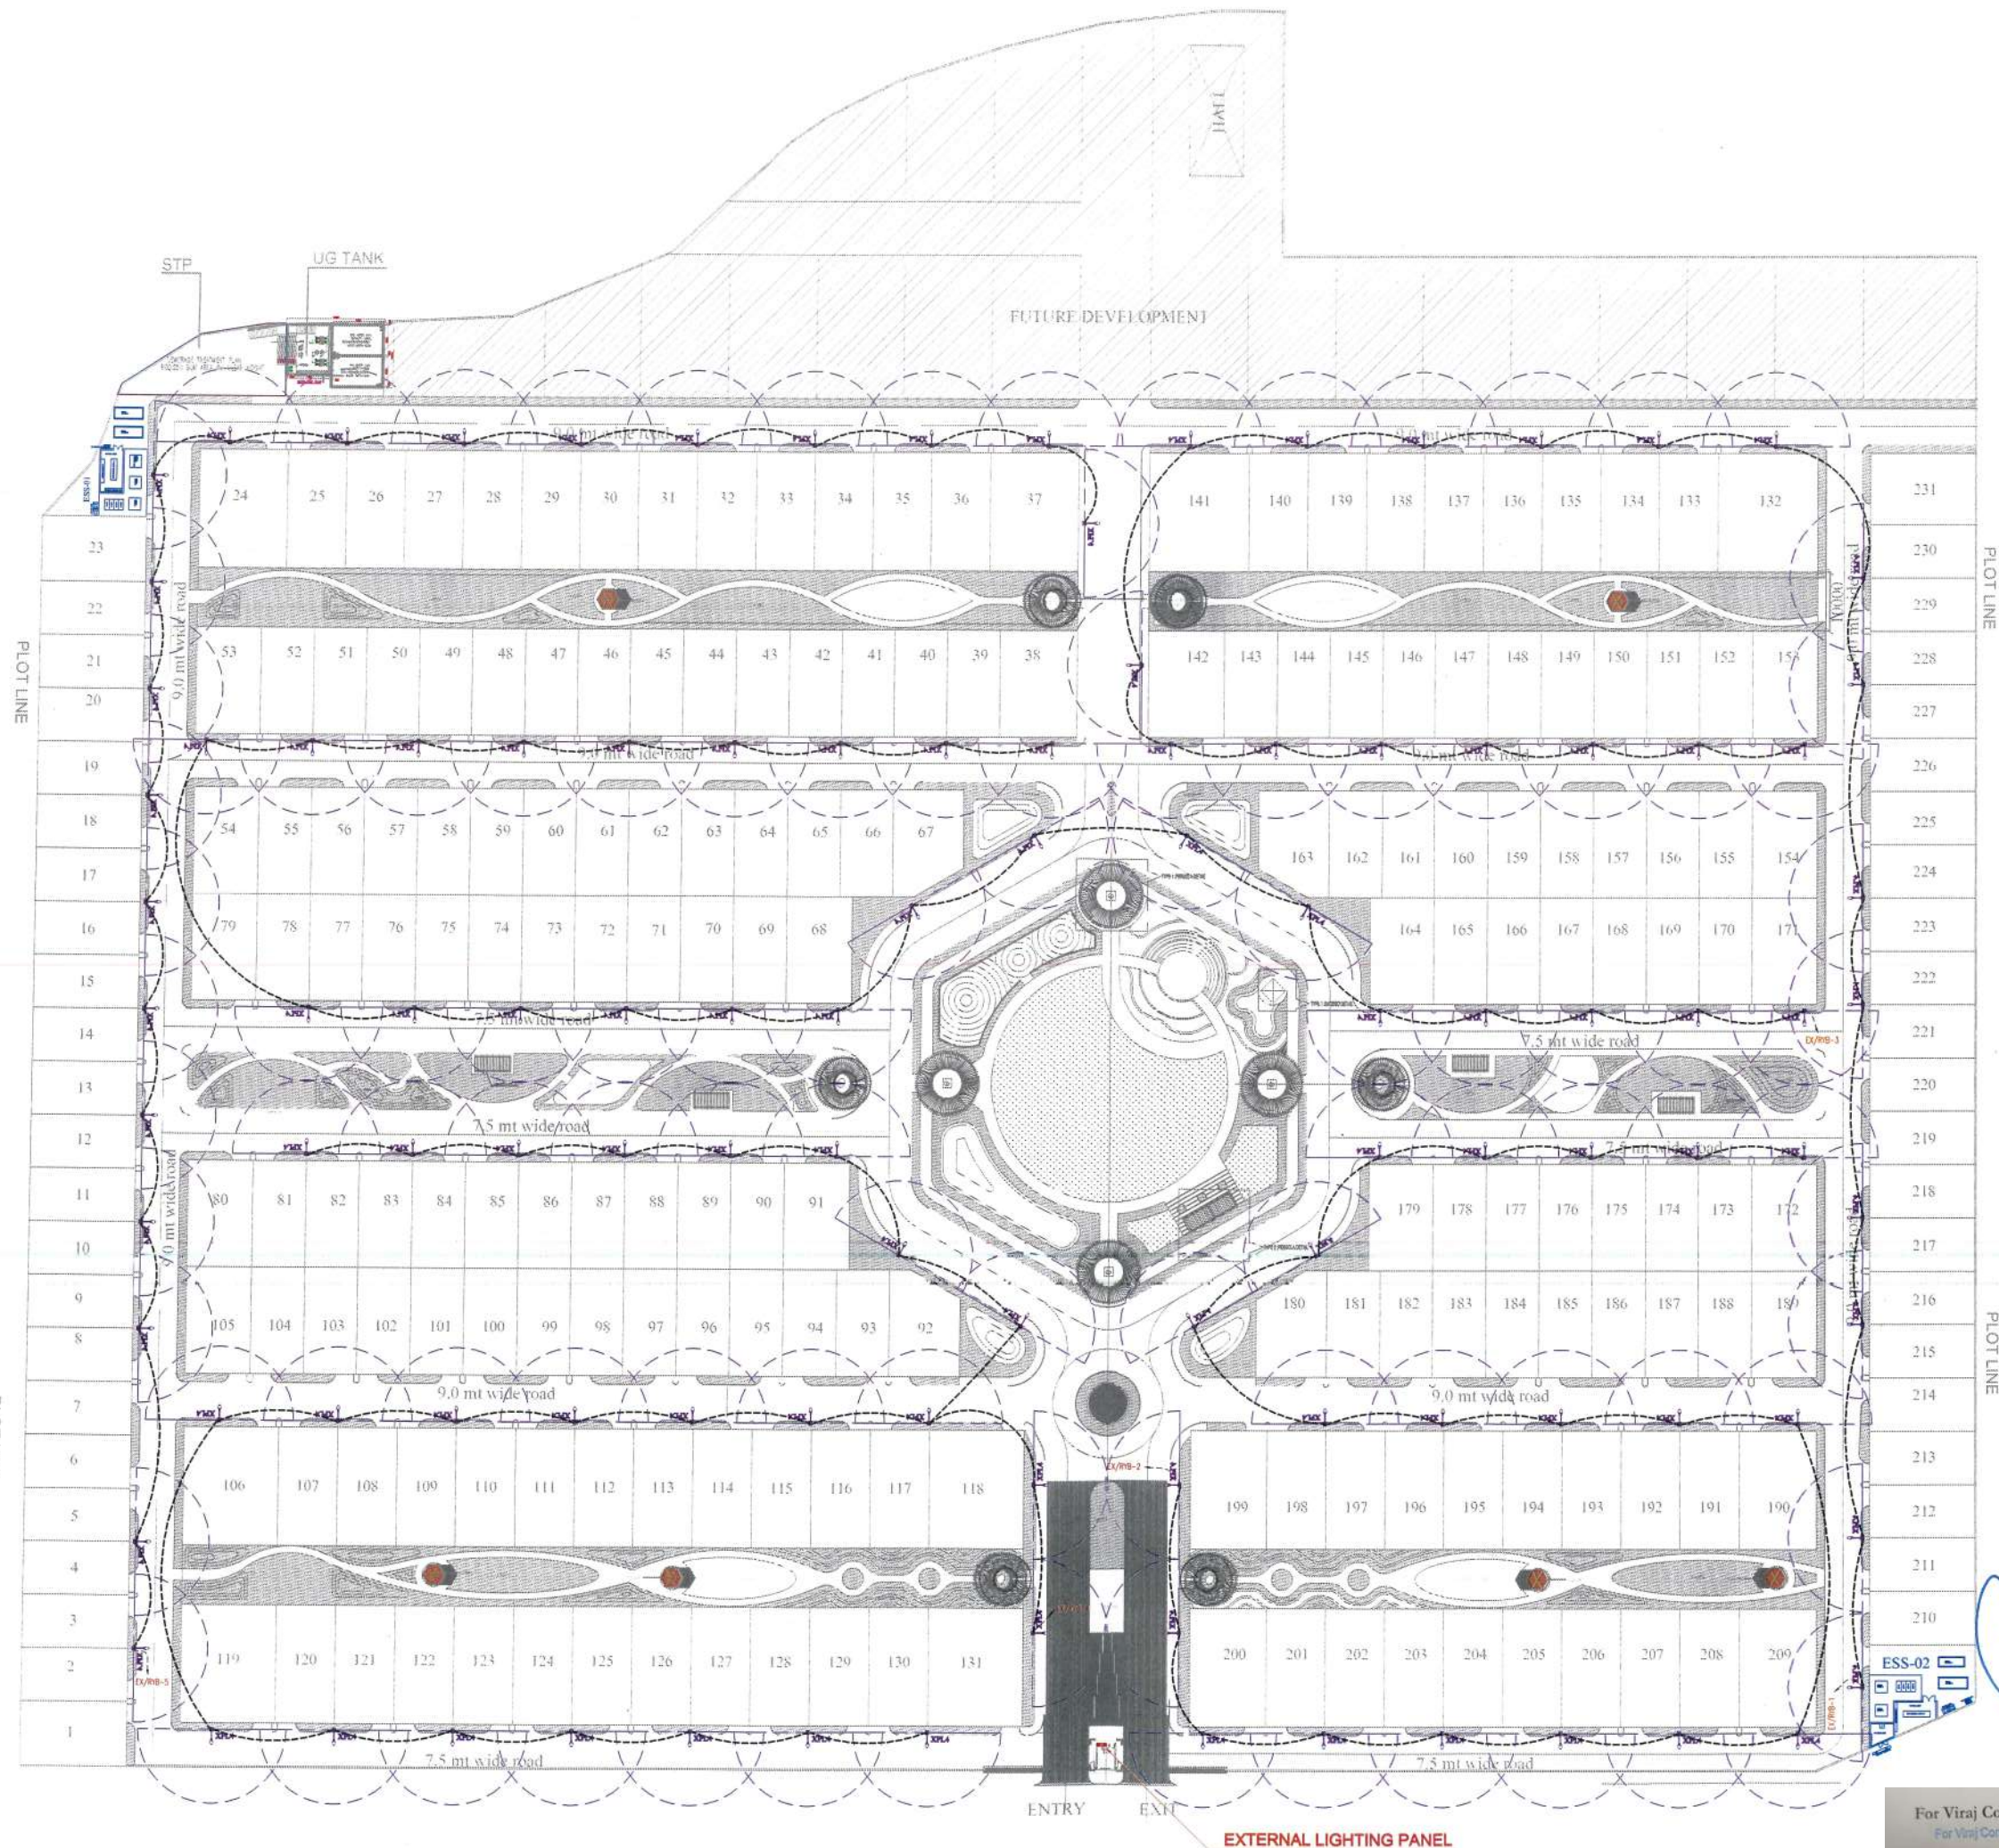

LEGEND		
SR.NO	SYMBOL	DESCRIPTION
01.		EXTERNAL LIGHTING PANEL
02.		4 CORE AL AL XLPE CABLE BURIED DIRECT IN GROUND 63MM OUTER DIA HDPE PIPE FOR ROAD CROSSING ONLY STREET LIGHTING (TENTATIVE DEPTH 750 mm)
03.		STREET LIGHT AS PER LANDSCAPE CONSULTANT

MEANS OF CIRCUIT CODES:-

"EX/RVB-1" :- "EX/" INDICATE EXTERNAL LIGHTING PANEL, "/RVB-1" INDICATE PHASES

"-1" :- "1" INDICATE PHASE FIRST CIRCUIT NUMBER

PROJECT NAME	
PROPOSED LAYOUT PLAN OF AMBROSIA ESTATES, BBD GREEN CITY	
ARCHITECT	
jsr C-67, Defence colony New delhi Phone- 011-40580350, Email: info@jsr.net.in	
ELECTRICAL SERVICES CONSULTANT	
 ECMS INDIA PVT. LTD. WP-21 C-282, BASEMENT NOKIA SECTOR-71, UTTAR PRADESH-201307 E-mail: ecms.tech01@gmail.com URL: www.ecmsindia.com	
DRAWING TITLE:- EL-STREET LIGHTING LAYOUT SITE PLAN	
☒ FOR APPROVAL	☐ ADVANCE COPY
☐ TENDER DRAWING	☐ GOOD FOR CONSTRUCTION
DRAWN BY SHADAB	REV NO. R1(09.07.2025)
OKD BY SANJAY	SCALE 1:550 (A-1)
FIN. YEAR 2024-2025	JOB NO. 2569
DRAWING NO.	AE/ECMS/SP/EL-02

For Viraj Constructions Pvt. Ltd.
For Viraj Constructions Pvt. Ltd.
Director
Authorised Signatory