


OTHERS PLOT

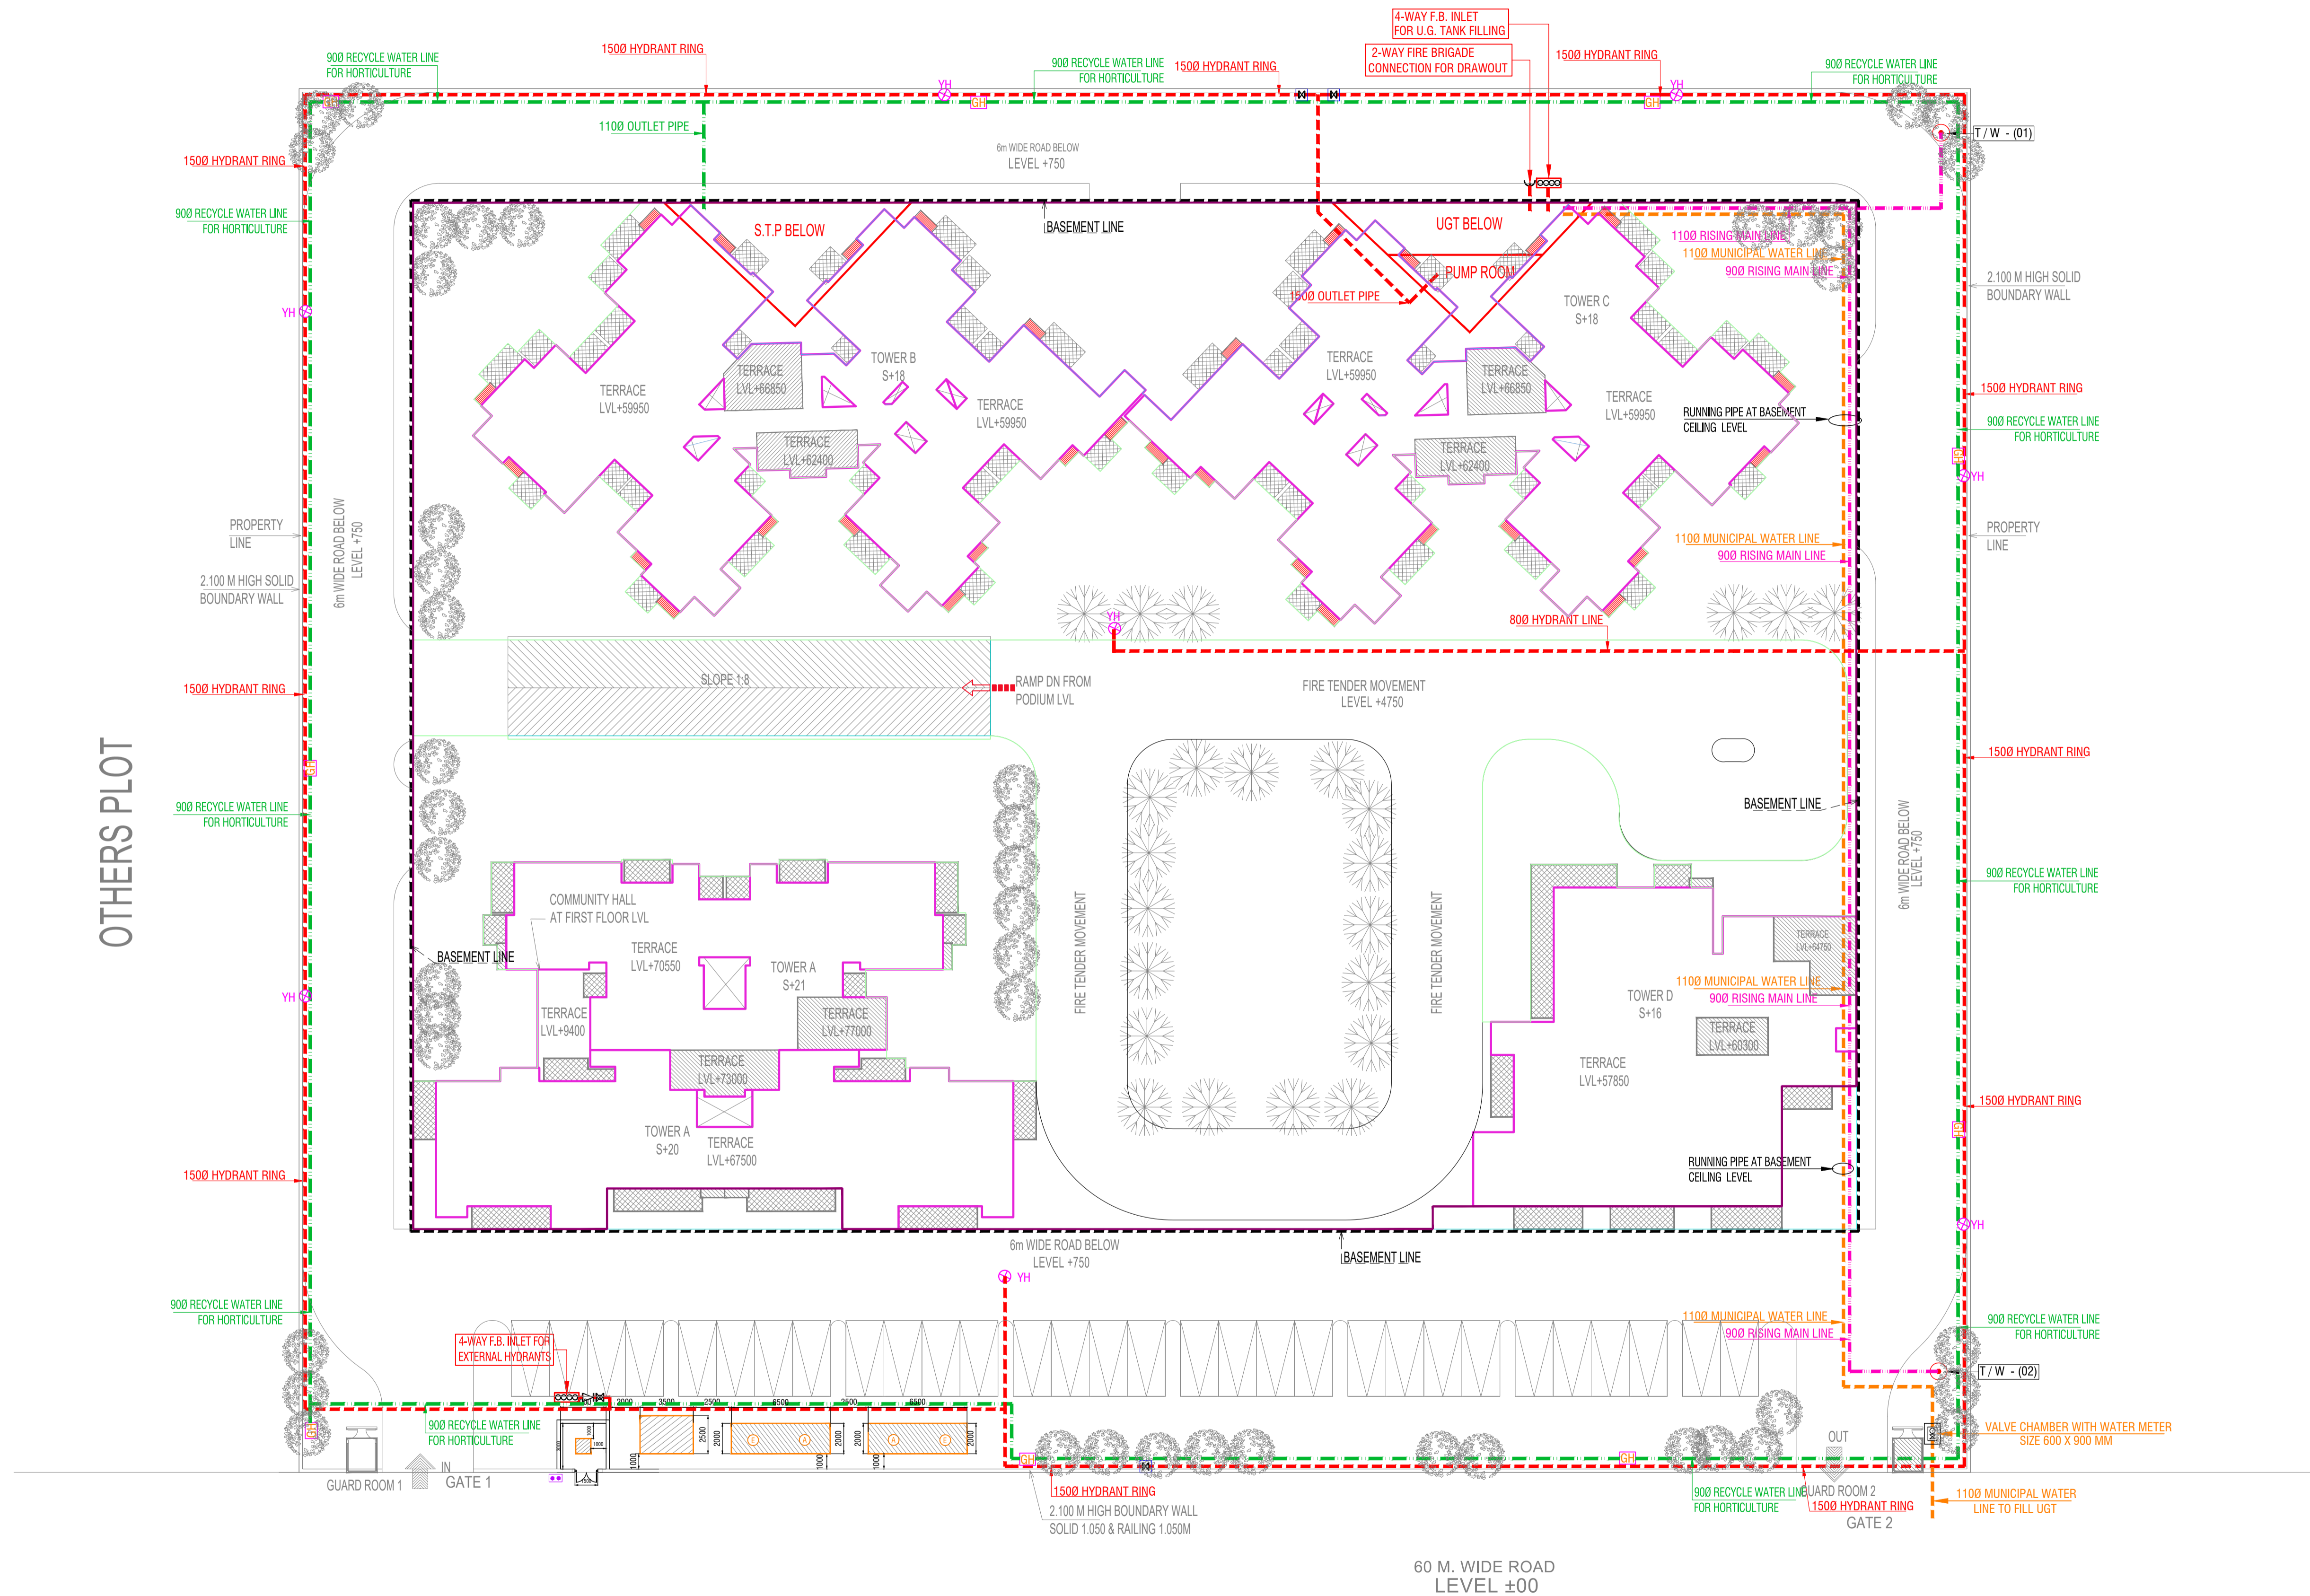


LEGEND :

S. No.	SYMBOL	DESCRIPTION
1.		RECYCLED WATER SUPPLY PIPE LINE.
2.		RISING MAIN WATER PIPE LINE.
3.		MUNICIPAL WATER SUPPLY PIPE LINE.
4.		INDICATES RECYCLED WATER SUPPLY PIPE LINE DIA.
5.		INDICATES RISING MAINS DIA.
6.		INDICATES MUNICIPAL WATER SUPPLY PIPE LINE DIA.
7.		ISOLATING VALVE
8.		PROPOSED TUBE WELL
9.		BASEMENT LINE
10.		GARDEN HYDRANT

LEGEND : FIRE SYSTEM

S. No.	SYMBOL	DESCRIPTION
1.		FIRE LINE
2.		YARD HYDRANT 63 M.M. DIA. SINGLE HEADED HYDRANT VALVE WITH 2 NOS. 15 M. LONG, 63 M.M. DIA. FIRE HOSE PIPE & 1 NO. BRANCH PIPE WITH NOZZLE
3.		FIRE BRIGADE CONNECTION
4.		BUTTERFLY VALVE
5.		NONRETURN VALVE (CHECK VALVE)
6.		ISOLATING VALVE WITH MASONARY CHAMBER

GIAN P. MATHUR
ARCHITECT
B. Arch., M.C.A., A.I.I.A.
CA No 80/5769

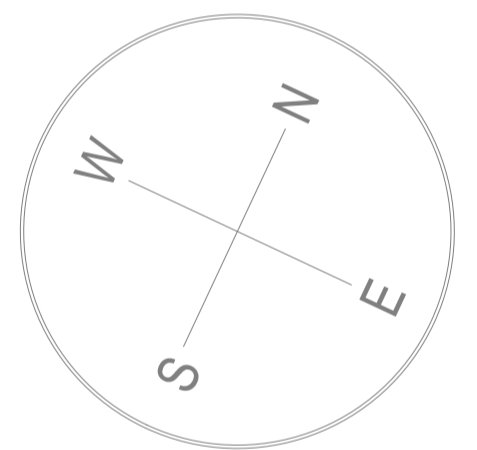

rev. no.	date	revision

project
SPRING HOMES
SC-1, GH-08, SPORTS CITY, TECHZONE, GREATERNOIDA

title
SITE PLAN

subtitle
EXTERNAL WATER SUPPLY SYSTEM

drawing released for
 APPROVAL AUTHORITY SUBMISSION
 ADVANCE COPY CONSTRUCTION

drg. no. S F / EX / S-04 **drawn by** Kulwant

scale 1 : 250 **designed by** R.K.

date **checked by** Anand Havelia

architects
GIAN P. MATHUR AND ASSOCIATES (P) LTD.
C - 55, East Of Kailash, New Delhi-110065 T. : 46595909 F. 46595512
E : gpma@airtelmail.in W : www.gpma.com

services consultant
Consummate Engineering Services (P) Ltd.
Noida Office : B - 67, Sector - 67, Noida - 201 301
Tel. : (0120) 2993500 (30 Lines)
Lko. Office : B-1006, Rohitas Plumaria, Gomti Nagar, Lucknow
Tel. : (0522) 8519455
e mail : mail@cespl.in, website : www.cespl.in

OTHERS PLOT

60 M. WIDE ROAD
LEVEL ±00