

LEGENDS:

- 6A ONE WAY SWITCH(NORMAL&EMERGENCY)
- 2X18W CFL RECESSED DOWN LIGHT (PHILIPS FBH 150/228)
- 1X18W CFL RECESSED DOWN LIGHT (PHILIPS FBH 150/128)
- 2x9W CFL SURFACE MOUNTED LIGHT
- 1x28W CEILING MOUNTED FLUORESCENT FIXTURE BOX TYPE (TMS 122/128HF)
- 1x28W WALL MOUNTED FLUORESCENT FIXTURE BOX TYPE (TMS 122/128HF)
- 2x36W FLUORESCENT LIGHT FIXTURE (PHILIPS TBS 670/236)
- 2x36W FLUORESCENT LIGHT FIXTURE (PHILIPS TKC 203/236HF)
- 2x28W FLUORESCENT LIGHT FIXTURE (PHILIPS TMS 122/228)
- 2x28W FLUORESCENT LIGHT FIXTURE (PHILIPS TBS 869/228)
- 2x36W FLUORESCENT LIGHT FIXTURE (PHILIPS TCW 097/236HF)
- BRICK LIGHT
- 6A SOCKET OUTLET FOR FAN COIL UNIT ABOVE FALSE CEILING
- BULK HEAD LIGHT WITH SWITCH ABOVE FALSE CEILING
- BOTTOM OF 6/18 AMP. UNIVERSAL SOCKET AT + 200mm A.F.L. UNLESS OTHERWISE MENTIONED
- 1X6 AMP SOCKET WITH SWITCH (NOT ON KEYCARD)
- BULK HEAD LIGHT (9W CFL PHILIPS FXC 101)
- DISTRIBUTION BOARD

NO. OF PRINTS	ISSUED TO	DATE
00	--	00/00/00

S.N.	DATE	DETAILS
REVISIONS		

PROJECT
 ORIZZONTE COMMERCIAL PROJECT
 PLOT NO. 22 SECTOR IT, KP-III
 GREATER NOIDA

CLIENT

FACILITY PLANNER

STRUCTURAL CONSULTANT


Concept Design Consortium PVT. LTD
 STRUCTURAL ENGINEERS & PROJECT CONSULTANTS
 Branch OFFICE : PLOT NO. D-152, NEEL GOLF COURSE ST., SECTOR-54, NOIDA

ARCHITECT

GENRE OF DESIGN
 ARCHITECTURE, MASTER PLANNING
 & INTERIOR DESIGN
 A-57, BASEMENT FLOOR, SHIVAJI, MALVIYA NAGAR, NEW DELHI
 TELEPHONE: 011-40574968

MEP CONSULTANTS

C TO C Services Consultants Pvt. Ltd.
 F-67, - (Basement) Green Park Main,
 New Delhi-110016 (INDIA)
 Tel.: 41618888, 41618866
 E-mail: ctocinfo@ctocconsultants.com

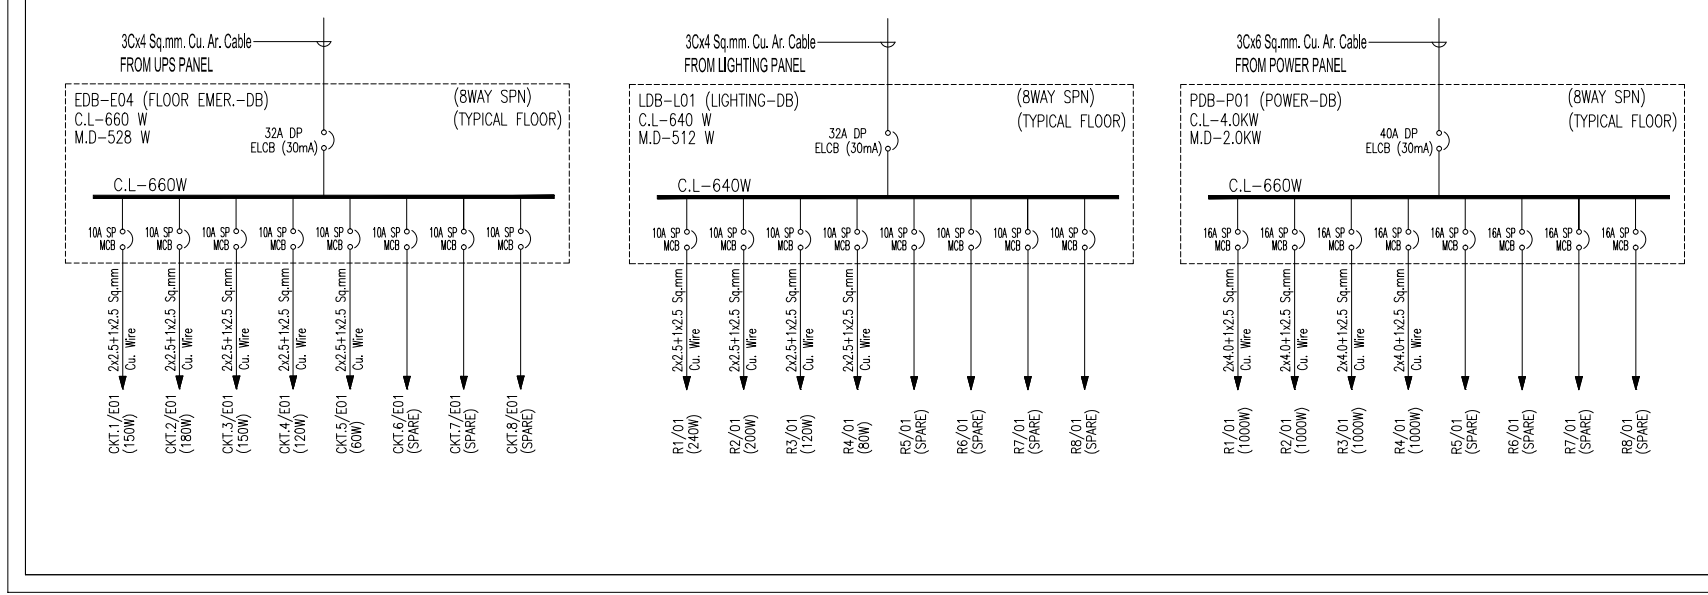

STAGE
 SCHEMATIC DRAWING

DRAWING TITLE
 8TH FLOOR PLAN
 ELECTRICAL LAYOUT

Drawn	Checked	Approved
PK	PARVEEN	TANUJ
Scale	Date	Rev. No.
1:150 @ A1	10.03.2015	RO
Drawing No.		
CTOC.SEPL.1481.EL.11		