

GUEST ROOM-DB

GUEST ROOM-DB

LIFT WELL
LIGHT & POWER POINT AT
EVERY ALTERNATE FLOOR

GUEST ROOM-DB

LIGHT WELL
LIGHT & POWER POINT AT
EVERY ALTERNATE FLOOR

GUEST ROOM-DB

GUEST ROOM-DB

GUEST ROOM-DB

GUEST ROOM-DB

GUEST ROOM-DB

GUEST ROOM-DB

MDB-RM2.1(4TH FLOOR)
PDB-2.1.3(POWER DB)
COMMON AREA
LDB-2.1.1(GUEST ROOM)
LDB-2.1.2(TIMER DB)
COMMON AREA
GUEST ROOM-DB

GUEST ROOM-DB


GUEST ROOM-DB

GUEST ROOM-DB

GUEST ROOM-DB

GUEST ROOM-DB

4TH FLOOR

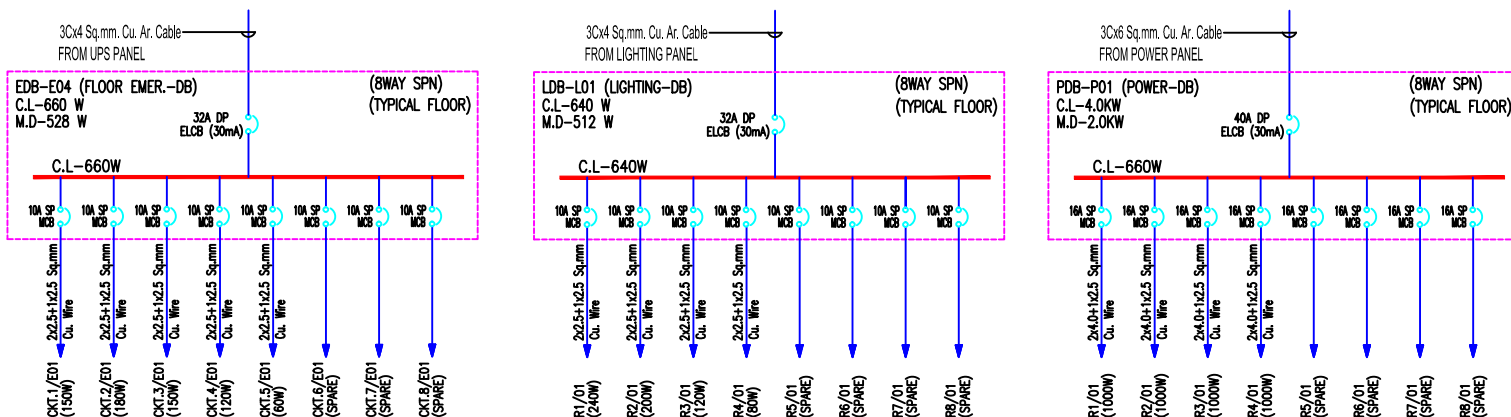

00	—	00/00/00
NO. OF PRINTS	ISSUED TO	DATE
REVISIONS		
S.N.	DATE	DETAILS
PROJECT		
ORIZZONTE COMMERCIAL PROJECT PLOT NO. 22 SECTOR IT, KP-III GREATER NOIDA		
CLIENT		
FACILITY PLANNER		
STRUCTURAL CONSULTANT		
Konzept Design Consortium PVT. LTD STRUCTURAL ENGINEERS & PROJECT CONSULTANTS <small>Phase 02A : PLOT NO. 2-12A/12B/12C/12D/12E/12F/12G/12H/12I/12J/12K/12L/12M/12N/12O/12P/12Q/12R/12S/12T/12U/12V/12W/12X/12Y/12Z</small>		
ARCHITECT		
GENRE OF DESIGN		
ARCHITECTURE, MASTER PLANNING & INTERIOR DESIGN A-57, BASEMENT FLOOR, SHALUK, MALVIYA NAGAR, NEW DELHI TELEPHONE: 011-40574968		
MEP CONSULTANTS		
C TO C Services Consultants Pvt. Ltd. F-67, (Basement) Green Park Main, New Delhi-110016 (INDIA) Tel.: 41618888, 41618866 E-mail: ctocinfo@ctocconsultants.com		
STAGE		
DESIGN DEVELOPMENT		
DRAWING TITLE		
4TH FLOOR PLAN ELECTRICAL LAYOUT		
Drawn	Checked	Approved
PK	PARVEEN	TANUJ
Scale	Date	Rev. No.
1:75 @ A1	10.03.2015	RO
Drawing No.		
CTOC.SEPL.1481.EL.07		