

GUEST ROOM-DB

GUEST ROOM-DB

LIFT WELL
LIGHT & POWER POINT AT
EVERY ALTERNATE FLOOR

GUEST ROOM-DB

LIGHT WELL
LIGHT & POWER POINT AT
EVERY ALTERNATE FLOOR

GUEST ROOM-DB

GUEST ROOM-DB

GUEST ROOM-DB

GUEST ROOM-DB

GUEST ROOM-DB

MDB-RM2.1(5TH FLOOR)
PDB-2.1.3(POWER DB)
COMMON AREA
LDB-2.1.1(GUEST ROOM)
LDB-2.1.2(TIMER DB)
COMMON AREA
GUEST ROOM-DB

GUEST ROOM-DB


GUEST ROOM-DB

GUEST ROOM-DB

GUEST ROOM-DB

GUEST ROOM-DB

5TH FLOOR

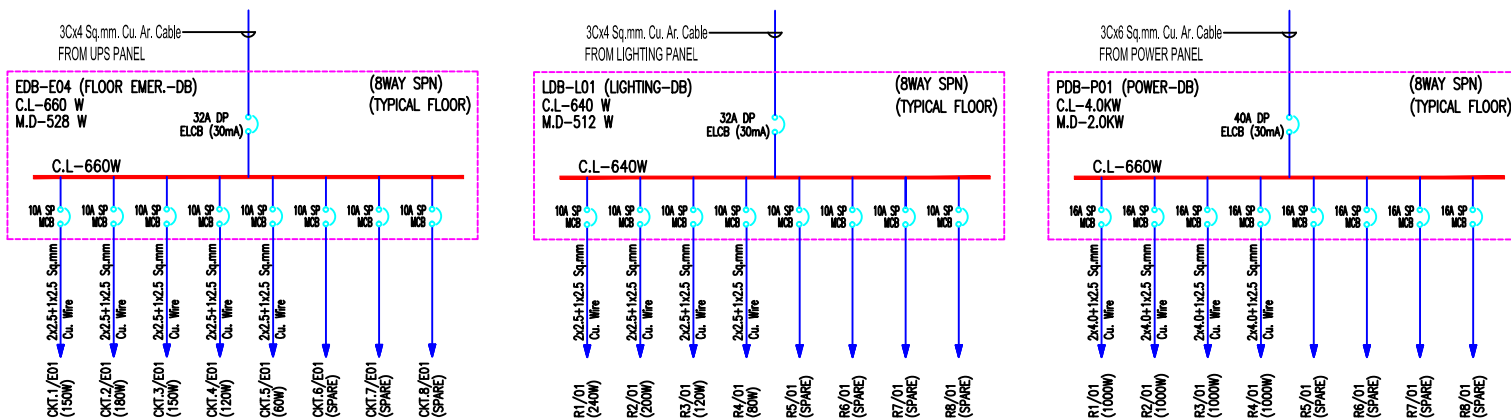

00	—	00/00/00
NO. OF PRINTS	ISSUED TO	DATE
REVISIONS		
S.N.	DATE	DETAILS
PROJECT		
ORIZZONTE COMMERCIAL PROJECT PLOT NO. 22 SECTOR IT, KP-III GREATER NOIDA		
CLIENT		
FACILITY PLANNER		
STRUCTURAL CONSULTANT		
Konzept Design Consortium PVT. LTD STRUCTURAL ENGINEERS & PROJECT CONSULTANTS <small>Phase 02A : PLOT NO. 2-15A/15B/15C/15D/15E/15F/15G/15H/15I/15J/15K/15L/15M/15N/15O/15P/15Q/15R/15S/15T/15U/15V/15W/15X/15Y/15Z/15AA/15AB/15AC/15AD/15AE/15AF/15AG/15AH/15AI/15AJ/15AK/15AL/15AM/15AN/15AO/15AP/15AQ/15AR/15AS/15AT/15AU/15AV/15AW/15AX/15AY/15AZ/15BA/15BB/15BC/15BD/15BE/15BF/15BG/15BH/15BI/15BJ/15BK/15BL/15BM/15BN/15BO/15BP/15BQ/15BR/15BS/15BT/15BU/15BV/15BW/15BX/15BY/15BZ/15CA/15CB/15CC/15CD/15CE/15CF/15CG/15CH/15CI/15CJ/15CK/15CL/15CM/15CN/15CO/15CP/15CQ/15CR/15CS/15CT/15CU/15CV/15CW/15CX/15CY/15CZ/15DA/15DB/15DC/15DD/15DE/15DF/15DG/15DH/15DI/15DJ/15DK/15DL/15DM/15DN/15DO/15DP/15DQ/15DR/15DS/15DT/15DU/15DV/15DW/15DX/15DY/15DZ/15EA/15EB/15EC/15ED/15EE/15EF/15EG/15EH/15EI/15EJ/15EK/15EL/15EM/15EN/15EO/15EP/15EQ/15ER/15ES/15ET/15EU/15EV/15EW/15EX/15EY/15EZ/15FA/15FB/15FC/15FD/15FE/15FF/15FG/15FH/15FI/15FJ/15FK/15FL/15FM/15FN/15FO/15FP/15FQ/15FR/15FS/15FT/15FU/15FV/15FW/15FX/15FY/15FZ/15GA/15GB/15GC/15GD/15GE/15GF/15GG/15GH/15GI/15GJ/15GK/15GL/15GM/15GN/15GO/15GP/15GQ/15GR/15GS/15GT/15GU/15GV/15GW/15GX/15GY/15GZ/15HA/15HB/15HC/15HD/15HE/15HF/15HG/15HH/15HI/15HJ/15HK/15HL/15HM/15HN/15HO/15HP/15HQ/15HR/15HS/15HT/15HU/15HV/15HW/15HX/15HY/15HZ/15IA/15IB/15IC/15ID/15IE/15IF/15IG/15IH/15II/15IJ/15IK/15IL/15IM/15IN/15IO/15IP/15IQ/15IR/15IS/15IT/15IU/15IV/15IW/15IX/15IY/15IZ/15JA/15JB/15JC/15JD/15JE/15JF/15JG/15JH/15JI/15JJ/15JK/15JL/15JM/15JN/15JO/15JP/15JQ/15JR/15JS/15JT/15JU/15JV/15JW/15JX/15JY/15JZ/15KA/15KB/15KC/15KD/15KE/15KF/15KG/15KH/15KI/15KJ/15KK/15KL/15KM/15KN/15KO/15KP/15KQ/15KR/15KS/15KT/15KU/15KV/15KW/15KX/15KY/15KZ/15LA/15LB/15LC/15LD/15LE/15LF/15LG/15LH/15LI/15LJ/15LK/15LL/15LM/15LN/15LO/15LP/15LQ/15LR/15LS/15LT/15LU/15LV/15LW/15LX/15LY/15LZ/15MA/15MB/15MC/15MD/15ME/15MF/15MG/15MH/15MI/15MJ/15MK/15ML/15MN/15MO/15MP/15MQ/15MR/15MS/15MT/15MU/15MV/15MW/15MX/15MY/15MZ/15NA/15NB/15NC/15ND/15NE/15NF/15NG/15NH/15NI/15NJ/15NK/15NL/15NM/15NO/15NP/15NQ/15NR/15NS/15NT/15NU/15NV/15NW/15NX/15NY/15NZ/15OA/15OB/15OC/15OD/15OE/15OF/15OG/15OH/15OI/15OJ/15OK/15OL/15OM/15ON/15OO/15OP/15OQ/15OR/15OS/15OT/15OU/15OV/15OW/15OX/15OY/15OZ/15PA/15PB/15PC/15PD/15PE/15PF/15PG/15PH/15PI/15PJ/15PK/15PL/15PM/15PN/15PO/15PP/15PQ/15PR/15PS/15PT/15PU/15PV/15PW/15PX/15PY/15PZ/15QA/15QB/15QC/15QD/15QE/15QF/15QG/15QH/15QI/15QJ/15QK/15QL/15QM/15QN/15QO/15QP/15QQ/15QR/15QS/15QT/15QU/15QV/15QW/15QX/15QY/15QZ/15RA/15RB/15RC/15RD/15RE/15RF/15RG/15RH/15RI/15RJ/15RK/15RL/15RM/15RN/15RO/15RP/15RQ/15RR/15RS/15RT/15RU/15RV/15RW/15RX/15RY/15RZ/15SA/15SB/15SC/15SD/15SE/15SF/15SG/15SH/15SI/15SJ/15SK/15SL/15SM/15SN/15SO/15SP/15SQ/15SR/15SS/15ST/15SU/15SV/15SW/15SX/15SY/15SZ/15TA/15TB/15TC/15TD/15TE/15TF/15TG/15TH/15TI/15TJ/15TK/15TL/15TM/15TN/15TO/15TP/15TQ/15TR/15TS/15TT/15TU/15TV/15TW/15TX/15TY/15TZ/15UA/15UB/15UC/15UD/15UE/15UF/15UG/15UH/15UI/15UJ/15UK/15UL/15UM/15UN/15UO/15UP/15UQ/15UR/15US/15UT/15UU/15UV/15UW/15UX/15UY/15UZ/15VA/15VB/15VC/15VD/15VE/15VF/15VG/15VH/15VI/15VJ/15VK/15VL/15VM/15VN/15VO/15VP/15VQ/15VR/15VS/15VT/15VU/15VV/15VW/15VX/15VY/15VZ/15WA/15WB/15WC/15WD/15WE/15WF/15WG/15WH/15WI/15WJ/15WK/15WL/15WM/15WN/15WO/15WP/15WQ/15WR/15WS/15WT/15WU/15WV/15WW/15WX/15WY/15WZ/15XA/15XB/15XC/15XD/15XE/15XF/15XG/15XH/15XI/15XJ/15XK/15XL/15XM/15XN/15XO/15XP/15XQ/15XR/15XS/15XT/15XU/15XV/15XW/15XX/15XY/15XZ/15YA/15YB/15YC/15YD/15YE/15YF/15YG/15YH/15YI/15YJ/15YK/15YL/15YM/15YN/15YO/15YP/15YQ/15YR/15YS/15YT/15YU/15YV/15YW/15YX/15YY/15YZ/15ZA/15ZB/15ZC/15ZD/15ZE/15ZF/15ZG/15ZH/15ZI/15ZJ/15ZK/15ZL/15ZM/15ZN/15ZO/15ZP/15ZQ/15ZR/15ZS/15ZT/15ZU/15ZV/15ZW/15ZX/15ZY/15ZZ</small>		
ARCHITECT		
GENRE OF DESIGN		
ARCHITECTURE, MASTER PLANNING & INTERIOR DESIGN A-57, BASEMENT FLOOR, SHALUK, MALWIYA NAGAR, NEW DELHI TELEPHONE: 011-40574968		
MEP CONSULTANTS		
C TO C Services Consultants Pvt. Ltd. F-67, - (Basement) Green Park Main, New Delhi-110016 (INDIA) Tel.: 41618888, 41618866 E-mail: ctocinfo@ctocconsultants.com		
STAGE		
DESIGN DEVELOPMENT		
DRAWING TITLE		
5TH FLOOR PLAN ELECTRICAL LAYOUT		
Drawn	Checked	Approved
PK	PARVEEN	TANUJ
Scale	Date	Rev. No.
1:75 @ A1	10.03.2015	RO
Drawing No.		
CTOC.SEPL.1481.EL.08		