


6TH FLOOR

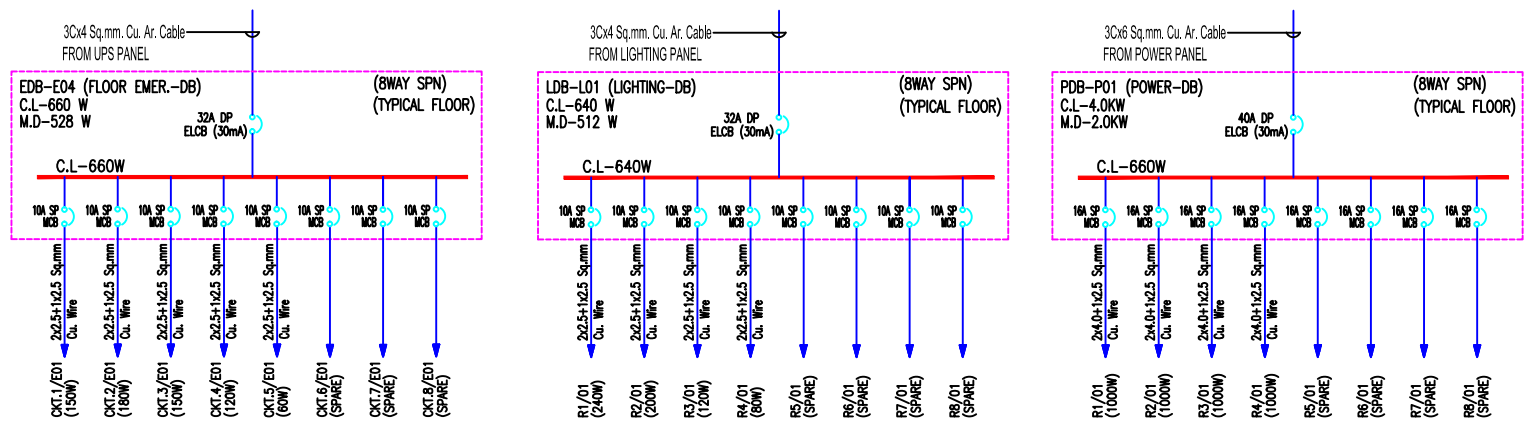

00	—	00/00/00
NO. OF PRINTS	ISSUED TO	DATE
REVISIONS		
PROJECT ORIZZONTE COMMERCIAL PROJECT PLOT NO. 22 SECTOR IT, KP-III GREATER NOIDA		
CLIENT		
FACILITY PLANNER		
STRUCTURAL CONSULTANT		
Konzept Design Consortium PVT. LTD STRUCTURAL ENGINEERS & PROJECT CONSULTANTS <small>Branch: G-22 Plot No. 22-Sector 17, Noida, U.P., India</small>		
ARCHITECT		
GENRE OF DESIGN ARCHITECTURE, MASTER PLANNING & INTERIOR DESIGN A-57, BASEMENT FLOOR, SHALUK, MALVIYA NAGAR, NEW DELHI TELEPHONE: 011-40574968		
MEP CONSULTANTS		
C to C Services Consultants Pvt. Ltd. F-67, (Basement) Green Park Main, New Delhi-110016 (INDIA) Tel.: 41618888, 41618866 E-mail: ctocinfo@ctocconsultants.com		
STAGE		
DESIGN DEVELOPMENT		
DRAWING TITLE		
6TH FLOOR PLAN ELECTRICAL LAYOUT		
Drawn	Checked	Approved
PK	PARVEEN	TANUJ
Scale	Date	Rev. No.
1:75 @ A1	10.03.2015	RO
Drawing No.		
CTOC.SEPL.1481.EL.09		