


PITAMBRA RESIDENCY ELECTRICITY DRAWING



MASTER PLAN
NOT TO SCALE



SAZRA PLAN
NOT TO SCALE

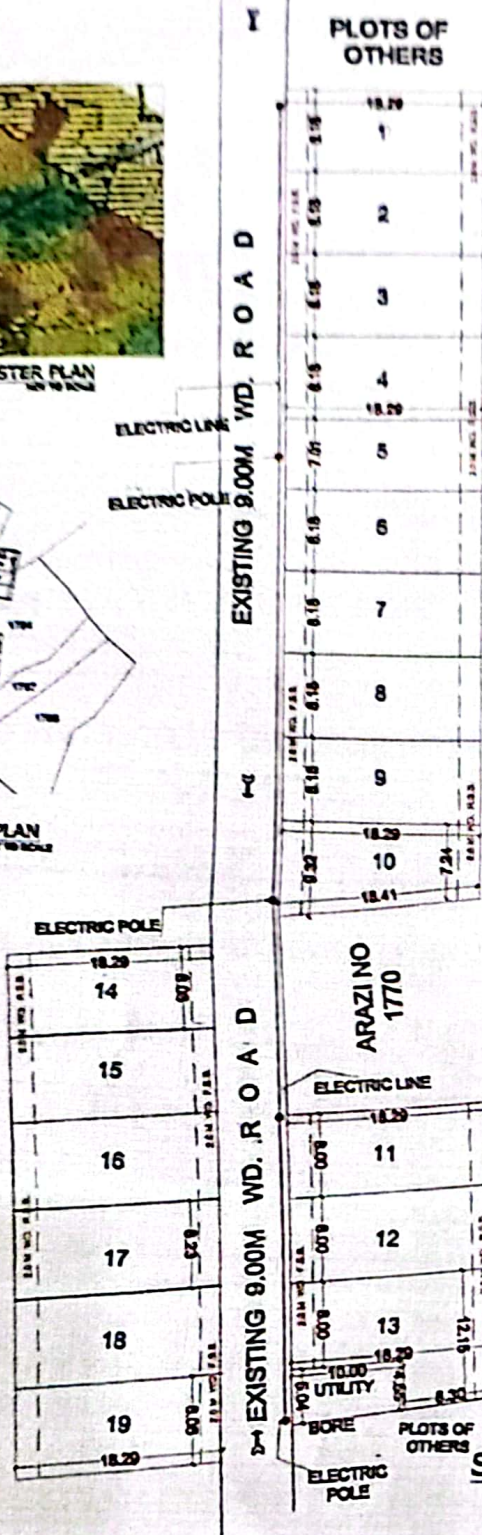


SITE PLAN
SCALE 1:200


LAND OF PITAMBRA ASSOCIATES

LAND OF PITAMBRA ASSOCIATES


ARAZI NO
1770

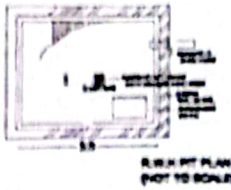

PLAN (NOT TO SCALE)

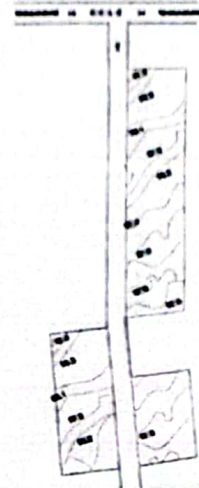

CONTOUR PLAN
NOT TO SCALE

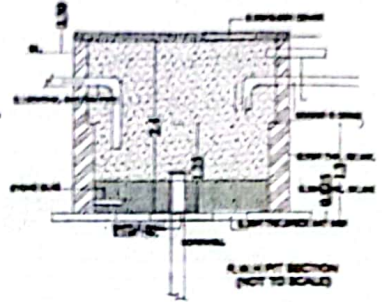

SECTION (NOT TO SCALE)

- LIST OF MATERIALS FOR ELECTRICAL INSTALLATION
1. 1000V SWITCHGEAR
 2. 1000V METER
 3. 1000V METER
 4. 1000V METER
 5. 1000V METER
 6. 1000V METER
 7. 1000V METER
 8. 1000V METER
 9. 1000V METER
 10. 1000V METER
 11. 1000V METER
 12. 1000V METER
 13. 1000V METER
 14. 1000V METER
 15. 1000V METER
 16. 1000V METER
 17. 1000V METER
 18. 1000V METER
 19. 1000V METER
- SITE AT OUT SIDE UNNAO GATE, JHANSI
ARAZI NO-1767, 1768, 1769, 20003, 20004
AT MOLUA JHANSI KHAS JHANSI

AREA DETAIL :

NO.	DESCRIPTION	AREA
1
2
3
4
5

PLOT AREA CALCULATION -

Plot No.	Area
1
2
3
4
5
6
7
8
9
10
11
12
13
14
15
16
17
18
19
TOTAL

SPACE DESIGN INDIA PVT.LTD.
ARCHITECT
Ar. CONRAD GOMES
(Architect)

OFFICE: CLARKS MANOR, 1ST FLOOR, SCHEME NO-4 OFF. APOLLO HOSPITAL, BOBORE
DATE: _____
SCALE: 1:200

OWNER'S SIGN: _____
ARCHITECT'S SIGN: _____

Ar Conrad V Gomes
Conrad Gomes
Council of Architecture
Regd No: CA/96/20529