



GOVT. GREEN AREA

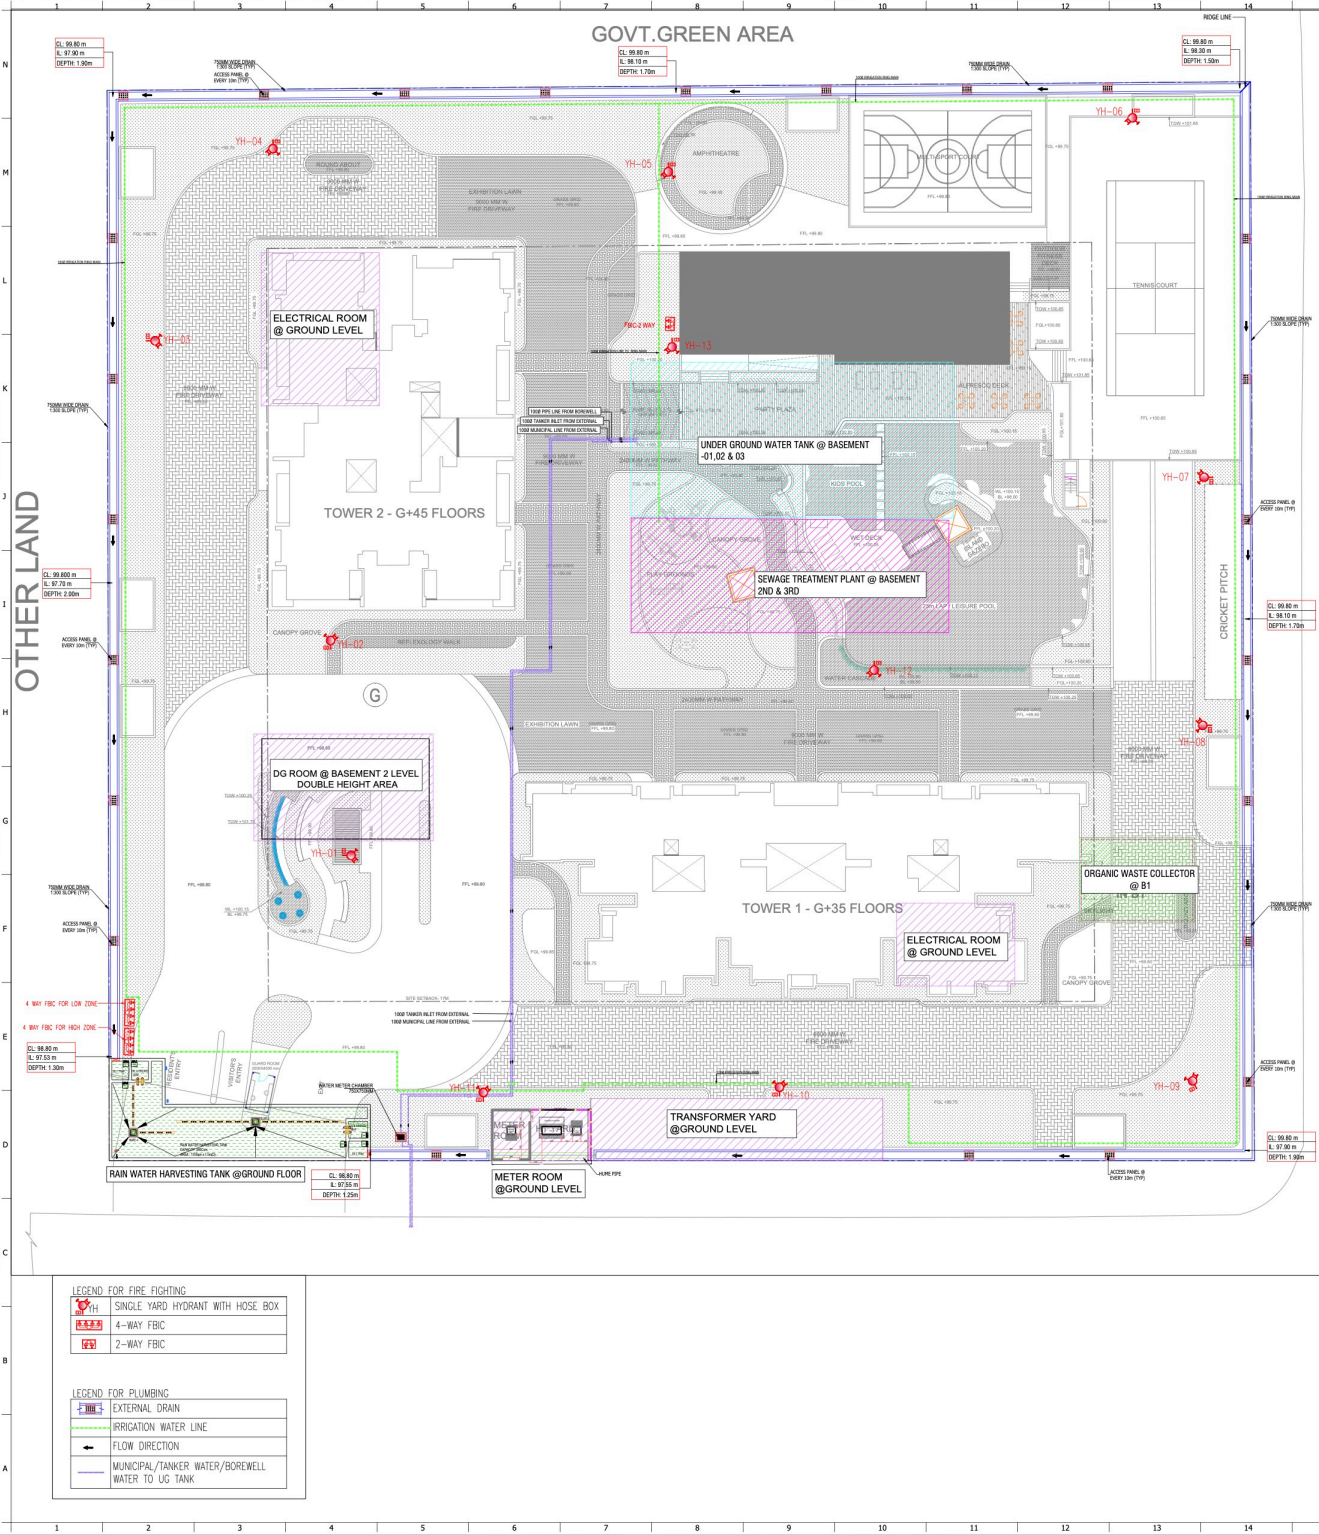

LEGEND FOR FIRE FIGHTING	
	SINGLE YARD HYDRANT WITH HOSE BOX
	4-WAY FBC
	2-WAY FBC

LEGEND FOR PLUMBING	
	EXTERNAL DRAIN
	IRRIGATION WATER LINE
	FLOW DIRECTION
	MUNICIPAL/TANKER WATER/BOREWELL WATER TO UG TANK

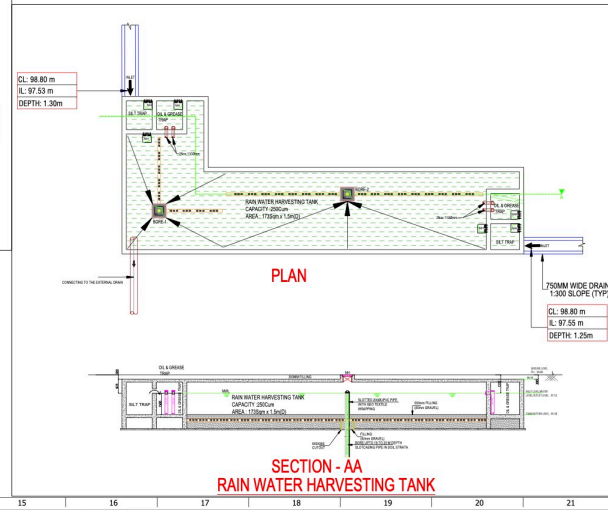

GENERAL NOTES

- ALL WORK SHALL BE IN ACCORDANCE WITH THE LATEST IS/BS CODES.
- ALL DIMENSIONS ARE TO FACE UNLESS SPECIFIED OTHERWISE.
- ALL MATERIALS SHALL BE OF THE BEST QUALITY AVAILABLE IN THE MARKET AT THE TIME OF CONSTRUCTION.
- ALL WORK SHALL BE DONE IN ACCORDANCE WITH THE SPECIFICATIONS AND STANDARDS MENTIONED IN THE CONTRACT DOCUMENTS.

KEY PLAN:

PROJECT: Sobha Aarum
Plot No. 8-205, Sector-35, Greater Noida, Distt. Gautam Budh Nagar, Uttar Pradesh

TITLE: SITE PLAN (DEVELOPMENT PLAN)

DATE: 01.01.2025

SCALE: 1:300

PROJECT CODE: 458

DESIGNED BY: [Name]

CHECKED BY: [Name]

DATE: 01.01.2025

REVISION: [None]

PROJECT CODE: 458

REVISION: [None]

SCALE: 1:300

SHEET: A0

DATE: 01.01.2025

REVISION: [None]