


GARBAGE COLLECTION CENTER

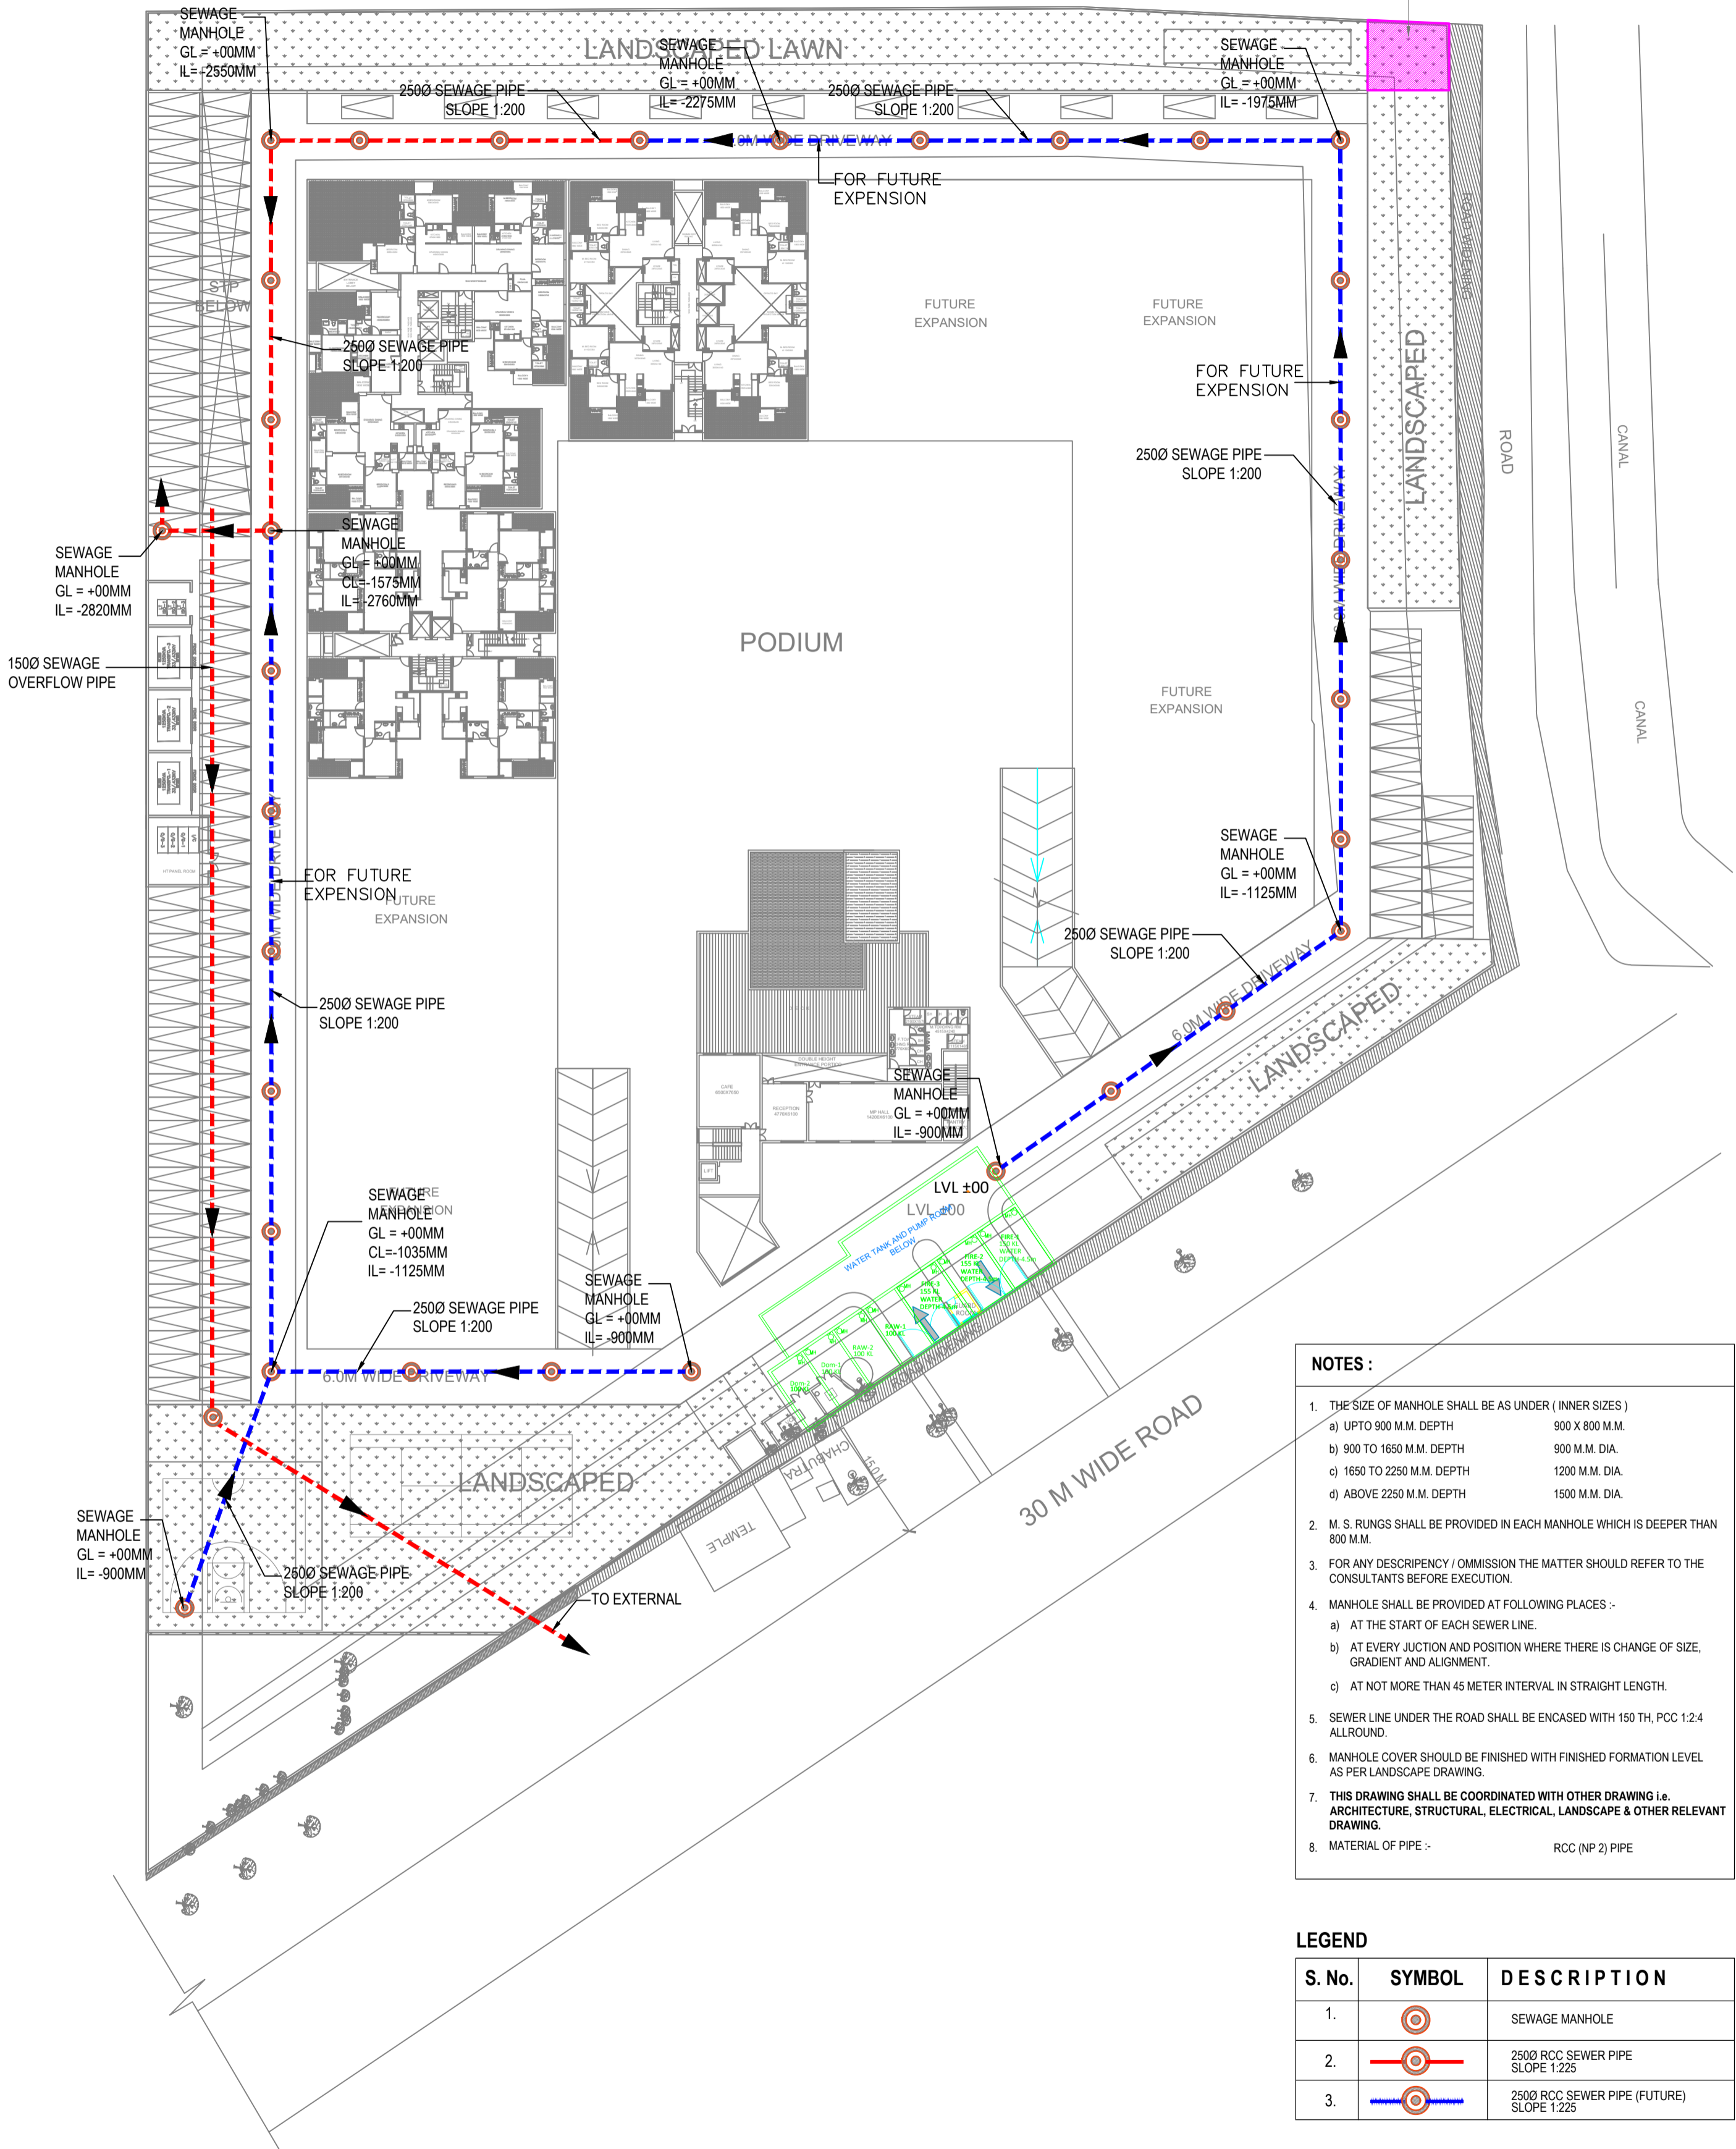

- NOTES :**
- THE SIZE OF MANHOLE SHALL BE AS UNDER (INNER SIZES)

a) UPTO 900 M.M. DEPTH	900 X 800 M.M.
b) 900 TO 1650 M.M. DEPTH	900 M.M. DIA.
c) 1650 TO 2250 M.M. DEPTH	1200 M.M. DIA.
d) ABOVE 2250 M.M. DEPTH	1500 M.M. DIA.
 - M. S. RUNGS SHALL BE PROVIDED IN EACH MANHOLE WHICH IS DEEPER THAN 800 M.M.
 - FOR ANY DESCRIENCY / OMISSION THE MATTER SHOULD REFER TO THE CONSULTANTS BEFORE EXECUTION.
 - MANHOLE SHALL BE PROVIDED AT FOLLOWING PLACES :-
 - AT THE START OF EACH SEWER LINE.
 - AT EVERY JUNCTION AND POSITION WHERE THERE IS CHANGE OF SIZE, GRADIENT AND ALIGNMENT.
 - AT NOT MORE THAN 45 METER INTERVAL IN STRAIGHT LENGTH.
 - SEWER LINE UNDER THE ROAD SHALL BE ENCASED WITH 150 TH, PCC 1:2:4 ALLROUND.
 - MANHOLE COVER SHOULD BE FINISHED WITH FINISHED FORMATION LEVEL AS PER LANDSCAPE DRAWING.
 - THIS DRAWING SHALL BE COORDINATED WITH OTHER DRAWING I.e. ARCHITECTURE, STRUCTURAL, ELECTRICAL, LANDSCAPE & OTHER RELEVANT DRAWING.
 - MATERIAL OF PIPE :- RCC (NP 2) PIPE

LEGEND

S. No.	SYMBOL	DESCRIPTION
1.		SEWAGE MANHOLE
2.		2500 RCC SEWER PIPE SLOPE 1:225
3.		2500 RCC SEWER PIPE (FUTURE) SLOPE 1:225

<p>PROJECT: RUDRA GARDENIA , SINGH PUR KACHHAR, PARGANA-TEHSIL KANPUR SADAR, KANPUR NAGAR, UTTAR PRADESH</p>	<p>CLIENTS TERRIFIC REAL ESTATE</p>	<p>DATE 07.07.2023</p>	<p>ARCHITECTS SPACE DESIGN GROUP ARCHITECTS AND INTERIOR DESIGN CONSULTANTS W-139, F.F, GREATER KAILASH-I, NEW DELHI - 48 TELE: 41631265, 29233752 FAX: 29240732 email: spacedesigngroup@gmail.com</p>
<p>DRAWING TITLE: SITE PLAN SEWAGE LAYOUT AND GARBAGE LOCATION</p>	<p>DEALT SK</p>	<p>SCALE 1:500 @A2</p>	<p>DRG NO PL-SL-01</p>