

THIS DRAWING IS THE PROPERTY OF THE DERA AND SHALL NOT BE COPIED OR USED IN ANY MANNER WITHOUT PRIOR PERMISSION.

**REVISIONS OF DRAWINGS**

MARK	DATE	DESCRIPTION

**GENERAL NOTES**

- ALL DIMENSIONS ARE IN MM UNTIL OR UNLESS SPECIFIED
- ALL ARCHITECTURE & STRUCTURE DRAWINGS TO BE READ TOGETHER ALONG WITH ALL SERVICE DETAIL DRAWING
- ALL DIMENSION MUST BE CHECKED ON SITE & WITH OTHER DRAWING BEFORE EXECUTION
- DRAWING NOT TO BE SCALED, ONLY MENTIONING DIMENSION TO BE FOLLOWED.
- ANY DISCREPANCY, IF FOUND IN DRAWING OR ON SITE, THE SAME WILL BE INFORMED TO CONSULTANTS OR ENGINEER IN CHARGE FOR PROPER CLARIFICATION

**PLUMBING LEGEND**

S.No	Symbol	Symbol	Description
1			110MM SOIL PIPE RING FIT TYPE OF SLOPE 1:100
2			90MM WASTE PIPE FIT TYPE OF SLOPE 1:80
3			38MM FRESH WATER PIPE

**PROJECT DETAILS**

**CLIENT**  
 Shri Raghav Agrawal S/O Shri Ram Agrawal  
 R/O. 1349 SAHAGANI DARWAJA PLOT NO. 1314 JAI SHRI COLONY MASANI ROAD MATHURA

**ARCHITECT CONSULTANT**  
**DERA Consultants Pvt. Ltd.**  
 30B, GEETA ENCLAVE, KRISHNA NAGAR, MATHURA 281004  
 Tel : +91-8909871654, Email : office@dera.co.in

(Authorised Signatory with Stamp)

**PROJECT TITLE**  
**SHRI VRINDA ENCLAVE**


**DRAWING TITLE**  
 PLUMBING DETAIL GROUND FLOOR PLAN SITE PLAN

**DRAWING PURPOSE**  
 FOR APPROVAL

SCALE-	REVISION	DATE OF ISSUE-

DWG. NO.- **PL-101**

SHEET SIZE	SHEET NO-
-A1	
DRAWN BY <b>HB</b>	CHECKED BY <b>DD</b>

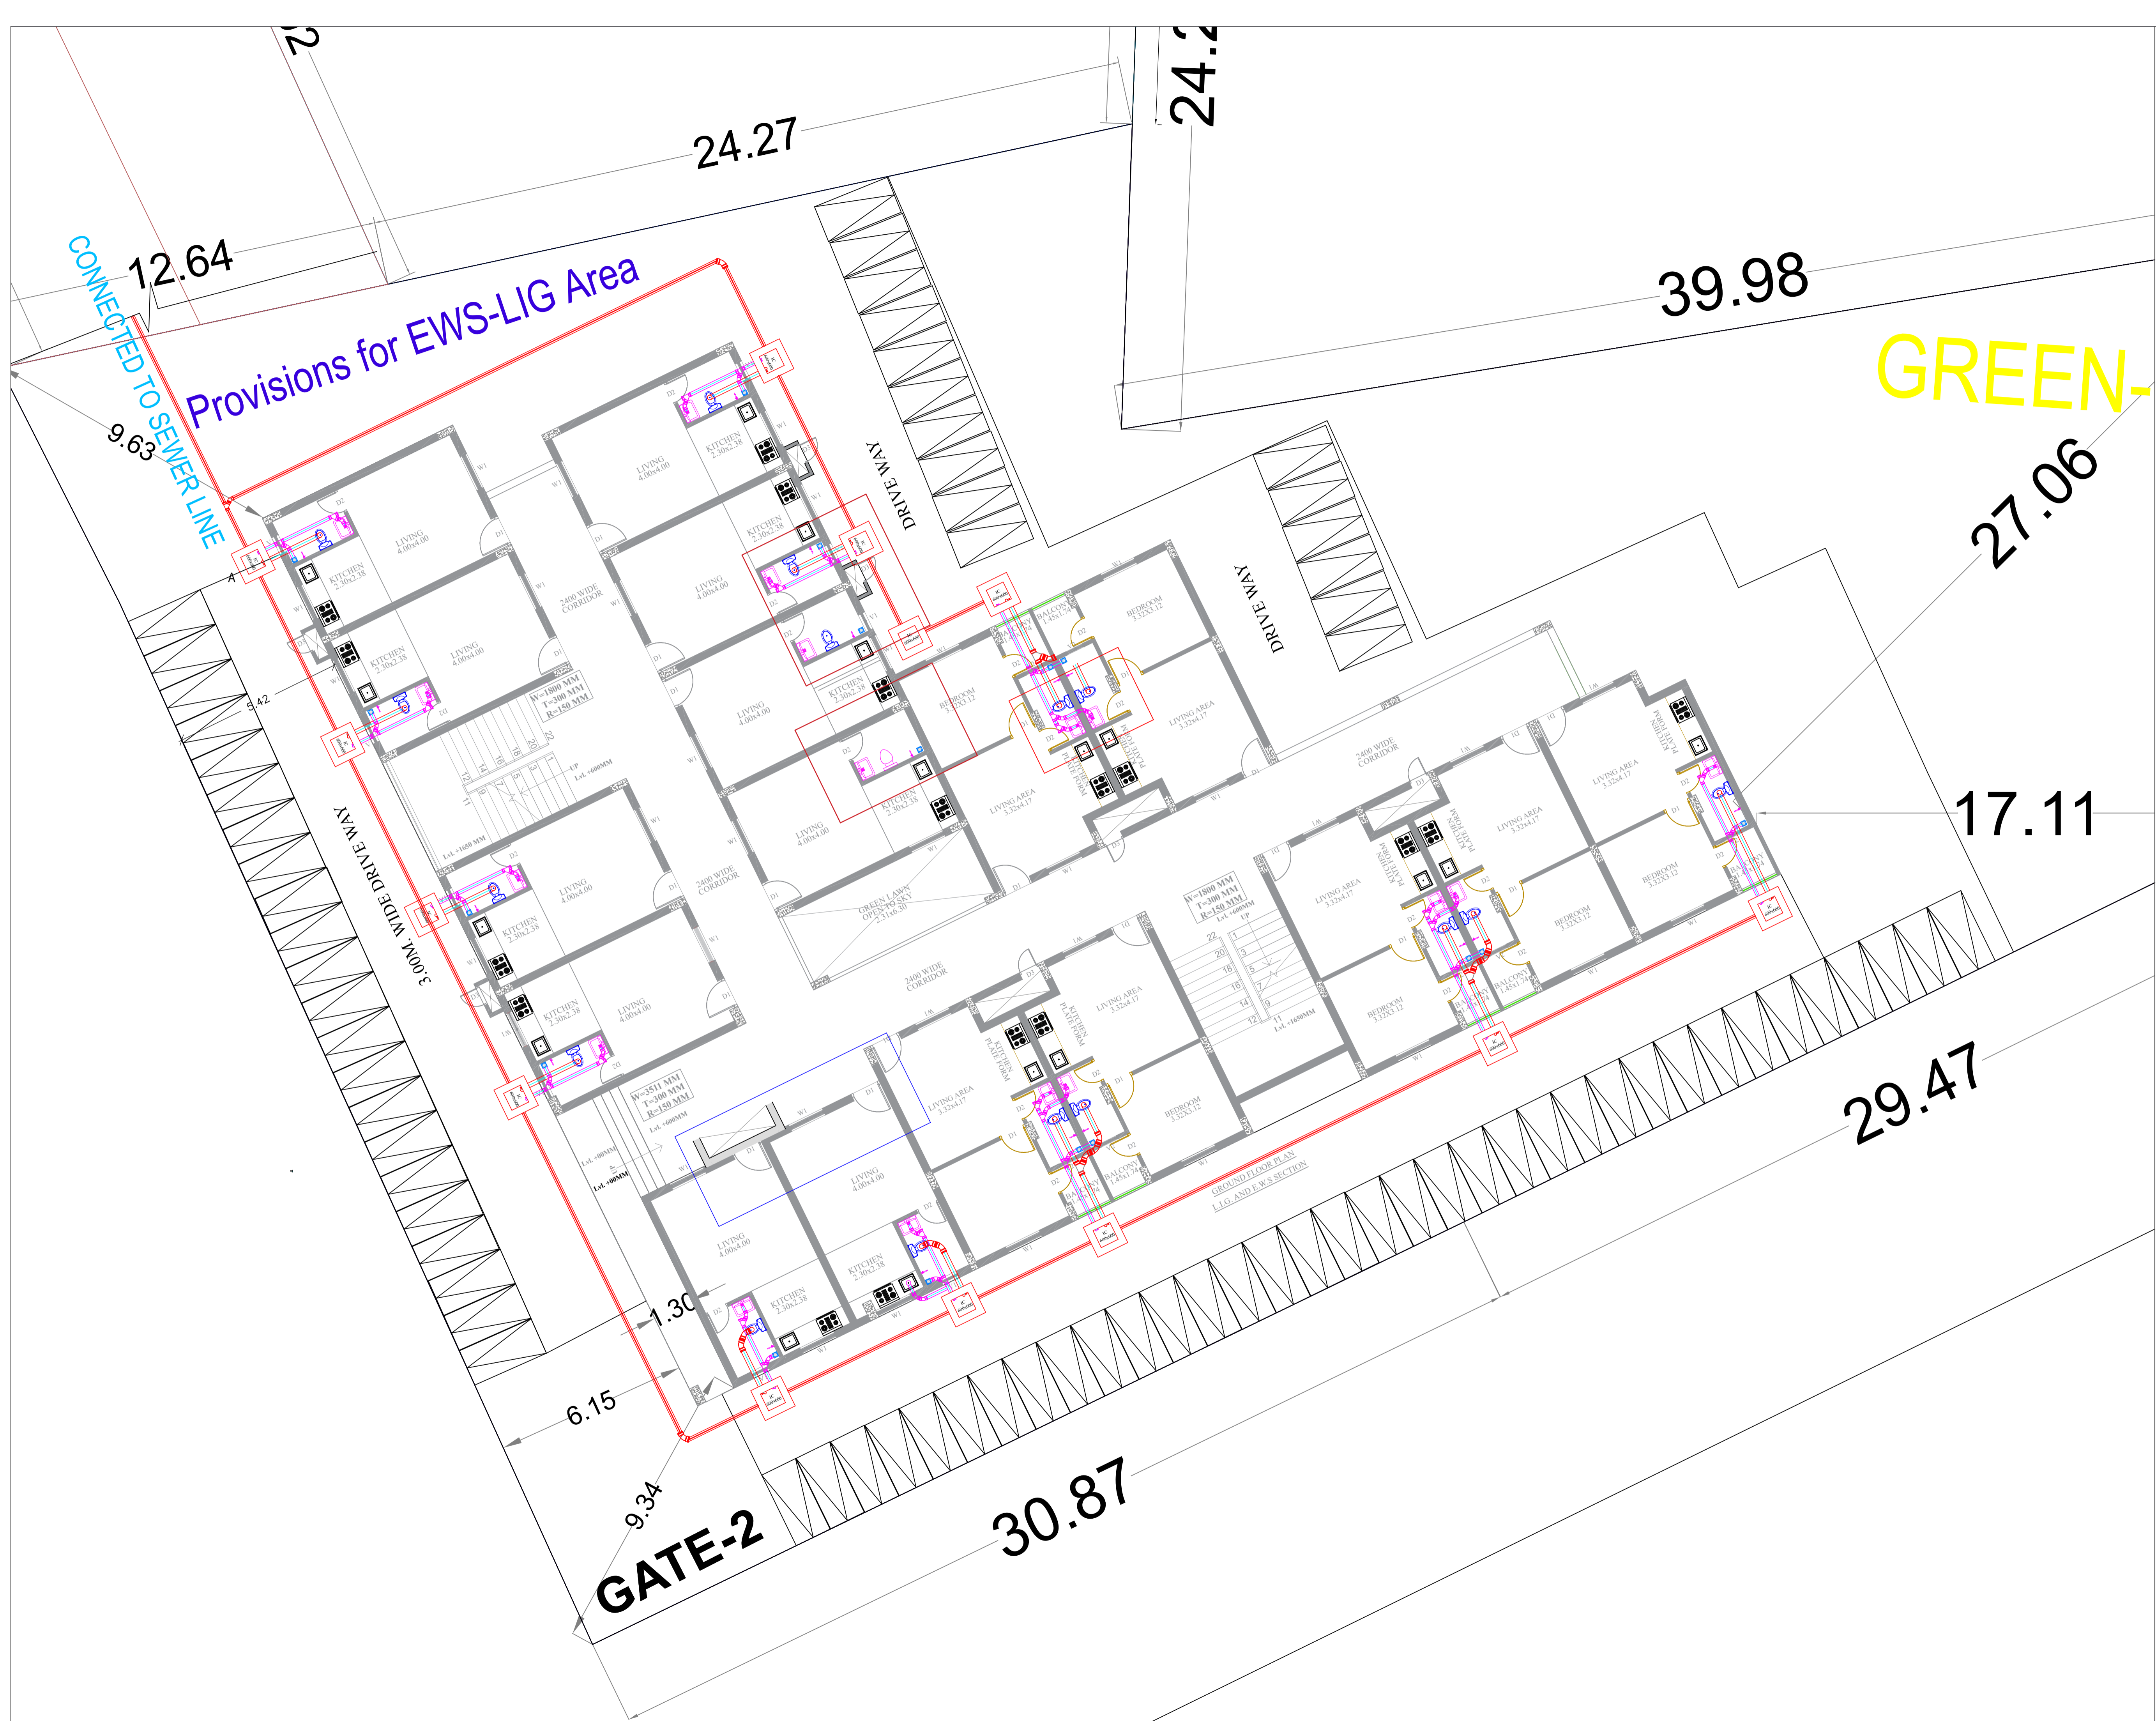

**GREEN**