


LEGEND FOR WATER SUPPLY	
	GARDEN HYDRANT
	BALL VALVE / BUTTER FLY VALVE
	NON-RETURN VALVE
	DOMESTIC WATER SUPPLY LINE
	FLUSHING WATER SUPPLY LINE
	IRRIGATION LINE

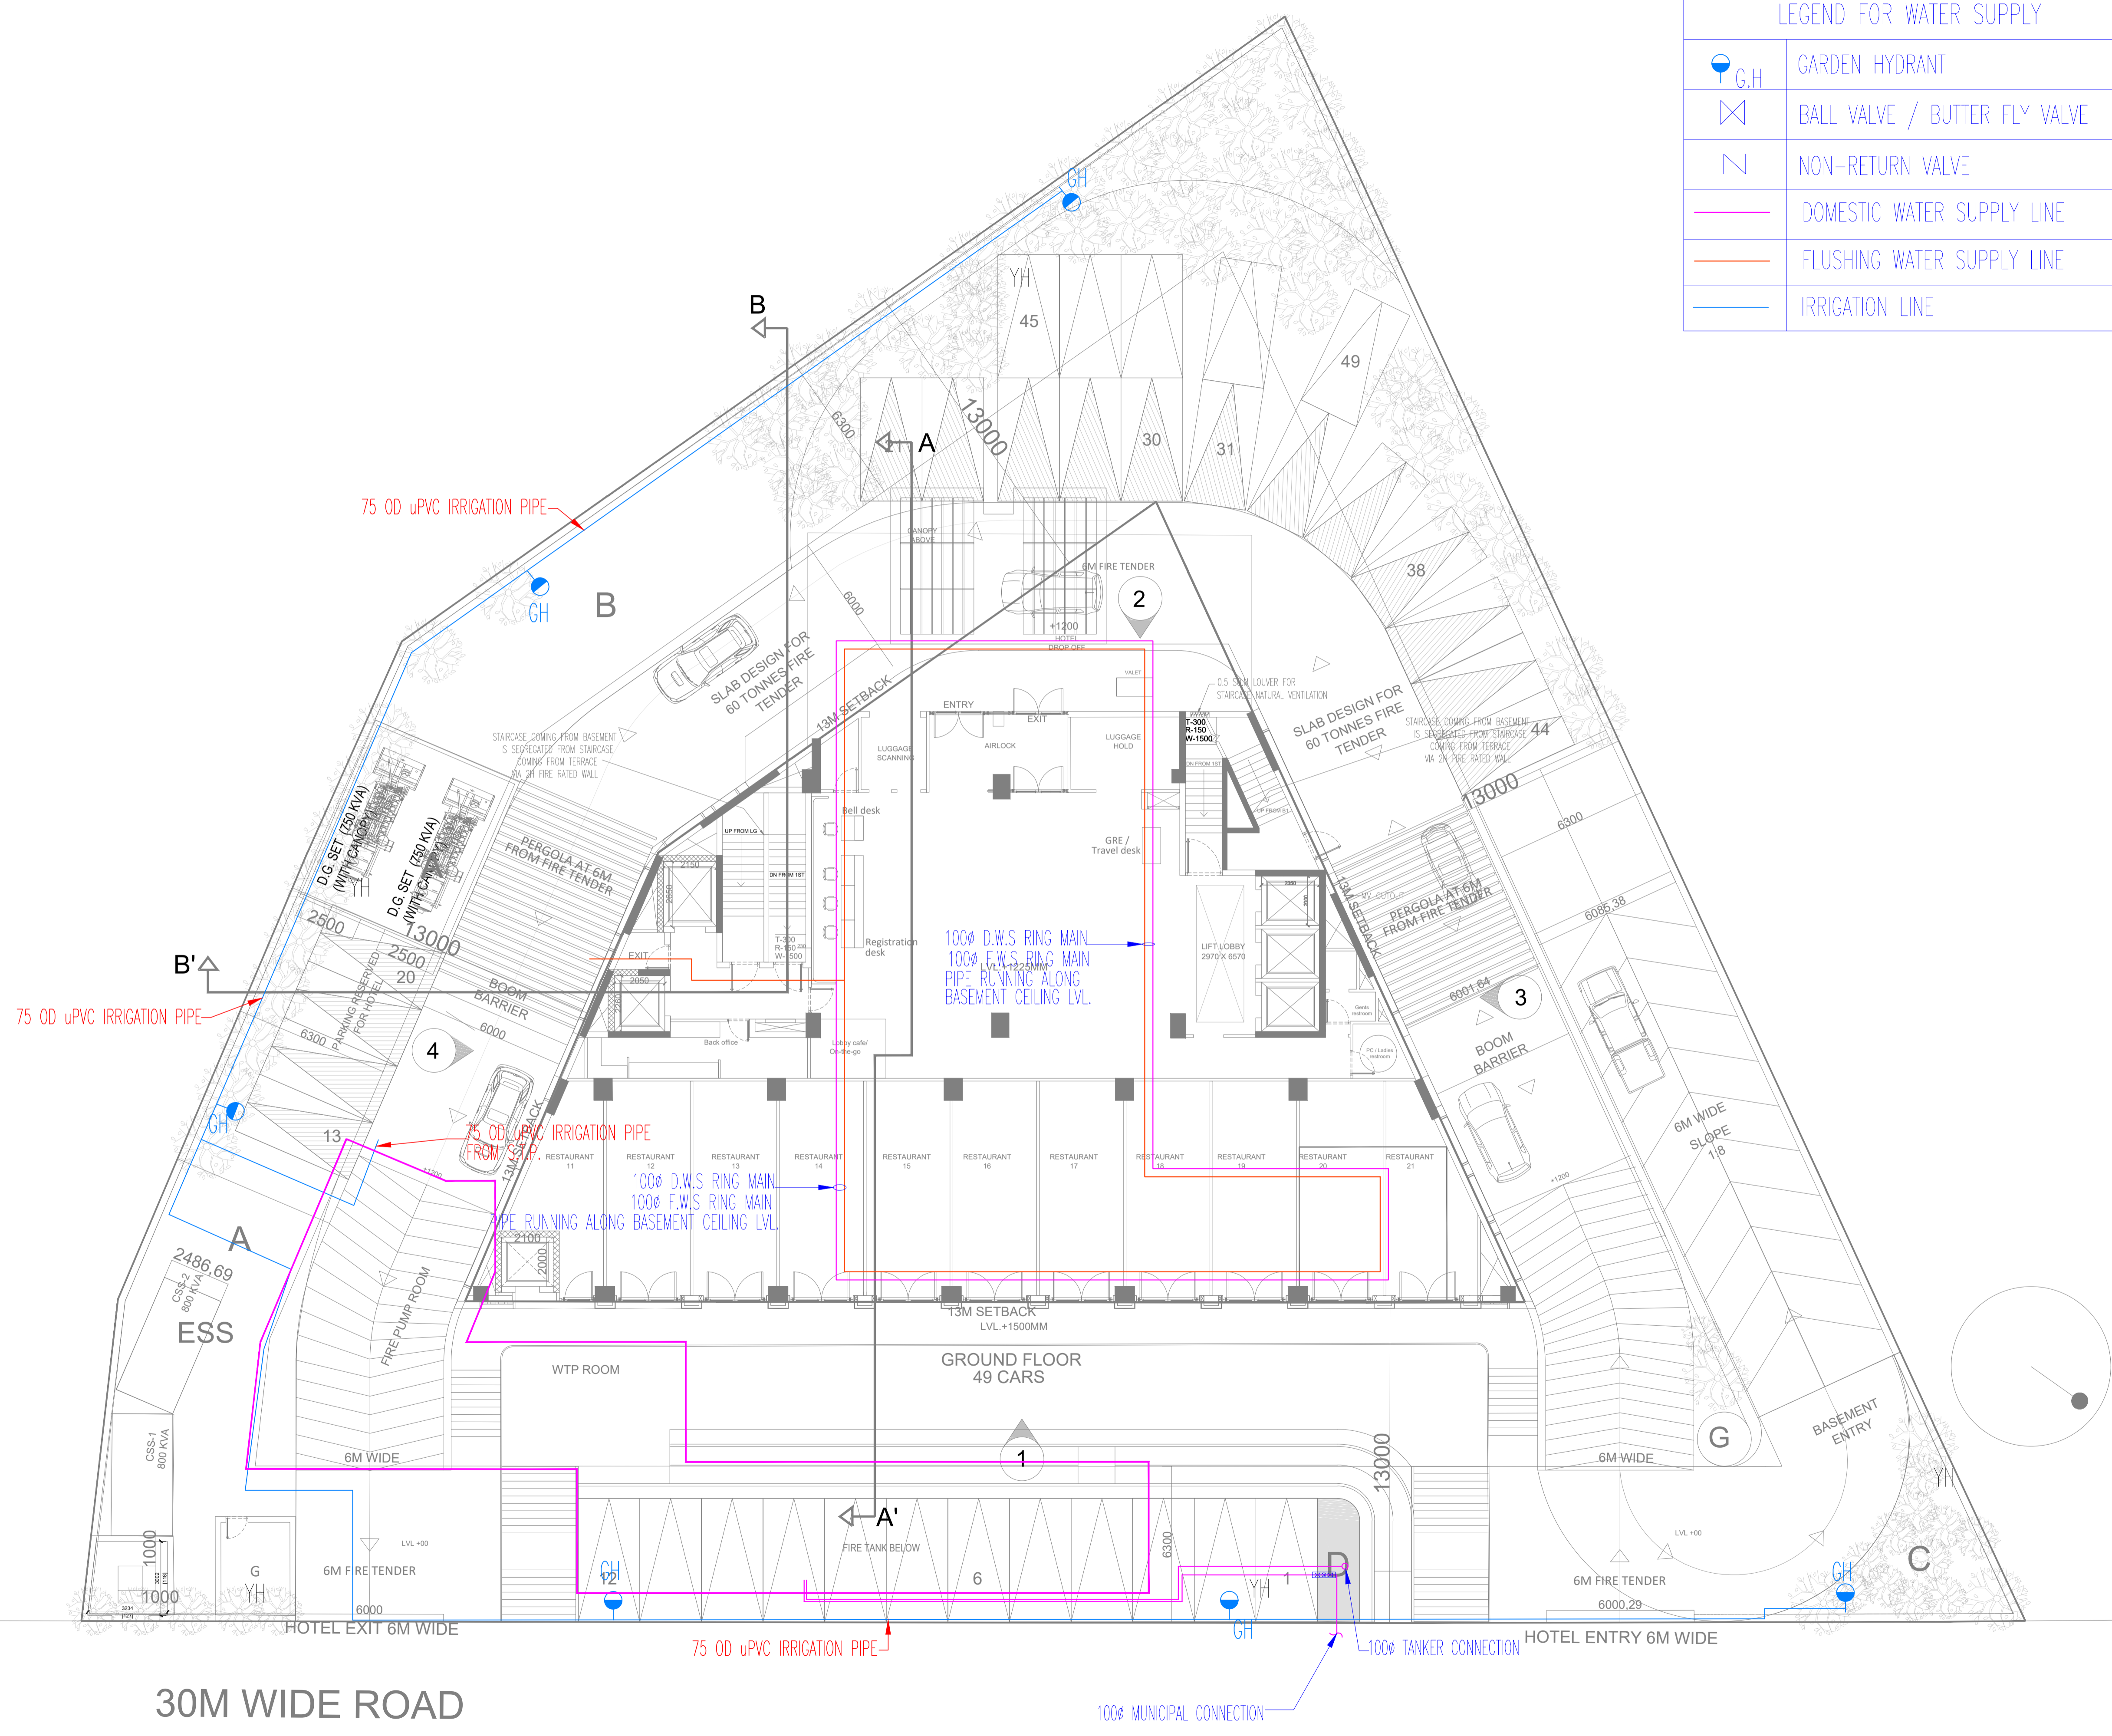

OWNER SIGN	ARCHITECT SIGN	
OWNER M/S ADVIKA BUILDTech LLP		
SUBMISSION DRAWING		
KEY PLAN		
PROJECT PROPOSED COMMERCIAL CUM HOTEL PROJECT "VEDA" AT KHASRA NO 228,229,230 KUDA KESHAVPUR,DARSHAN NAGAR AYODHYA		
DATE	PROJECT INCH.	CHECKED BY
SCALE 1:125@A1	DEALT BY	APPROVED BY
DRAWING TITLE SITE PLAN WATER SUPPLY LAYOUT		
CONSULTANTS B-50, Basement, Soami Nagar New Delhi-110017 Tel No: 011-49848197 & 49849205 Consulting Email: info@vconconsulting.co.in		
ARCHITECTS Confluence NEW DELHI, INDIA F-1, FIRST FLOOR, MIRA CORPORATE SUITES, ISHWAR NAGAR, NEW DELHI 110065 Ph: +91-11-26925684 ccs@confluence.com Member of ISBC Ph: +91-11-49547488 www.confluence.com ISO - 9001:2000 architecture urban design hospitality interiors		
DRAWING NO.	REVISION	