


LEGEND FOR PLUMBING	
	IRIGATION LINE
	1500 MS FIRE RING MAIN
	F.B.C FIRE BRIGADE CONNECTION
	Y.H YARD HYDRANT
	B.V BALL VALVE / BUTTER FLY VALVE
	NO-RETURN VALVE

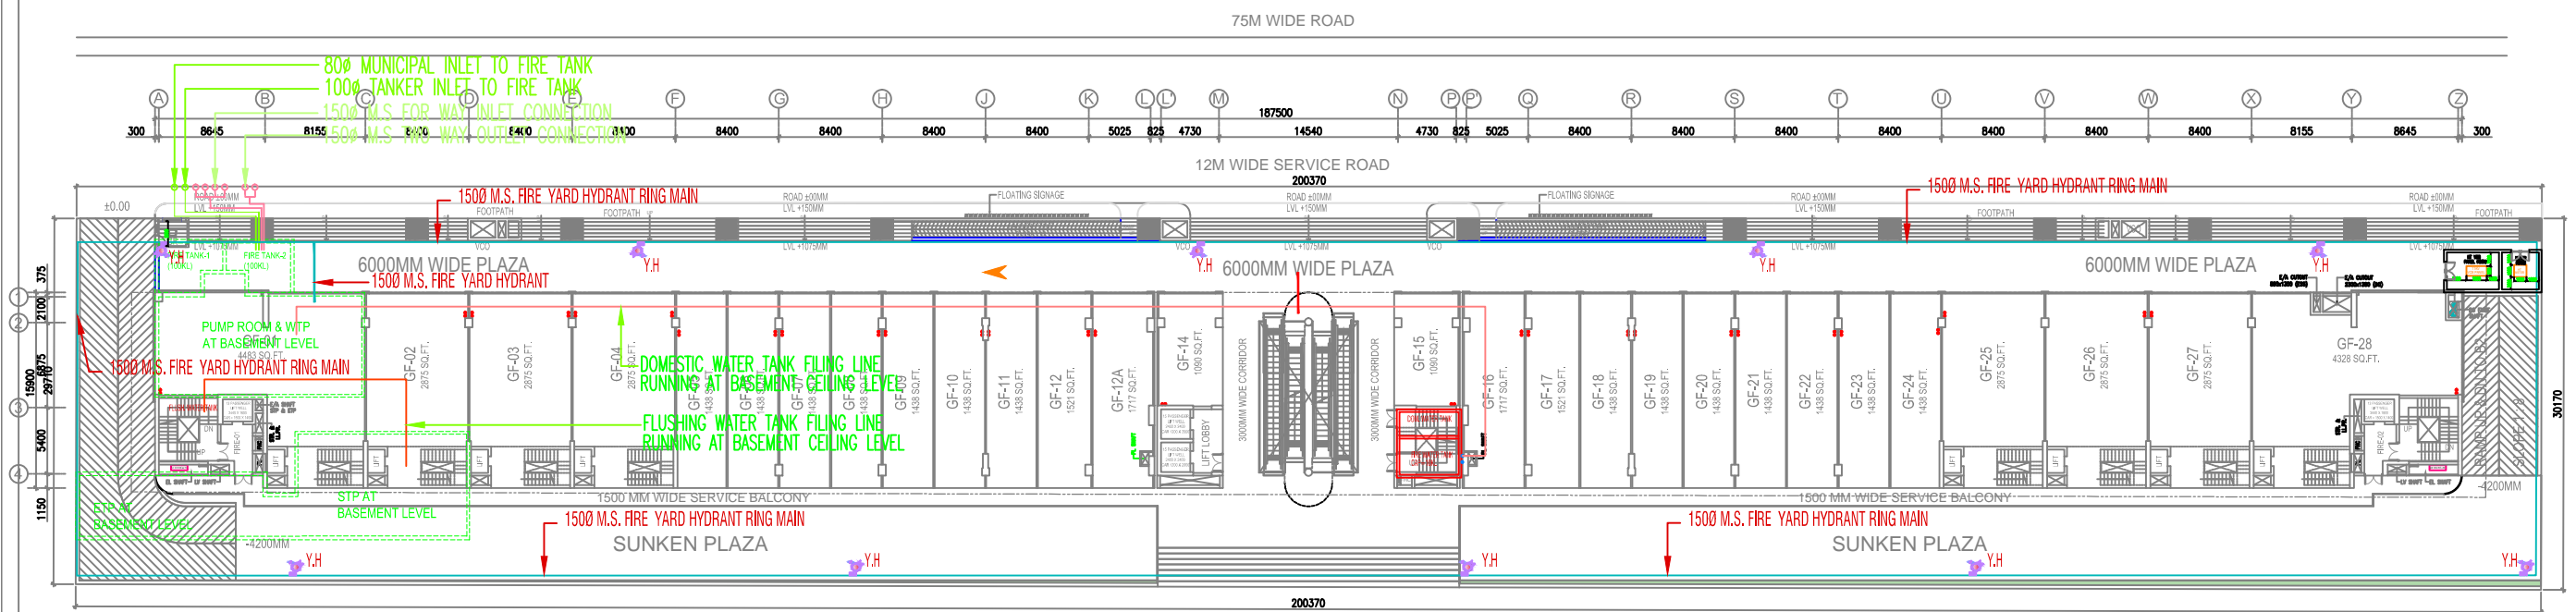

**GROUND FLOOR PLAN (+1200)**

**NOTES:-**

1. ALL DIMENSIONS ARE IN MM.
2. ALL DIMENSIONS ARE TO BE READ AND NOT MEASURED.
3. ANY DISCREPANCIES MUST BE BROUGHT TO THE NOTICE OF THE CONSULTANT BEFORE EXECUTION OF WORK AT SITE.
4. THIS DRAWING MUST BE READ IN CONJUNCTION WITH ALL RELEVANT ARCHITECTURAL, STRUCTURAL, PLUMBING, FIRE FIGHTING AND ELECTRICAL DRAWINGS.
5. THIS DRAWING IS THE SOLE PROPERTY OF MODARCHINDIA. IT SHOULD NOT BE USED/COPIED/REPRODUCED IN ANY MANNER WITHOUT THE PRIOR PERMISSION OF MODARCHINDIA.
6. ARCHITECTURAL DRAWING SHOULD BE FOLLOWED FOR ALL DIMENSIONS & LEVELS.

**STRUCTURE CONSULTANT :-**

**VINECH**  
CONSULTANTS  
CONSULTING ENGINEERS  
& PROJECT MANAGERS  
C-96, PAMPORE ENCLAVE  
GATE NO. 3/3/4E - 1 NEW DELHI - 110048  
TEL: 48141814, 48141815 FAX: 48141777  
e-mail: info@vinechconsultants.co.in

**MEP CONSULTANT:-**

**V**  
Consulting  
B-50, Basement, Soami Nagar  
New Delhi-110017  
Tel No: 011-49848197 & 49849205  
Email: info@vconsulting.co.in

**PROJECT:-**

PROPOSED COMMERCIAL BUILDING AT  
PLOT NO.COMM.-04, SECTOR-50,  
NOIDA (U.P.)

 
**OWNER:-**

M/S WESTWAY CITY CENTRE LLP  
NOIDA

**ARCHITECT:-**

**modarchindia**  
architects interior designers & planners  
studio: 1st floor, B-99, sector-63, Noida -201301, U.P.  
phone: 0120-4206253, email: amitgargal@hotmail.com  
website: www.modarch.in

**KEY PLAN**



SCALE: - N.T.S

**DRAWING TITLE:-**

**SITE PLAN**  
**WATER SUPPLY & FIRE LAYOUT**

CHECKED BY	V.N.	DRAWN BY	A.B.
APPROVED BY	V.N.	DATE:-21/08/2023	SCALE:- 1:250
DRAWING NO.-MIS/TE01			REVISION- RD