


THIS DRAWING IS THE PROPERTY OF THE DERA AND SHALL NOT BE COPIED OR USED IN ANY MANNER WITHOUT PRIOR PERMISSION.

REVISIONS OF DRAWINGS		
MARK	DATE	DESCRIPTION

- GENERAL NOTES**
1. ALL DIMENSIONS ARE IN MM UNLESS OTHERWISE SPECIFIED
 2. ALL ARCHITECTURE & STRUCTURE DRAWINGS TO BE READ TOGETHER, ALONG WITH ALL SERVICE DETAIL DRAWING
 3. ALL DIMENSION MUST BE CHECKED ON SITE & WITH OTHER DRAWING BEFORE EXECUTION
 4. DRAWING NOT TO BE SCALED, ONLY MENTIONING DIMENSION TO BE FOLLOWED
 5. ANY DISCREPANCY, IF FOUND IN DRAWING OR ON SITE THE SAME WILL BE INFORMED TO CONSULTANTS OR ENGINEER IN CHARGE FOR PROPER CLARIFICATION

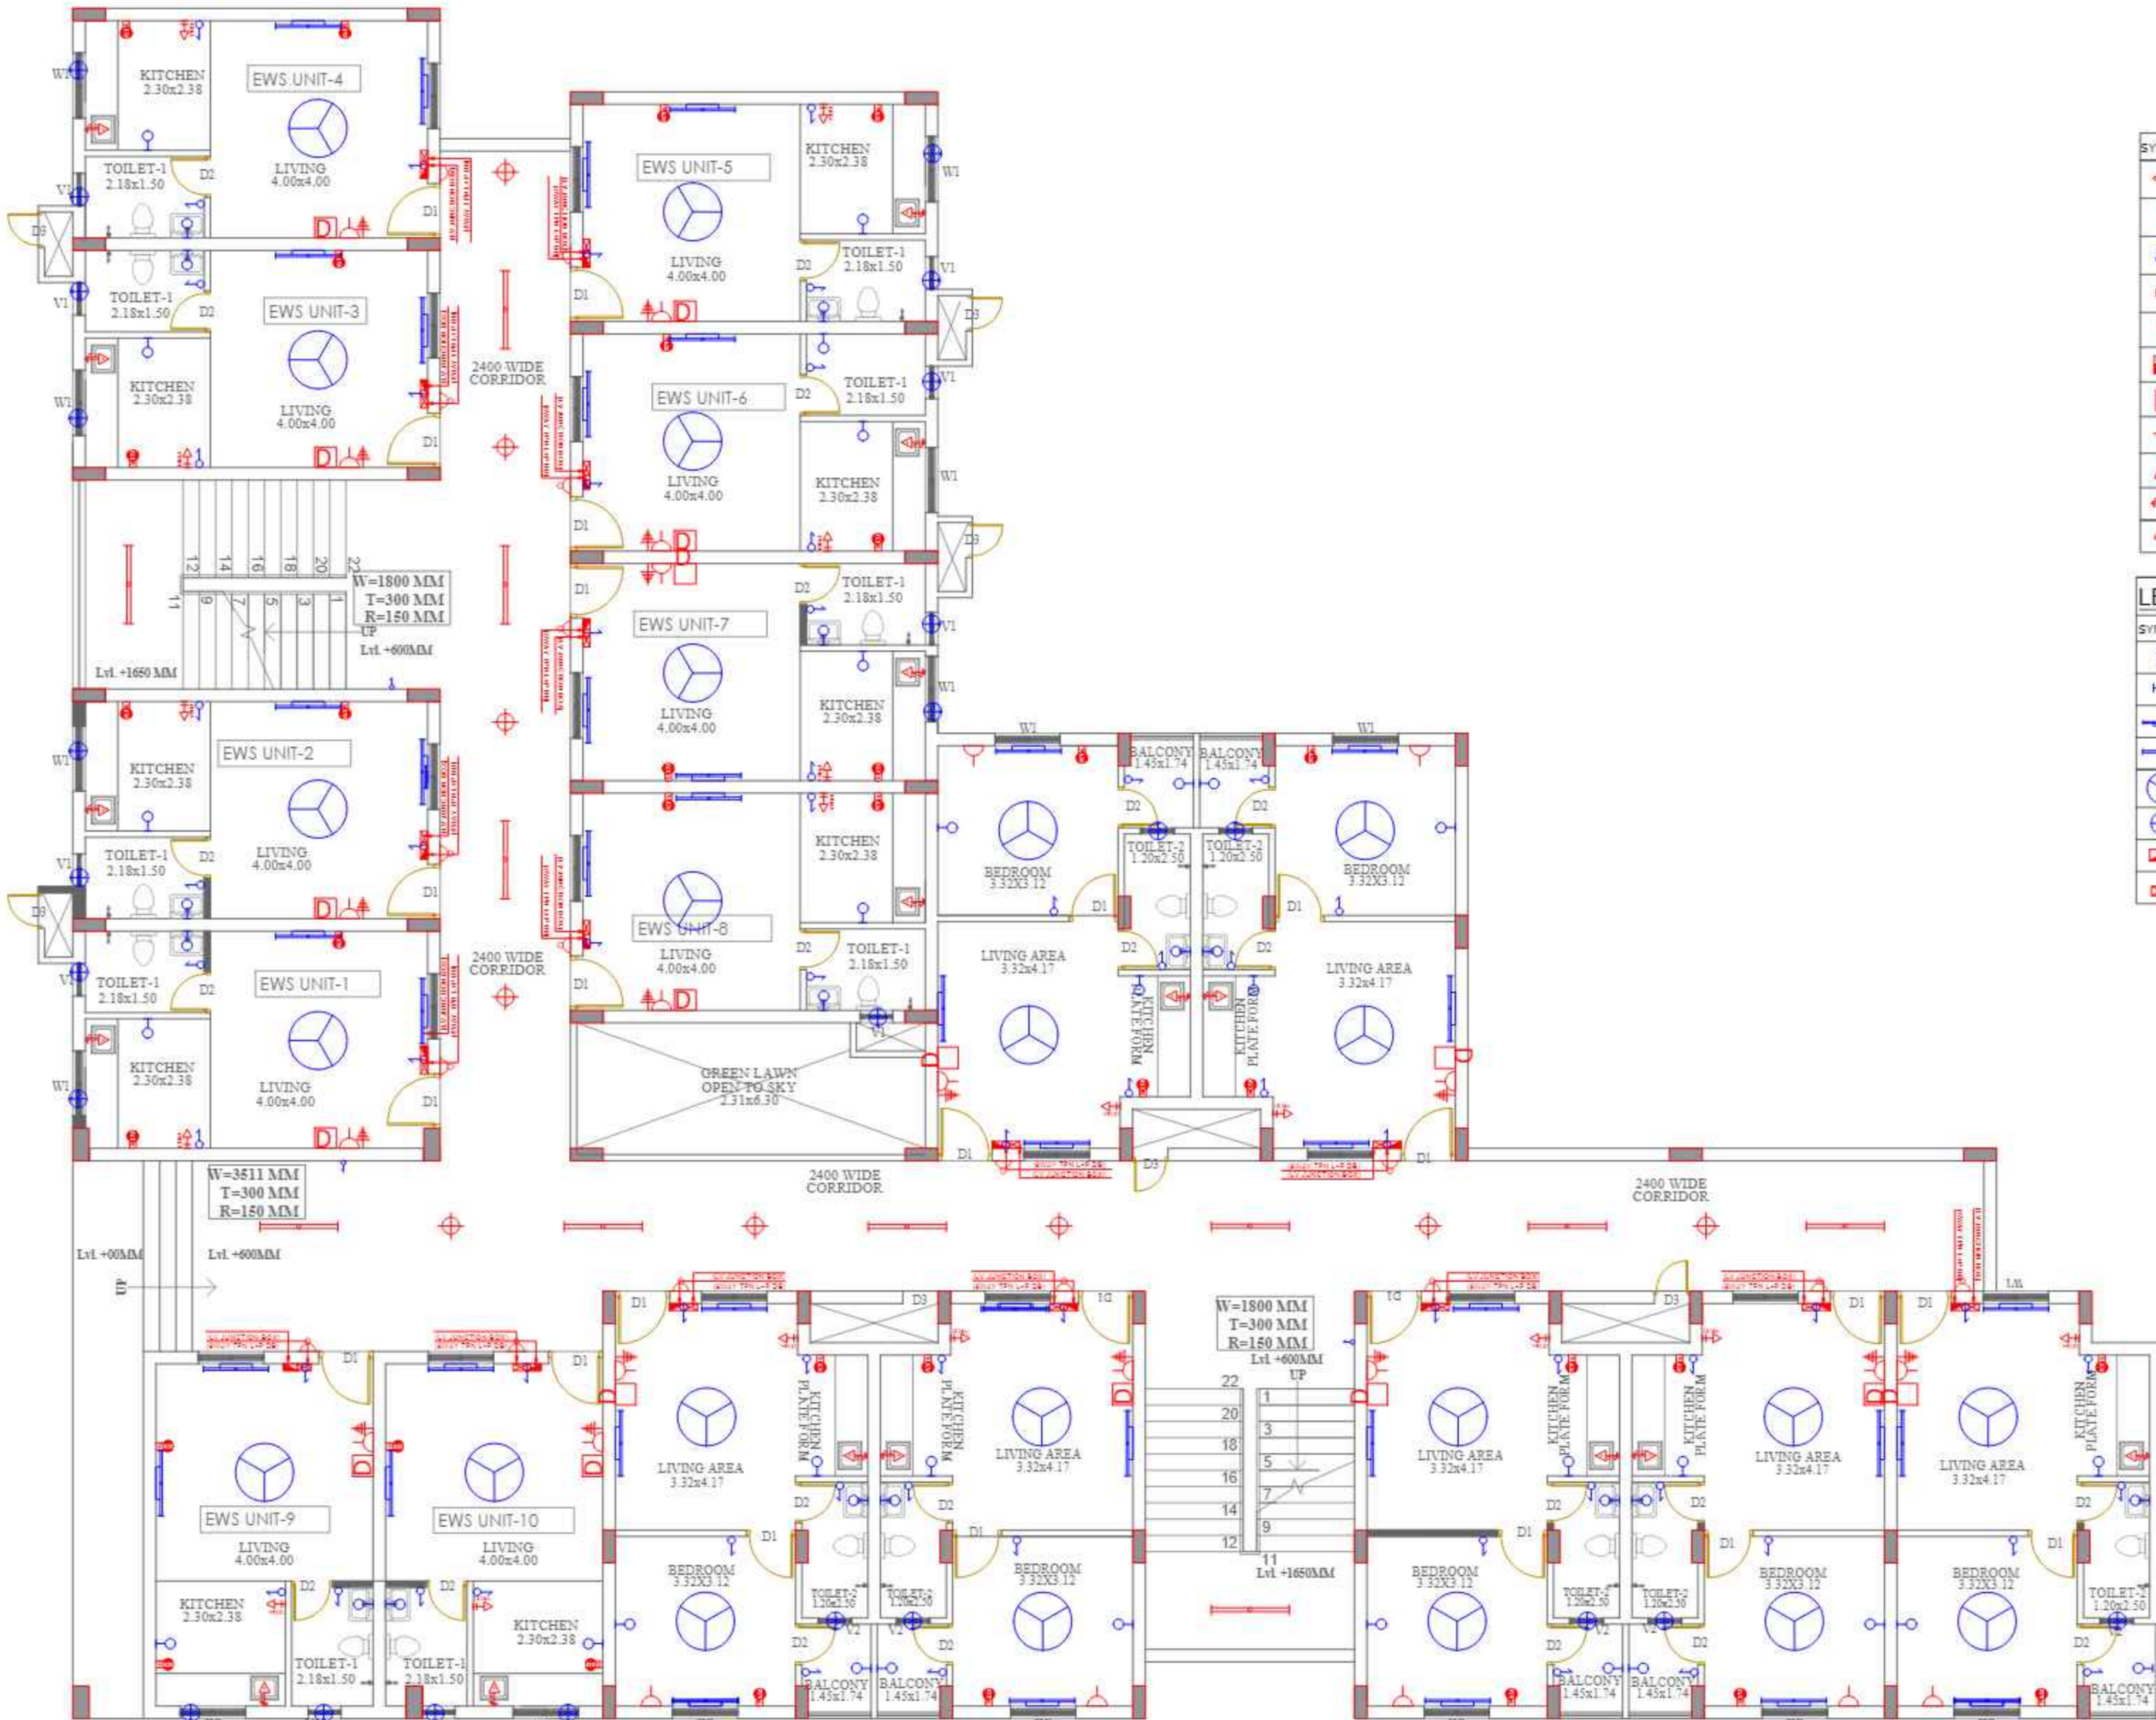

LEGENDS :

SYMBOL	DESCRIPTION	HEIGHT IN FLOOR FINISH LVL.
⚡	15-25A POWER PLUG POINT FOR AC UNIT	450MM
⚡	15/16A POWER PLUG POINT	450MM
📞	TELEPHONE OUTLET	450MM
⚡	15/16A POWER PLUG POINT IN KITCHEN	900MM
⚡	DATA	
⚡	15/16A POWER PLUG POINT FOR GEYSER	2250MM
⚡	5/6A LIGHT PLUG POINT FOR TV	1200MM
📺	TELEVISION POINT	1200MM
⚡	5/6A LIGHT PLUG POINT	450MM
⚡	5/6A LIGHT PLUG POINT FOR RD	1800MM
🔔	BELL	2250MM

LEGENDS :

SYMBOL	DESCRIPTION	HEIGHT IN FLOOR FINISH LVL.
⚡	SWITCH BOARD	1050MM
🔌	BATTEN HOLDER WITH 20W LED BULB	2250MM
🔌	20W LED WALL MOUNTED TUBE LIGHT	2250MM
🔌	20W LED CEILING MOUNTED TUBE LIGHT	CEILING
🌀	CEILING FAN 1200MM	CEILING
🌀	EXHAUST FAN 200mm	AS/PER WINDOW
🔌	DISTRIBUTION BOARD	1500MM
🔌	LV JUNCTION BOX	2250MM

GROUND FLOOR PLAN
L.I.G. AND E.W.S SECTION

PROJECT DETAILS

CLIENT
Shri Raghav Agrawal S/O Shri Ram Agrawal
R/O : 1249 SARAGANU DARWAZA PLOT NO. 1214 1A1 SHRI COLONY MAHANTI ROAD MATURGA

ARCHITECT CONSULTANT
DERA Consultants Pvt. Ltd.
308, GEETA ENCLAVE, KRISHNA NAGAR, MATHURA-201004
Tel : +91-9909071654, Email : office@dera.co.in
(Authorised Signatory with Stamp)

PROJECT TITLE
SHRI VRINDA ENCLAVE

DRAWING TITLE
GROUND FLOOR PLAN

DRAWING PURPOSE
FOR APPROVAL

SCALE- 1:100	REVISION	DATE OF ISSUE- 31/01/2023
-----------------	----------	------------------------------

DWG NO.-
EL-101 FLOOR PLAN

SHEET SIZE	SHEET NO.- 01/05
DRAWN BY HG	CHECKED BY DD

THIS DRAWING IS THE PROPERTY OF THE DERA AND SHALL NOT BE COPIED OR USED IN ANY MANNER WITHOUT PRIOR PERMISSION.

REVISIONS OF DRAWINGS		
MARK	DATE	DESCRIPTION

GENERAL NOTES

1. ALL DIMENSIONS ARE IN MM UNLESS OTHERWISE SPECIFIED
2. ALL ARCHITECTURE & STRUCTURE DRAWINGS TO BE READ TOGETHER, ALONG WITH ALL SERVICE DETAIL DRAWING
3. ALL DIMENSIONS MUST BE CHECKED ON SITE & WITH OTHER DRAWING BEFORE EXECUTION
4. DRAWING NOT TO BE SCALED, ONLY MENTIONING DIMENSION TO BE FOLLOWED
5. ANY DISCREPANCY, IF FOUND IN DRAWING OR ON SITE THE SAME WILL BE INFORMED TO CONSULTANTS OR ENGINEER IN CHARGE FOR PROPER CLARIFICATION

PROJECT DETAILS

CLIENT
 Shri Raghav Agrawal S/O Shri Ram Agrawal
 R/O : 1249 SARAGANU DARWAZA PLOT NO. 1214 1st STAGE COLONY MAHANTI ROAD MATURGA

ARCHITECT CONSULTANT
DERA Consultants Pvt. Ltd.
 308, GEETA ENCLAVE, KRISHNA NAGAR, MATHURA-281004
 Tel : +91-9909071654, Email : office@dera.co.in
 (Authorised Signatory with Stamp)


PROJECT TITLE
SHRI VRINDA ENCLAVE

DRAWING TITLE
FIRST FLOOR PLAN

DRAWING PURPOSE
FOR APPROVAL

SCALE:- 1:100 REVISION DATE OF ISSUE- 31/01/2023
 DWG NO.- EL-102 FLOOR PLAN

SHEET SIZE -A1 SHEET NO- 02/05
 DRAWN BY HG CHECKED BY DD

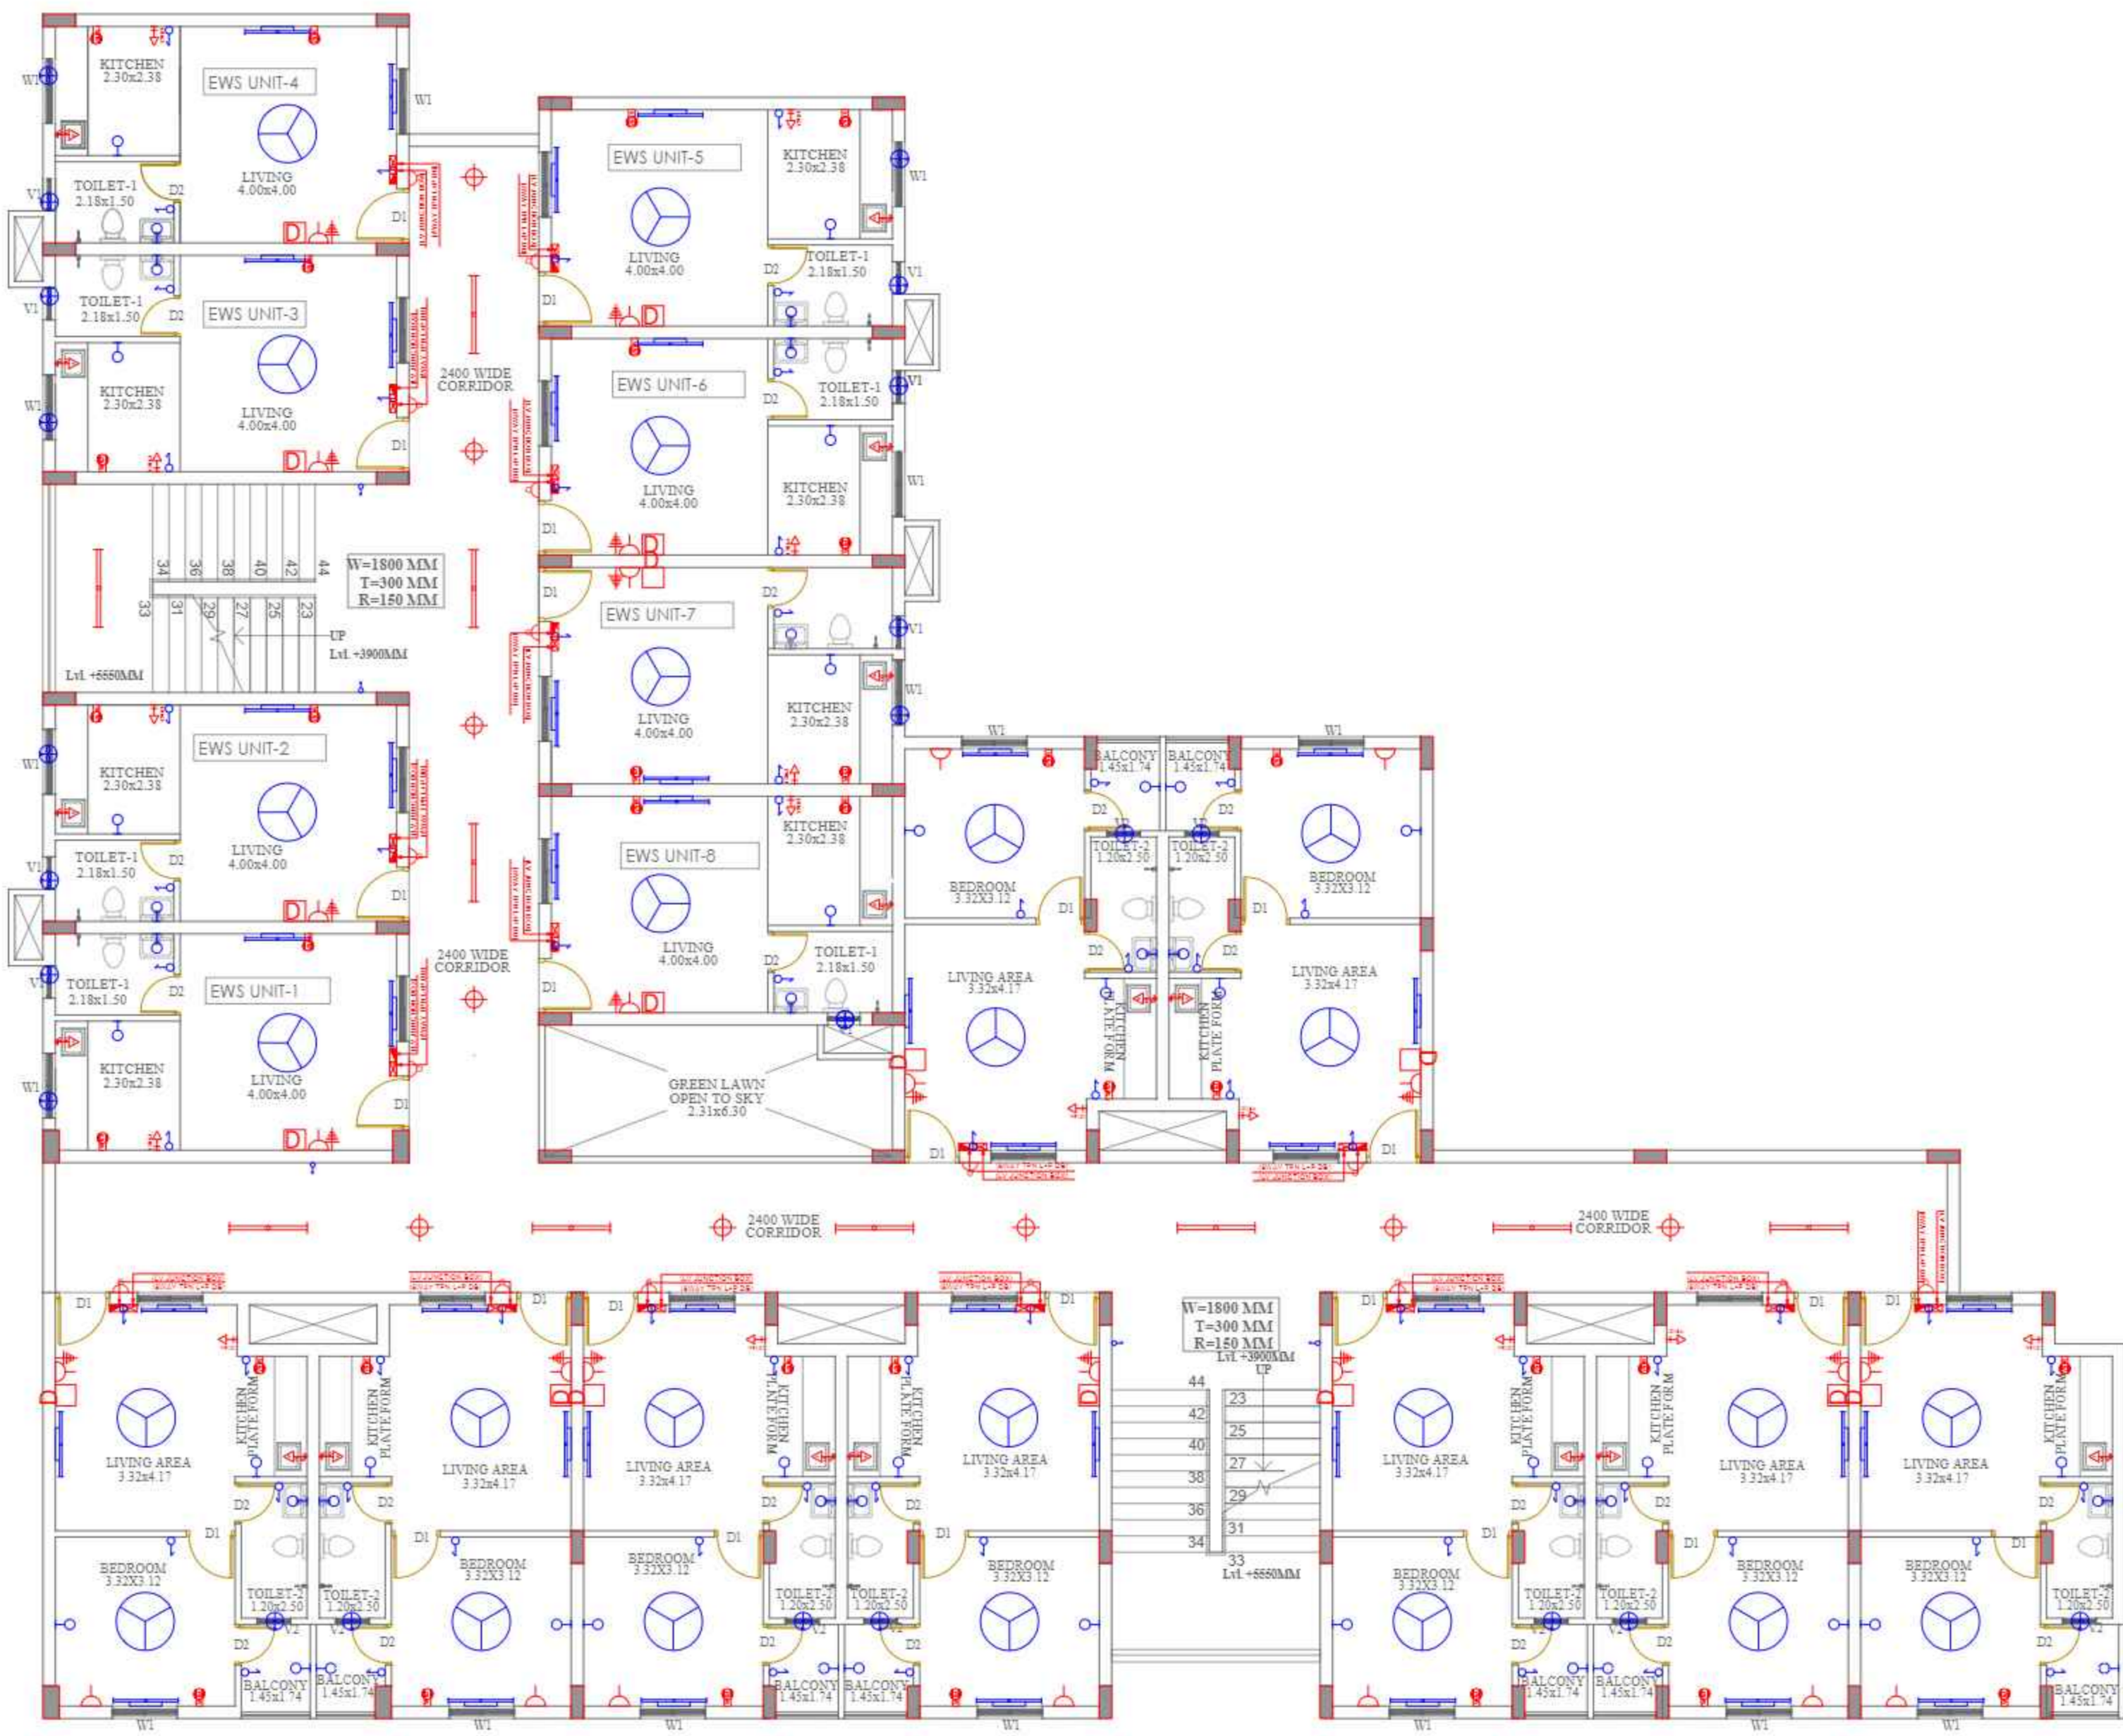

LEGENDS :

SYMBOL	DESCRIPTION	HEIGHT IN FLOOR FINISH LVL.
⚡	16-25A POWER PLUG POINT FOR AC UNIT	450MM
⚡	15/16A POWER PLUG POINT	450MM
📞	TELEPHONE OUTLET	450MM
⚡	15/16A POWER PLUG POINT IN KITCHEN	900MM
📡	DATA	
🔌	15/16A POWER PLUG POINT FOR GEYSER	2250MM
🔌	5/6A LIGHT PLUG POINT FOR TV	1200MM
📺	TELEVISION POINT	1200MM
🔌	5/6A LIGHT PLUG POINT	450MM
🔌	5/6A LIGHT PLUG POINT FOR RD	1800MM
🔔	BELL	2250MM


LEGENDS :

SYMBOL	DESCRIPTION	HEIGHT IN FLOOR FINISH LVL.
⚡	SWITCH BOARD	1050MM
💡	BATTEN HOLDER WITH 20W LED BULB	2250MM
💡	20W LED WALL MOUNTED TUBE LIGHT	2250MM
💡	20W LED CEILING MOUNTED TUBE LIGHT	CEILING
🌀	CEILING FAN 1200MM	CEILING
🌀	EXHAUST FAN 200mm	AS/PER WINDOW
📡	DISTRIBUTION BOARD	1500MM
📡	LV JUNCTION BOX	2250MM

FIRST FLOOR PLAN I.G. AND E.W.S SECTION

THIS DRAWING IS THE PROPERTY OF THE DERA AND SHALL NOT BE COPIED OR USED IN ANY MANNER WITHOUT PRIOR PERMISSION.

REVISIONS OF DRAWINGS		
MARK	DATE	DESCRIPTION

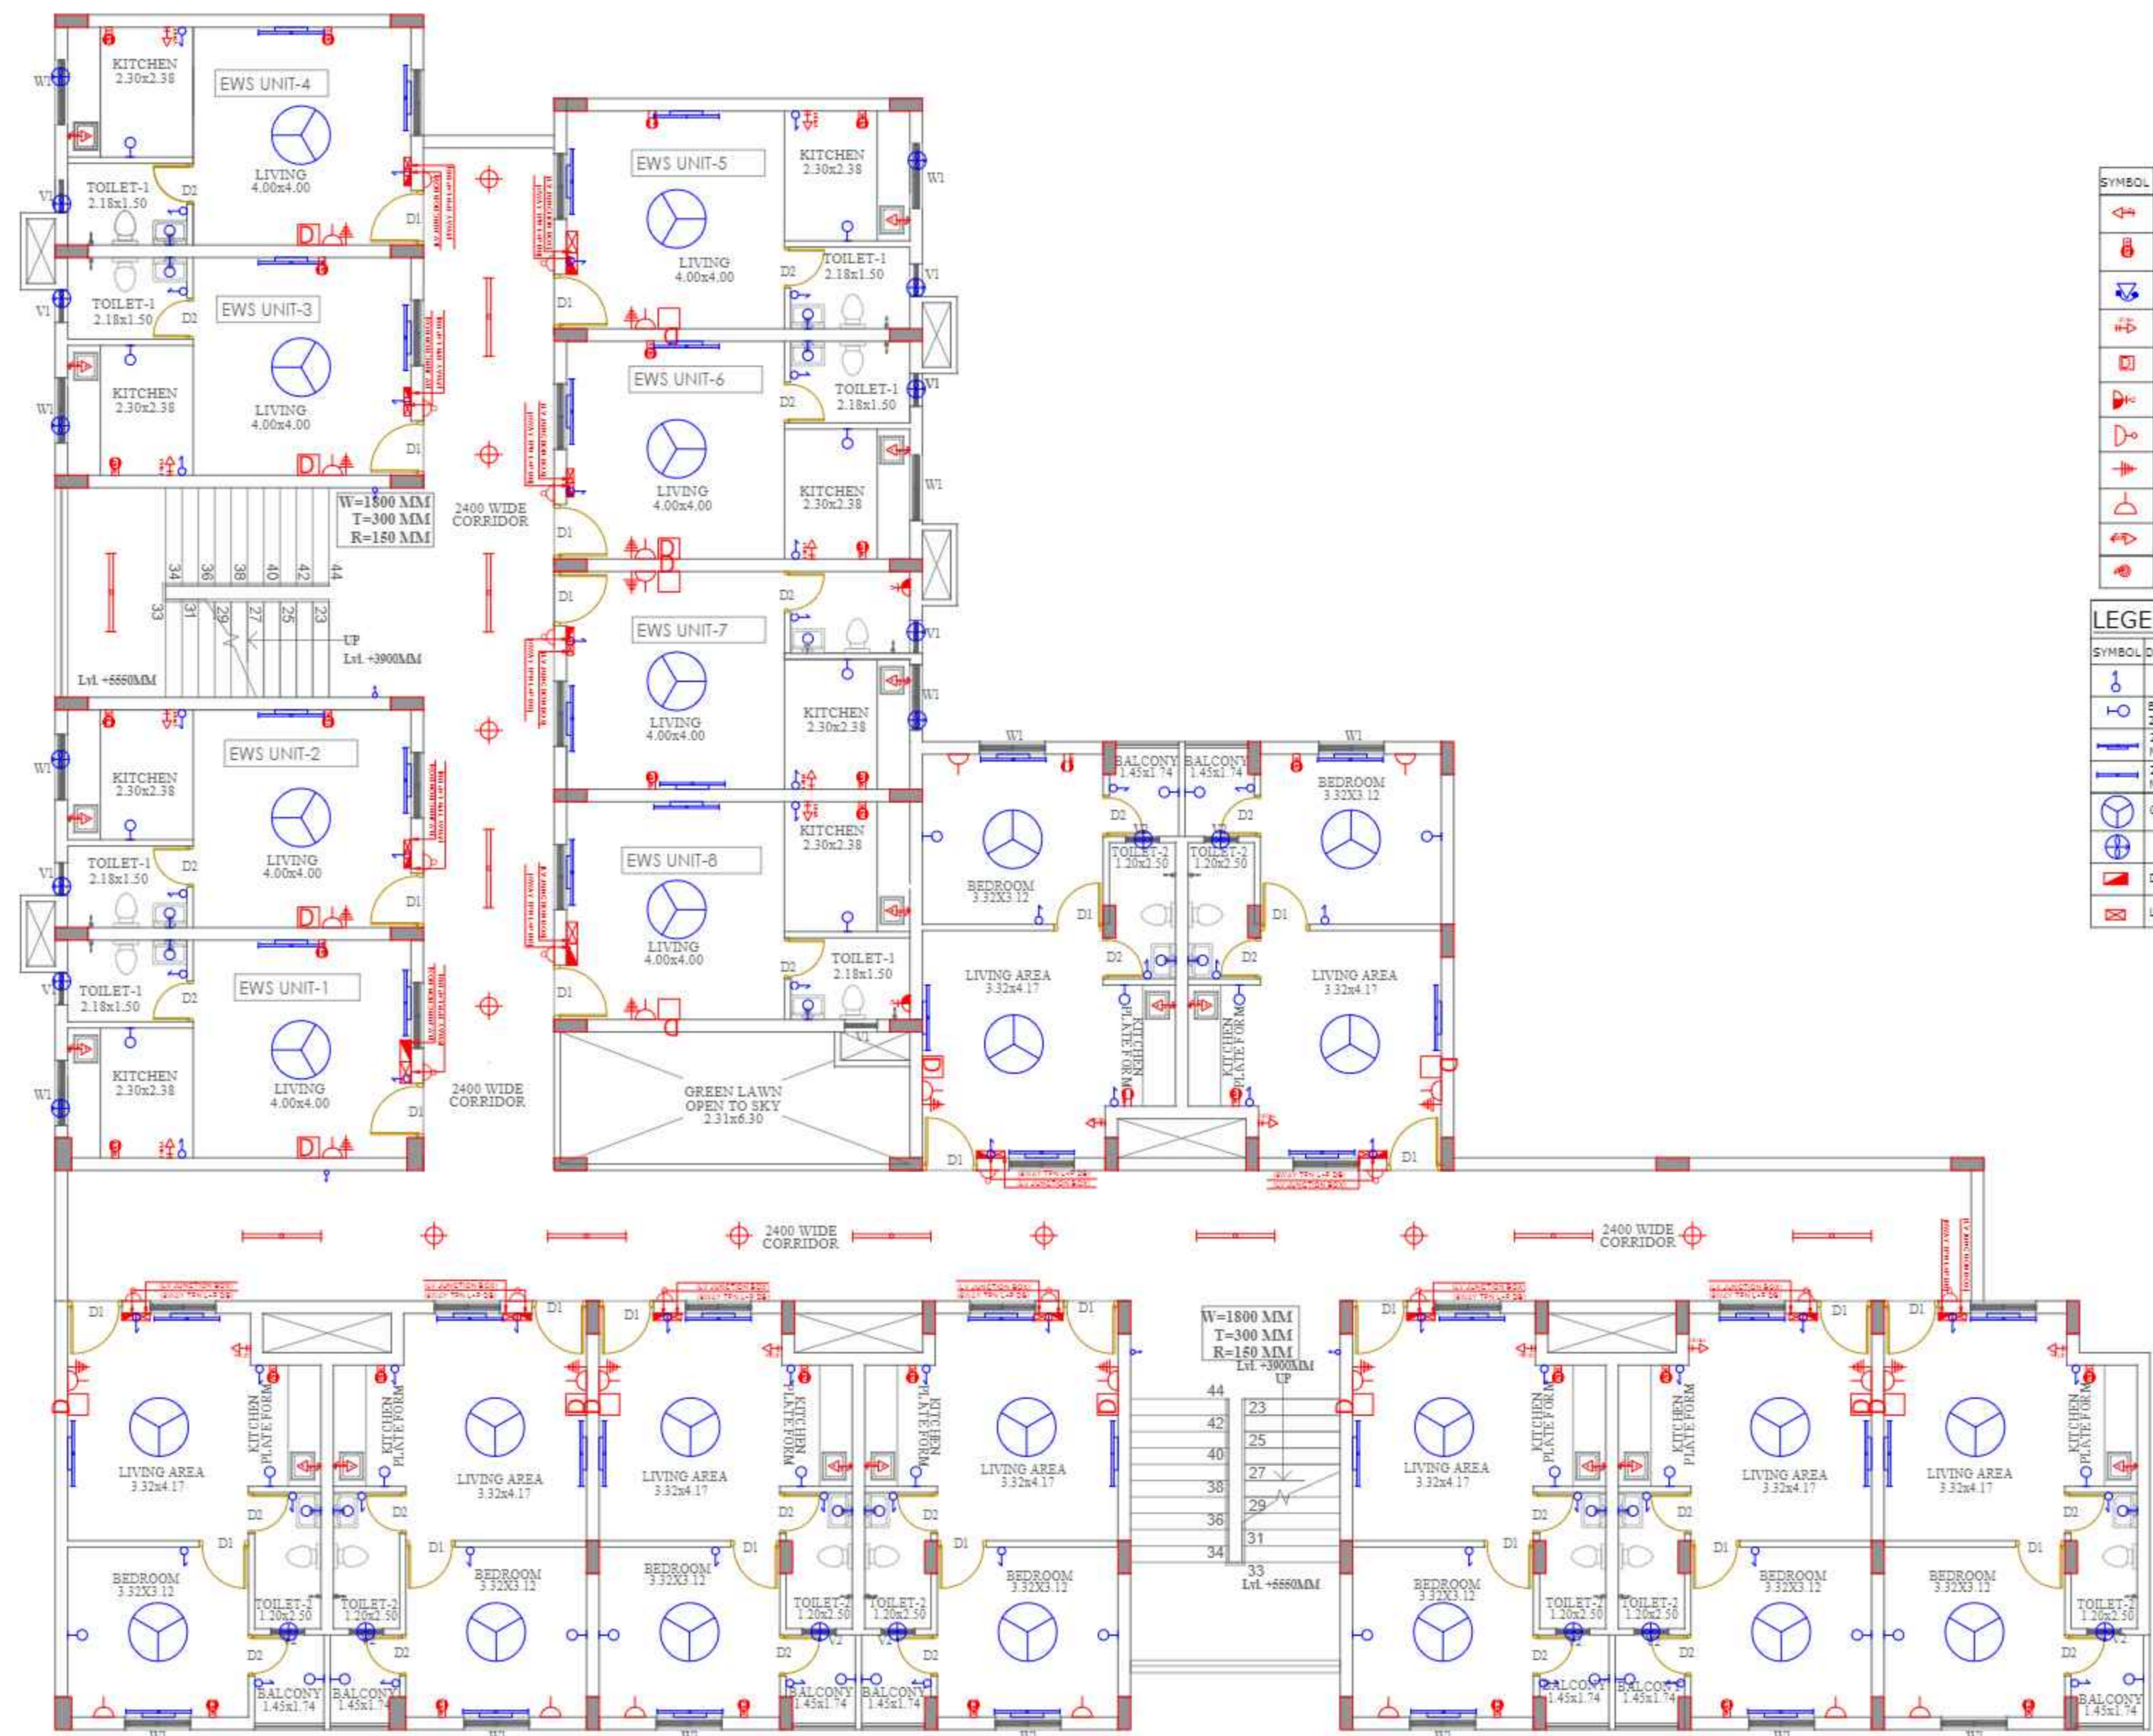

LEGENDS :

SYMBOL	DESCRIPTION	HEIGHT IN FLOOR FINISH LVL.
⚡	16-25A POWER PLUG POINT FOR AC UNIT	450MM
⚡	15/16A POWER PLUG POINT	450MM
☎	TELEPHONE OUTLET	450MM
⚡	15/16A POWER PLUG POINT IN KITCHEN	900MM
⚡	DATA	
⚡	15/16A POWER PLUG POINT FOR GEYSER	2250MM
⚡	5/6A LIGHT PLUG POINT FOR TV	1200MM
⚡	TELEVISION POINT	1200MM
⚡	5/6A LIGHT PLUG POINT	450MM
⚡	5/6A LIGHT PLUG POINT FOR RD	1800MM
🔔	BELL	2250MM

LEGENDS :

SYMBOL	DESCRIPTION	HEIGHT IN FLOOR FINISH LVL.
⚡	SWITCH BOARD	1050MM
⚡	BATTEN HOLDER WITH 20W LED BULB	2250MM
⚡	20W LED WALL MOUNTED TUBE LIGHT	2250MM
⚡	20W LED CEILING MOUNTED TUBE LIGHT	CEILING
⚡	CEILING FAN 1200MM	CEILING
⚡	EXHAUST FAN 200mm	AS/PER WINDOW
⚡	DISTRIBUTION BOARD	1500MM
⚡	LV JUNCTION BOX	2250MM

GENERAL NOTES

1. ALL DIMENSIONS ARE IN MM UNLESS OTHERWISE SPECIFIED
2. ALL ARCHITECTURE & STRUCTURE DRAWINGS TO BE READ TOGETHER, ALONG WITH ALL SERVICE DETAIL DRAWING
3. ALL DIMENSION MUST BE CHECKED ON SITE & WITH OTHER DRAWING BEFORE EXECUTION
4. DRAWING NOT TO BE SCALED, ONLY MENTIONING DIMENSION TO BE FOLLOWED
5. ANY DISCREPANCY, IF FOUND IN DRAWING OR ON SITE THE SAME WILL BE INFORMED TO CONSULTANTS OR ENGINEER IN CHARGE FOR PROPER CLARIFICATION

SECOND FLOOR PLAN
L.I.G. AND E.W.'S SECTION

PROJECT DETAILS

CLIENT
Shri Raghav Agrawal S/O Shri Ram Agrawal
R/O: 1249 SARAGANI DARWAZA PLOT NO. 1214 1A1 SHRI COLONY MAHANTI ROAD MATHURA

ARCHITECT CONSULTANT
DERA Consultants Pvt. Ltd.
308, GEETA ENCLAVE, KRISHNA NAGAR, MATHURA-281004
Tel: +91-9909071654, Email: office@dera.co.in

(Authorise Signatory with Stamp)

PROJECT TITLE

SHRI VRINDA ENCLAVE

DRAWING TITLE

SECOND FLOOR PLAN

DRAWING PURPOSE

FOR APPROVAL

SCALE: 1:100 REVISION DATE OF ISSUE: 31/01/2023


DWG NO.: EL-103 FLOOR PLAN

SHEET SIZE: -A1 SHEET NO.: 03/05
DRAWN BY: HG CHECKED BY: DD

THIS DRAWING IS THE PROPERTY OF THE DERA AND SHALL NOT BE COPIED OR USED IN ANY MANNER WITHOUT PRIOR PERMISSION.

REVISIONS OF DRAWINGS		
MARK	DATE	DESCRIPTION

- GENERAL NOTES**
1. ALL DIMENSIONS ARE IN MM UNLESS OTHERWISE SPECIFIED
 2. ALL ARCHITECTURE & STRUCTURE DRAWINGS TO BE READ TOGETHER, ALONG WITH ALL SERVICE DETAIL DRAWING
 3. ALL DIMENSIONS MUST BE CHECKED ON SITE & WITH OTHER DRAWING BEFORE EXECUTION
 4. DRAWING NOT TO BE SCALED, ONLY MENTIONING DIMENSION TO BE FOLLOWED
 5. ANY DISCREPANCY, IF FOUND IN DRAWING OR ON SITE THE SAME WILL BE INFORMED TO CONSULTANTS OR ENGINEER IN CHARGE FOR PROPER CLARIFICATION

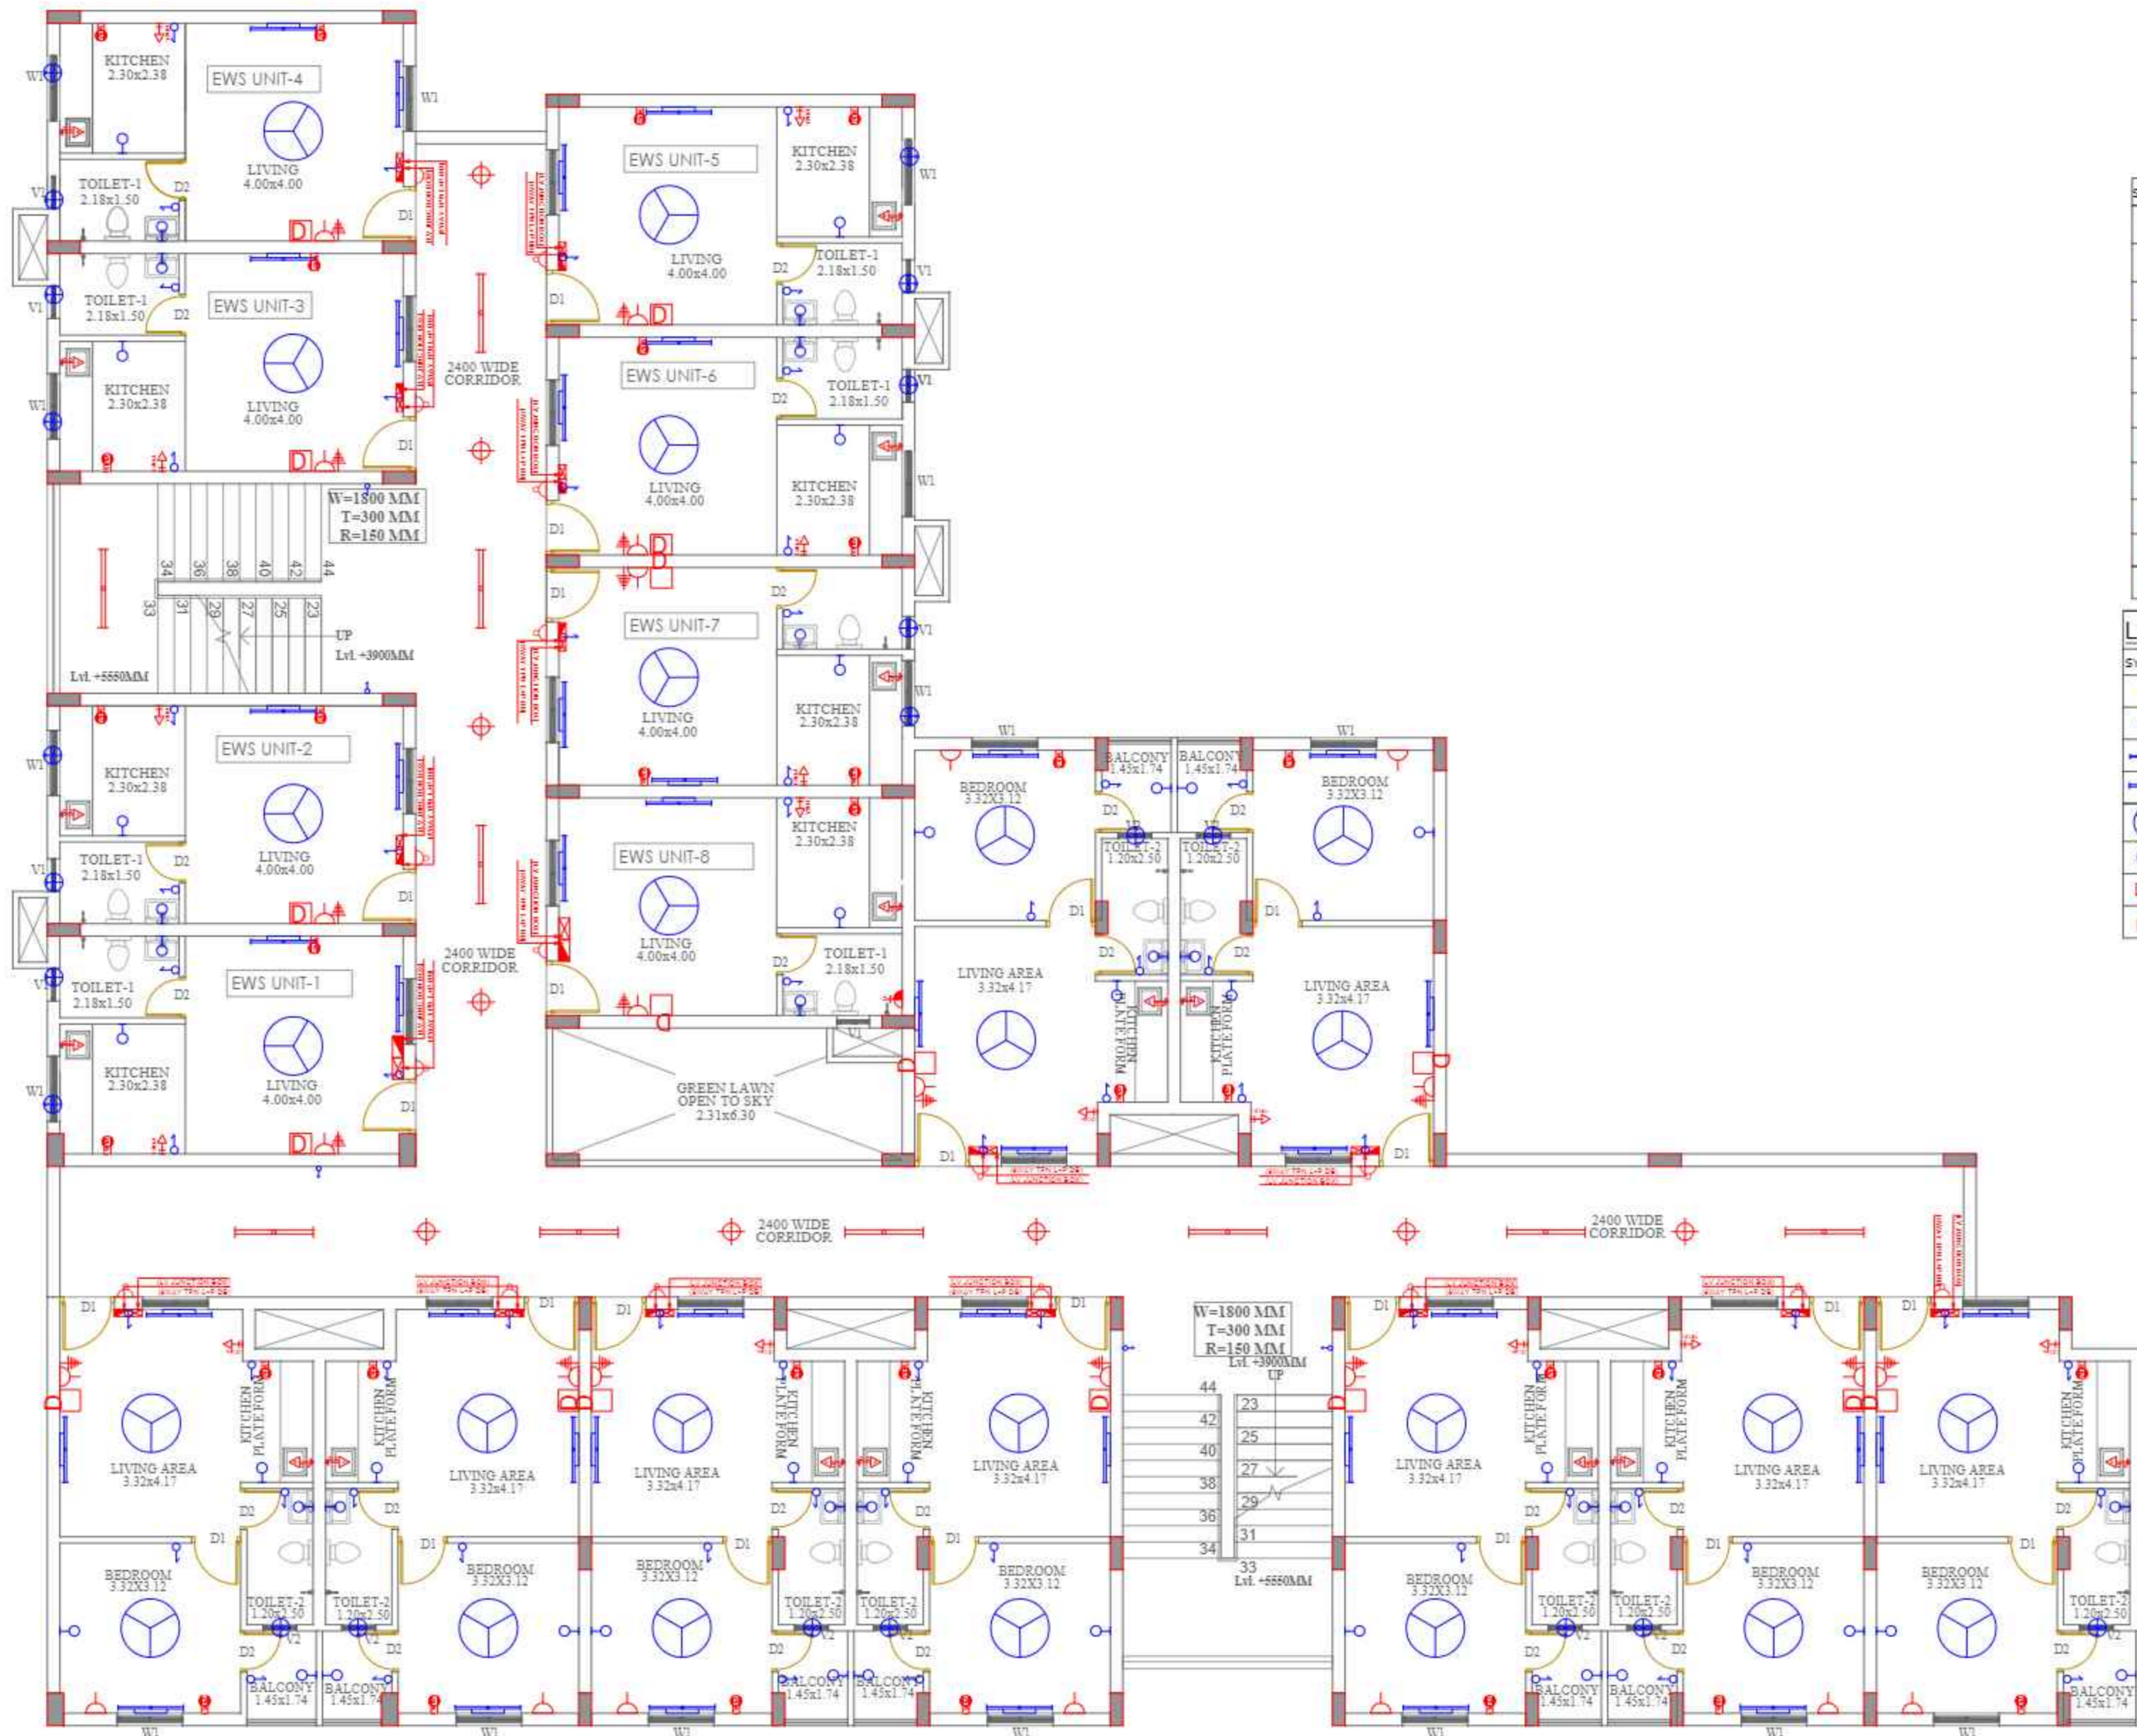

LEGENDS :

SYMBOL	DESCRIPTION	HEIGHT IN FLOOR FINISH LVL.
⚡	16/25A POWER PLUG POINT FOR AC UNIT	450MM
⚡	15/16A POWER PLUG POINT	450MM
☎	TELEPHONE OUTLET	450MM
⚡	15/16A POWER PLUG POINT IN KITCHEN	900MM
⚡	DATA	
⚡	15/16A POWER PLUG POINT FOR GEYSER	2250MM
⚡	5/6A LIGHT PLUG POINT FOR TV	1200MM
⚡	TELEVISION POINT	1200MM
⚡	5/6A LIGHT PLUG POINT	450MM
⚡	5/6A LIGHT PLUG POINT FOR RD	1800MM
🔔	BELL	2250MM

LEGENDS :

SYMBOL	DESCRIPTION	HEIGHT IN FLOOR FINISH LVL.
⚡	SWITCH BOARD	1050MM
⚡	BATTEN HOLDER WITH 20W LED BULB	2250MM
⚡	20W LED WALL MOUNTED TUBE LIGHT	2250MM
⚡	20W LED CEILING MOUNTED TUBE LIGHT	CEILING
⚡	CEILING FAN 1200MM	CEILING
⚡	EXHAUST FAN 200mm	AS/PER WINDOW
⚡	DISTRIBUTION BOARD	1500MM
⚡	LV JUNCTION BOX	2250MM

THIRD FLOOR PLAN
L.I.G. AND E.W.S. SECTION

PROJECT DETAILS

CLIENT
Shri Raghav Agrawal S/O Shri Ram Agrawal
R/O : 1249 SARAGANI DARWAZA PLOT NO. 1214 1A1 SHRI COLONY MAHANTI ROAD MATHURA

ARCHITECT CONSULTANT
DERA Consultants Pvt. Ltd.
308, GEETA ENCLAVE, KRISHNA NAGAR, MATHURA-281004
Tel : +91-9909071654, Email : office@dera.co.in
(Authorised Signatory with Stamp)

PROJECT TITLE
SHRI VRINDA ENCLAVE

DRAWING TITLE
THIRD FLOOR PLAN

DRAWING PURPOSE
FOR APPROVAL

SCALE- 1:100	REVISION	DATE OF ISSUE- 31/01/2023
-----------------	----------	------------------------------

DWG NO.-
EL-104 FLOOR PLAN

SHEET SIZE	SHEET NO.- 04/05
DRAWN BY HG	CHECKED BY DD


THIS DRAWING IS THE PROPERTY OF THE DERA AND SHALL NOT BE COPIED OR USED IN ANY MANNER WITHOUT PRIOR PERMISSION.

REVISIONS OF DRAWINGS

MARK	DATE	DESCRIPTION

GENERAL NOTES

1. ALL DIMENSIONS ARE IN MM UNLESS OTHERWISE SPECIFIED
2. ALL ARCHITECTURE & STRUCTURE DRAWINGS TO BE READ TOGETHER, ALONG WITH ALL SERVICE DETAIL DRAWING
3. ALL DIMENSION MUST BE CHECKED ON SITE & WITH OTHER DRAWING BEFORE EXECUTION
4. DRAWING NOT TO BE SCALED, ONLY MENTIONING DIMENSION TO BE FOLLOWED
5. ANY DISCREPANCY, IF FOUND IN DRAWING OR ON SITE THE SAME WILL BE INFORMED TO CONSULTANTS OR ENGINEER IN CHARGE FOR PROPER CLARIFICATION

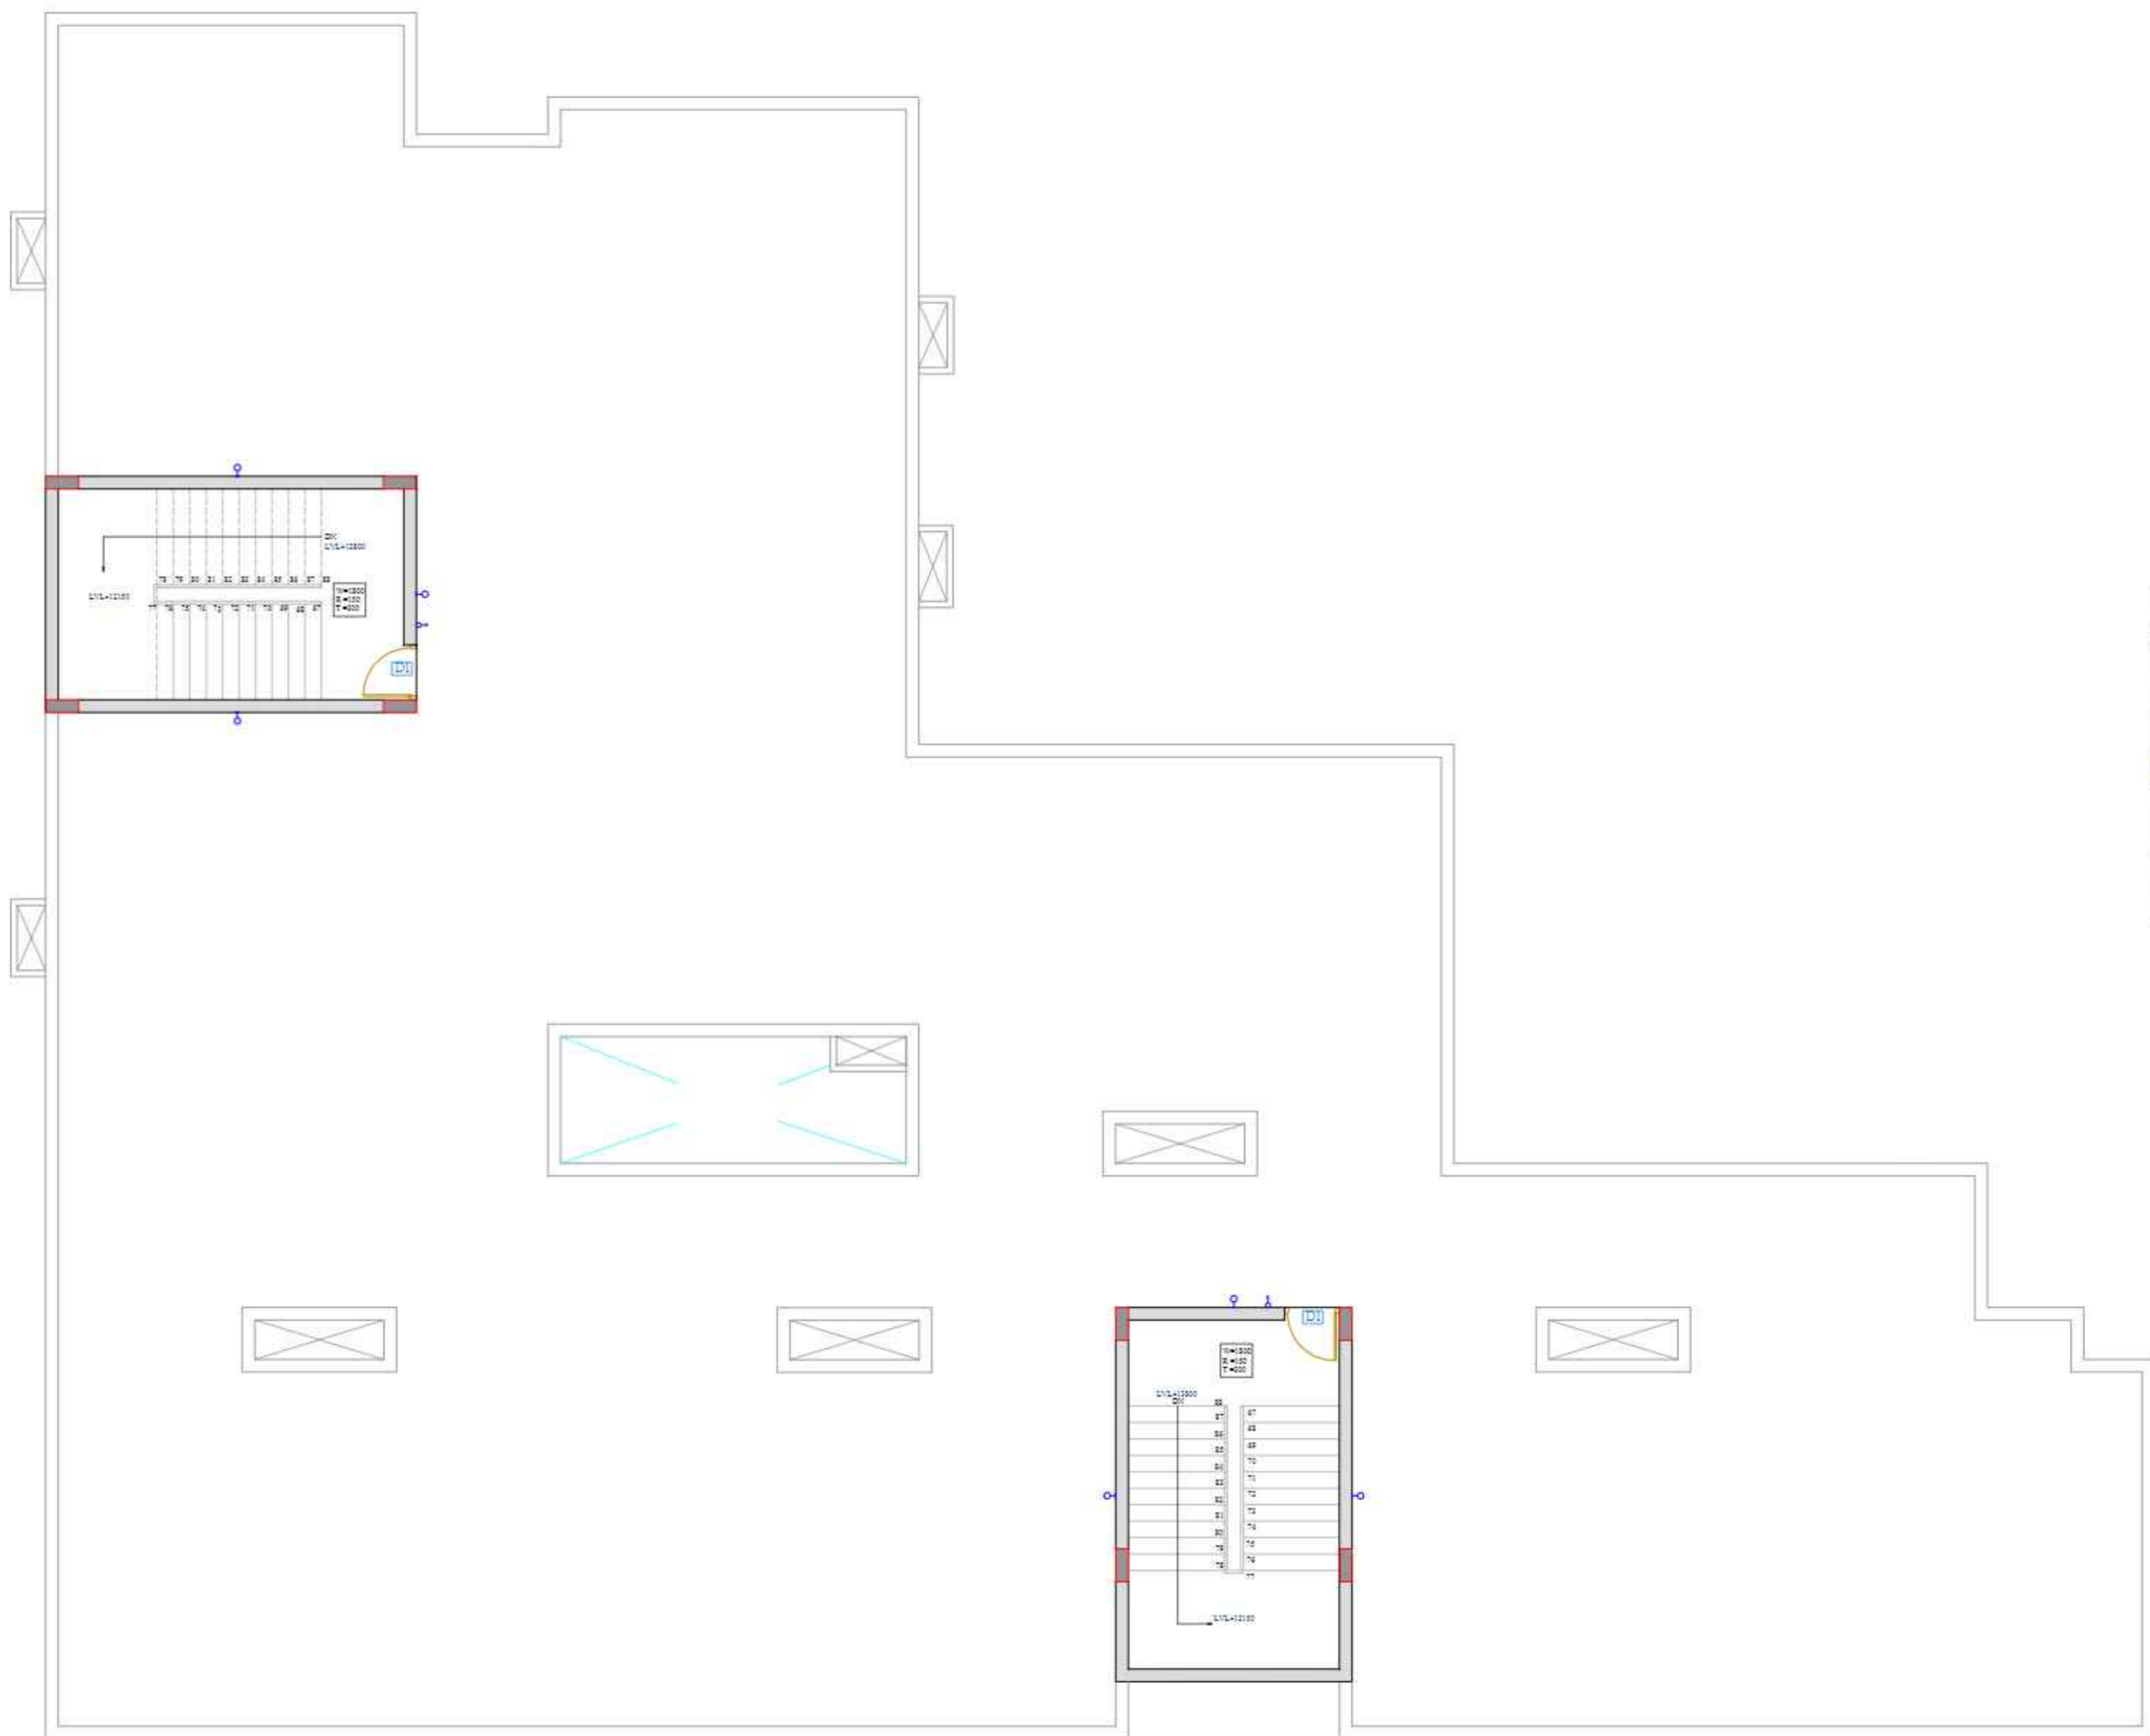

LEGENDS :

SYMBOL	DESCRIPTION	HEIGHT IN FLOOR FINISH LVL
⚡	16-25A POWER PLUG POINT FOR AC UNIT	450MM
🔌	15/16A POWER PLUG POINT	450MM
☎	TELEPHONE OUTLET	450MM
🔌	15/16A POWER PLUG POINT IN KITCHEN	900MM
📶	DATA	
🔌	15/16A POWER PLUG POINT FOR GEYSER	2250MM
📺	5/6A LIGHT PLUG POINT FOR TV	1200MM
📺	TELEVISION POINT	1200MM
💡	5/6A LIGHT PLUG POINT	450MM
📺	5/6A LIGHT PLUG POINT FOR RD	1800MM
📞	BELL	2250MM

LEGENDS :

SYMBOL	DESCRIPTION	HEIGHT IN FLOOR FINISH LVL
🔌	SWITCH BOARD	1050MM
💡	BATTEN HOLDER WITH 20W LED BULB	2250MM
💡	20W LED WALL MOUNTED TUBE LIGHT	2250MM
💡	20W LED CEILING MOUNTED TUBE LIGHT	CEILING
🌀	CEILING FAN 1200MM	CEILING
🌀	EXHAUST FAN 200mm	AS/PER WINDOW
📶	DISTRIBUTION BOARD	1500MM
📶	LV JUNCTION BOX	2250MM

TERRACE FLOOR PLAN
L.I.G. AND E.W.S SECTION

PROJECT DETAILS

CLIENT
Shri Raghav Agrawal S/O Shri Ram Agrawal
R/O : 1249 SARAGANI DARWAZA PLOT NO. 1214 1A1 SHRI
COLONY MASANI ROAD MATMURA

ARCHITECT CONSULTANT
DERA Consultants Pvt. Ltd.
308, GEETA ENCLAVE, KRISHNA NAGAR, MATHURA-201004
Tel : +91-9909071654, Email : office@dera.co.in
(Authorised Signatory with Stamp)

PROJECT TITLE
SHRI VRINDA ENCLAVE

DRAWING TITLE
TERRACE FLOOR PLAN

DRAWING PURPOSE
FOR APPROVAL
SCALE:- 1:100 REVISION DATE OF ISSUE:- 31/01/2023

DWG NO:- **EL-105 FLOOR PLAN**
SHEET SIZE -A1 SHEET NO- 05/05
DRAWN BY HG CHECKED BY DD