




P/O SARASWATI INTER COLLEGE

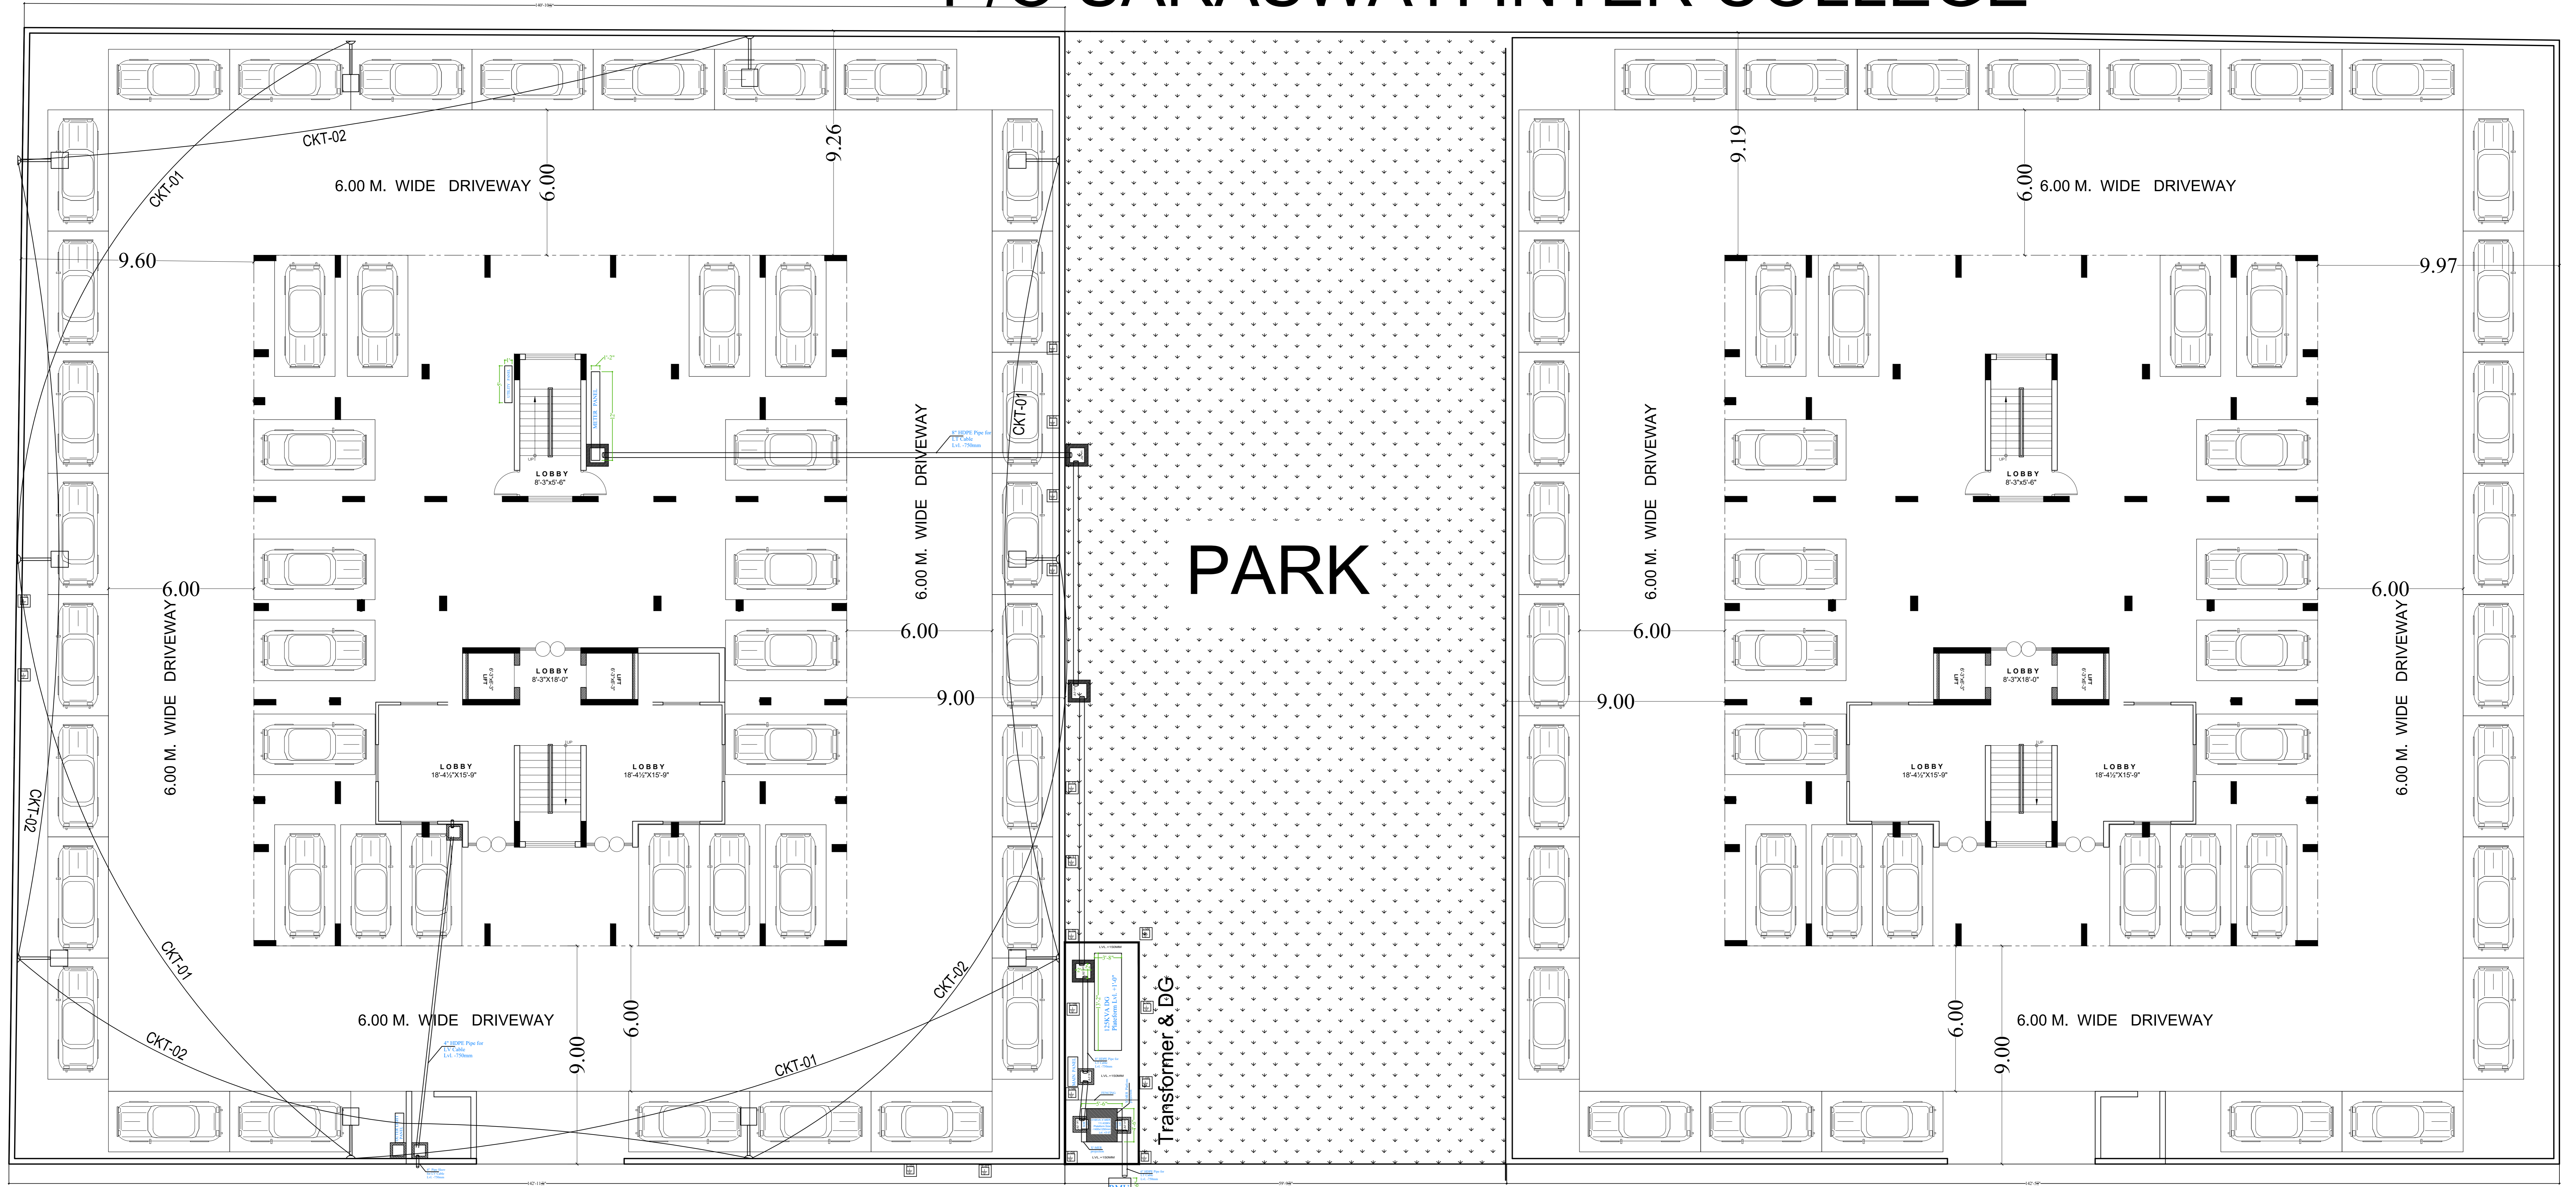

PROPOSED GROUP HOUSING 01
STILT FLOOR PLAN

12.00 M. WIDE ROAD

PROPOSED GROUP HOUSING 02
STILT FLOOR PLAN

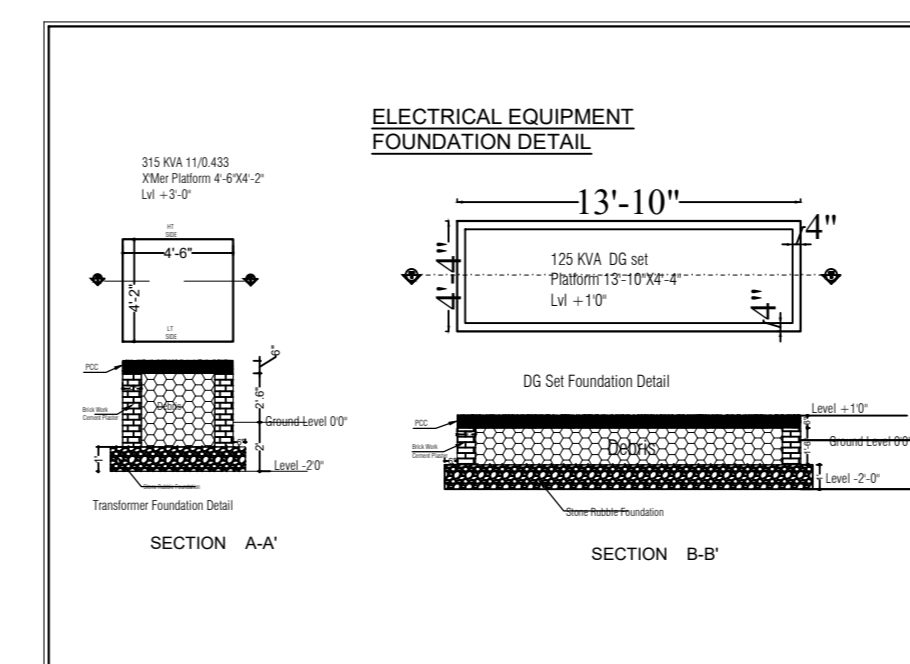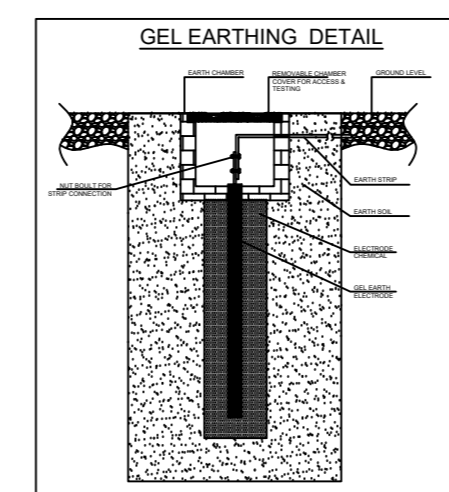

GEL Earthing FIROZABAD G-8							
S.NO	DETAIL	QTY	EARTH NO	SIZE OF EARTH STRIP IN MM	GEL EARTHSIZE	TYPE OF EARTH STRIP	
1	RMU Body	2	E1.12	2556	3 Mt/50mm	GI	
2	315 KVA XMTR Neutral	2	E3.14	5055	3 Mt/50mm	Cu	
3	315 KVA XMTR Body	2	E5.16	5055	2 Mt/50mm	GI	
4	MAIN PANEL	2	E7.18	2556	2 Mt/50mm	GI	
5	125 KVA DG Neutral	2	E9.10	2545	3 Mt/50mm	Cu	
6	125 KVA DG Body	2	E11.12	2545	2 Mt/50mm	GI	
7	LT PANEL	4	E13.10/16	3850	2 Mt/50mm	Cu	
8	LT PANEL	2	E15.16	2556	2 Mt/50mm	GI	

LEGEND		
1.	BULKHEAD FOR RAMP	2'-6"
2.	DISTRIBUTION BOX	5'-0"
3.	CONDUIT CIRCUIT (25MM)	CEILING
4.	CONDUIT POINT WIRING (25MM)	CEILING
5.	CONDUIT SUB MAIN WIRING (25MM)	CEILING
6.	CONDUIT CCTV WIRING (25MM)	CEILING
7.	CCTV CAMERA	ALF SITE
8.	POLE LIGHT CKT LOOPING	ALF SITE
9.	STREET POLE LIGHT	10 NOS
10.	200MM HDPE PVC PIPE	ALF SITE
11.	100MM HDPE PVC PIPE	ALF SITE
12.	100MM HDPE PVC PIPE	ALF SITE
13.	50MM HDPE PVC PIPE	ALF SITE
14.	40000MM ELECTRIC CHAMBER	5 NOS
15.	60000MM ELECTRIC CHAMBER	4 NOS

TITLE :-
PROPOSED AFFORDABLE PROJECT
AT FIROZABAD.

MEP CONSULTANTS
Srajan Associates
MEP Consultant
C-35A, Nakshtra Pride,
Lajpat marg, c-scheme, Jaipur

ARCHITECTS
MISHRA GARG AND ASSOCIATES
C-35 LAAJPAT MARG C SCHEME JAIPUR
Email:- mishra.garg@gmail.com

DRG. TITLE:-
GROUND FLOOR
ELECTRICAL PLAN

DRG.No
SA/00/00000
REV:- R-01

SCALE
DATE
N.T.S.
20-03-2023
DEALT BY:-
PRAVEEN
CHK. BY: -
00

