


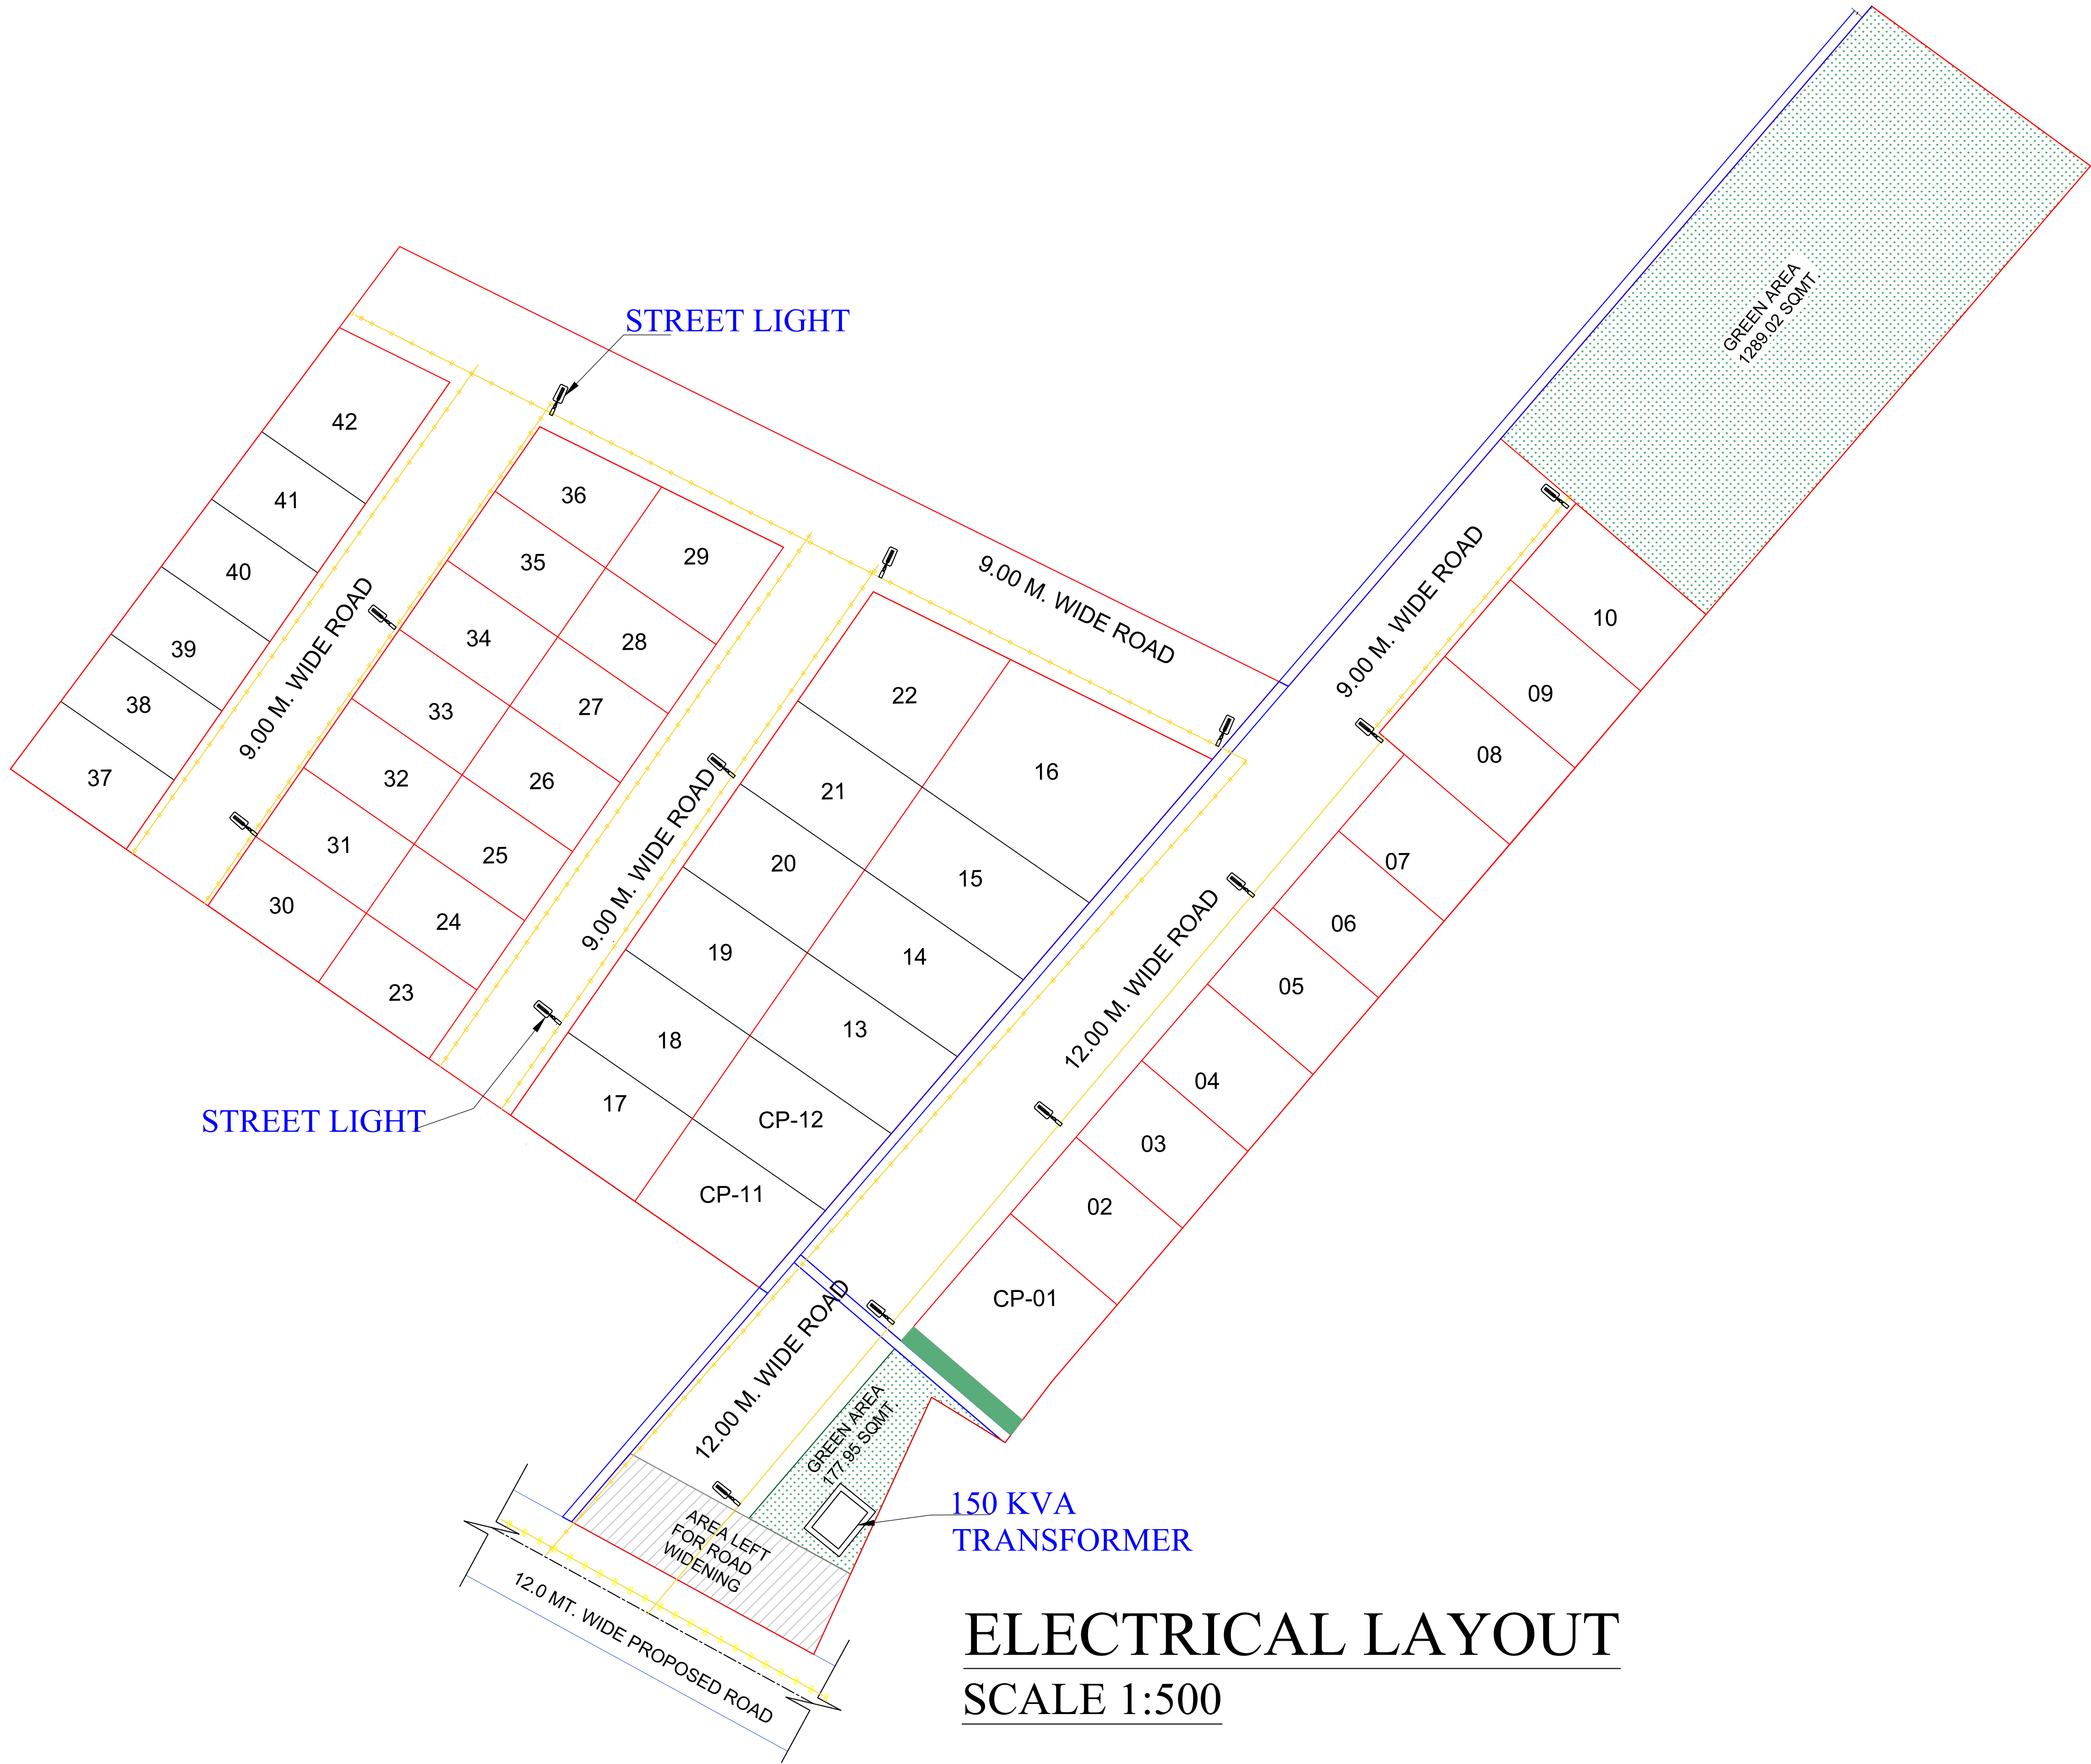


ELECTRICAL LAYOUT
SCALE 1:500

REFERENCE -:

ELE.LINE

PROJECT:
LAYOUT PLAN FOR SOL CITY
FROM SOL INFRASTRUCTURE
THROUGH It's PARTNER MR. ATUL BANSAL S/O MR. MR. KALURAM BANSAL
KHASRA NO. - 273 , 274 & 276 , 281 , 282 , VILLAGE - MAHURAKALA ,
TEHSIL - MOHANLALGANJ , DISTT. - LUCKNOW.

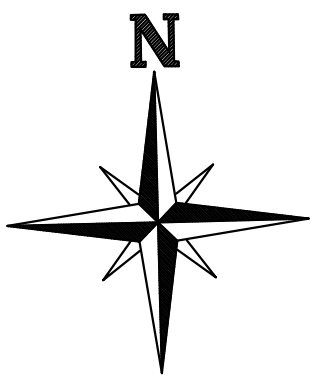

OWNERS:

SOL INFRASTRUCTURE
PARTNER

ARCHITECT:

Ar. Yati Kumar Mishra
B. Arch. M. Plans, A.I.I.A.
312, 3rd Floor, Skyline Plaza-1,
Sushant Golf City, Lucknow.
Regd. No.-CA/124714

SHALEEN
CONSULTANTS
AR. PAWAN MISHRA
AR. YATI KUMAR MISHRA

2nd Floor, Aishwarya Plaza-1, Sector-H, Aliganj, Lucknow
312, 3rd. Floor, Skyline Plaza,Sushant Golf City,Lucknow
E-Mail : info.shaleenconsultants@gmail.com
Contact No. : +91 9335920481 | +91 8896832308