


EXTERNAL SERVICES M.H.

REFER SITE PLAN

EXTERNAL DRAIN LINE

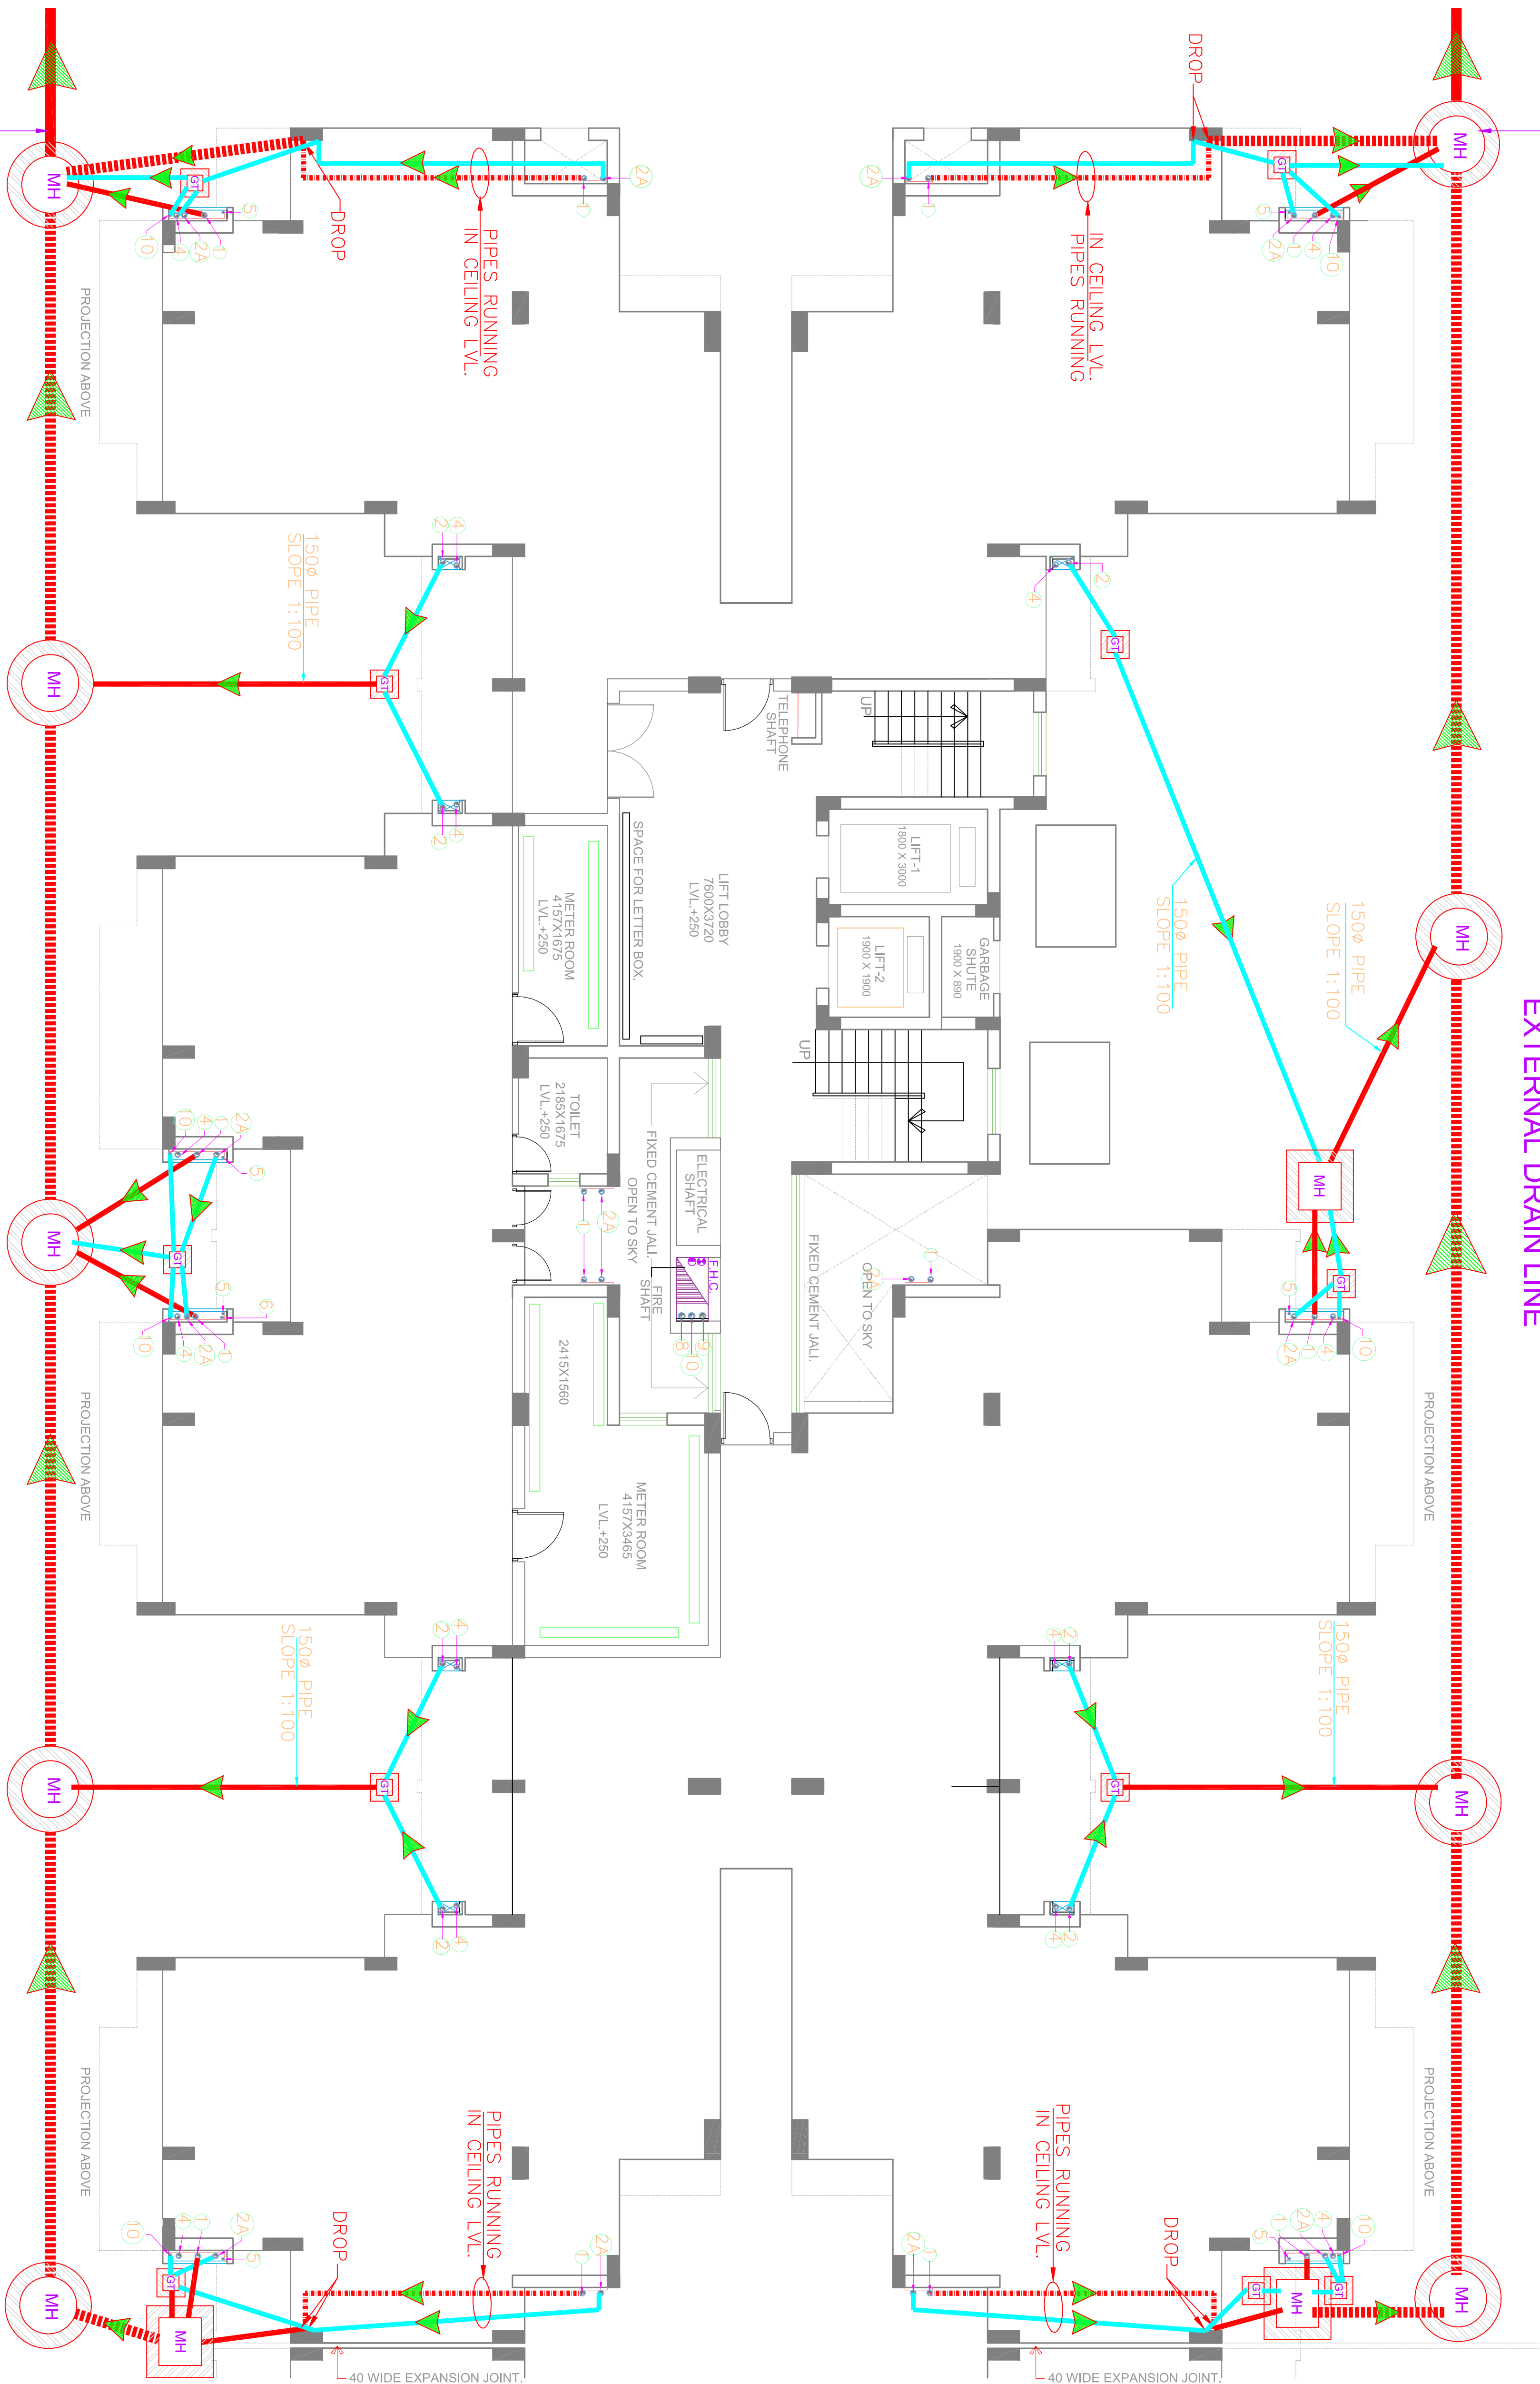

LEGEND:-

①	100Ø SOIL & VENT PIPE
①A	75Ø VENT PIPE
②	100Ø KITCHEN WASTE PIPE
2A	100Ø WASTE & VENT PIPE
③	32Ø WATER SUPPLY DN TAKE PIPE FOR-9,7,6 & 5 FLOORS
3A	32Ø WATER SUPPLY DN TAKE PIPE FOR-4,3,2 & 1 FLOORS
④	100Ø RAIN WATER PIPE
⑤	50Ø RAIN WATER PIPE (BALCONY)
⑥	50Ø WATER SUPPLY RISER PIPE.
⑧	100ØMS. FIRE PIPE
⑨	100Ø SPRINKLER PIPE
⑩	50Ø WASTE PIPE FOR (WASHING MACHINE DRAIN)
⊕	4.5 Kg. CO2 FIRE EXTINGUISHER
⊖	9 Lt. WATER TYPE FIRE EXTN.
	FHC ---- FIRE HOSE CABINET

S.No.	DATE	DESCRIPTION
REVISION		

TYPE-C S+9
(2 BED ROOM UNIT)
(DOVE TOWER)
PROJECT
PROPOSED GROUP HOUSING AT
ANSAL TOWN AT MEERUT.
PHASE-2.

PLUMBING WORKING DWG.

SEWERAGE PLAN

DATE	08.05.2011	DEALT BY	S.R.
SCALE	1:65	CHECKED BY	M.K.
DWG. NO.	SERV.452/MEERUT-A, TOWN/PL01		

MANOJ KUMAR
DESIGN ENGINEER
(SERVICES)

ADITYA KUMAR GUPTA
SR. C.A.M.(SERVICES)

ansal housing & construction L.TD.
15, UGF, INDRA PRAKASH
21 BARAKHAMBRA ROAD
NEW DELHI - 40 001

