


This drawing is a "COPYRIGHT" contents of this drawing or part thereof may not be used or reproduced without the permission of the Architect

PROJECT PROPOSED BUILDINGS AT COMMERCIAL -03, IN OMAXE HITECH CITY , LUCKNOW U.P.

COMMERCIAL-03

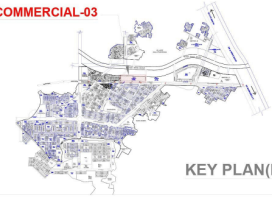

KEY PLAN(NTS)

SURFACE PARKING

MECHANICAL PARKING

SEWER LEGENDS:-		
S. NO.	SYMBOL	DESCRIPTION
1.		SEWERAGE LINE
2.		MANHOLE
3.		CIRCULAR MANHOLE
4.		DIRECTION OF FLOW

For Omaxe Garv Buildtech Pvt. Ltd.


Director

APURBA BORAH
Regd. Architect
CA/2013/61618


DRAWING TITLE
RERA SUBMISSION DRAWING
SEWERAGE SITE PLAN

SCALE N.T.S. DATE FEB 2026
ARCHITECT CLIENT/ OWNERS

DRAWING NUMBER- LKO/Hi-TECH/COMMERCIAL-03/SUB-02

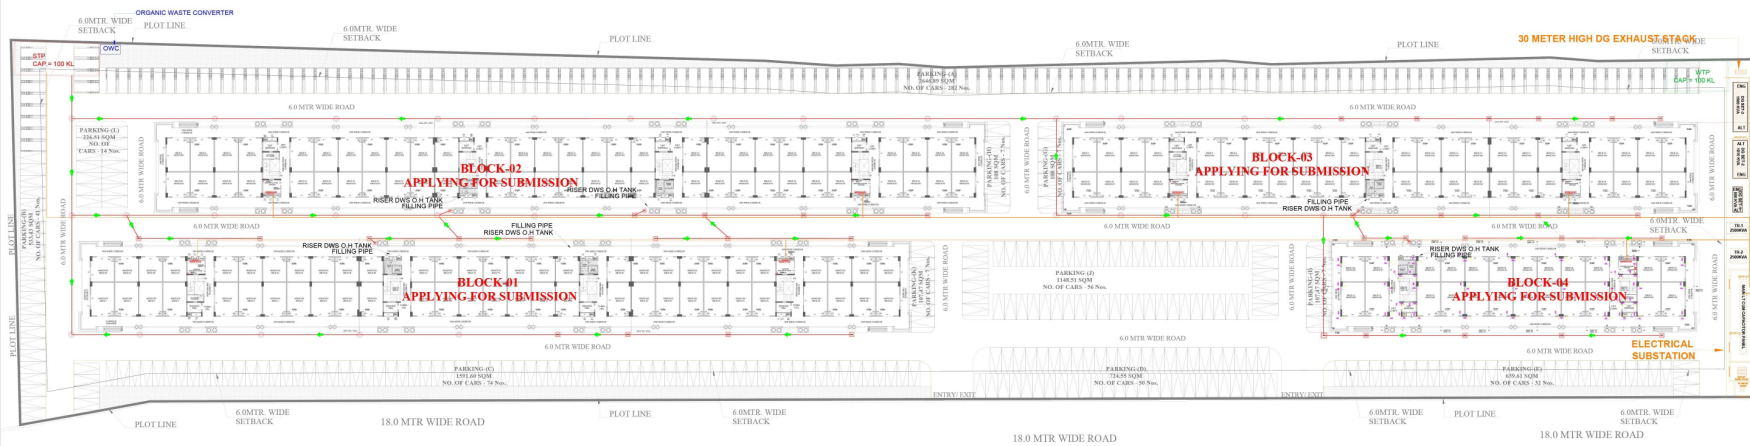

SITE PLAN

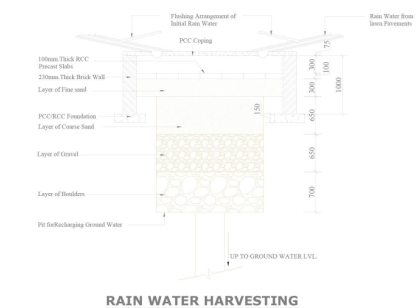

RAIN WATER HARVESTING