


This drawing is a "COPYRIGHT" contents of this drawing or part thereof may not be used or reproduced without the permission of the Architect

PROJECT PROPOSED BUILDINGS AT COMMERICAL -03,IN OMAXE HITECH CITY , LUCKNOW U.P.

COMMERCIAL-03

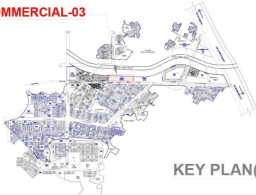

KEY PLAN(NTS)

SURFACE PARKING

MECHANICAL PARKING

ELECTRICAL LEGENDS:-

S. NO.	SYMBOL	DESCRIPTION
1.		HDPE PIPE FOR LT CABLES

APURBA BORAH
Regd. Architect
CA/2013/61618


For Omaxe Garv Buildtech Pvt. Ltd.

Director

DRAWING TITLE
RERA SUBMISSION DRAWING
ELECTRICAL SITE PLAN

SCALE N.T.S. DATE FEB 2026
ARCHITECT CLIENT/ OWNERS

DRAWING NUMBER- LKO/Hi-TECH/COMMERCIAL-03/SUB-05

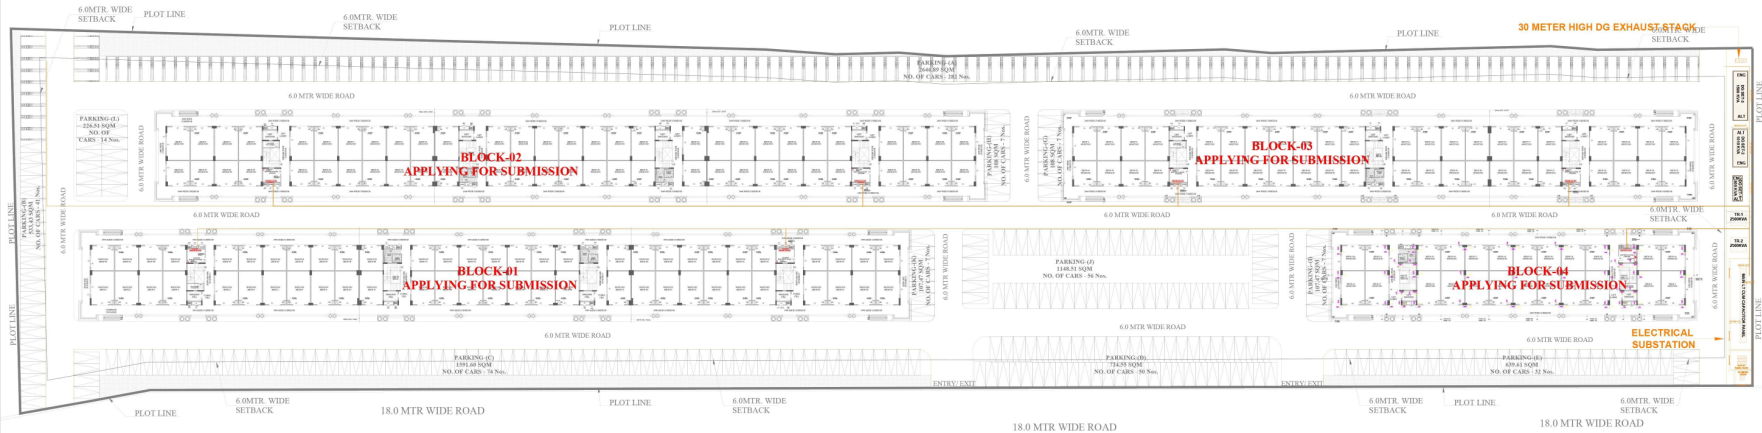

SITE PLAN