

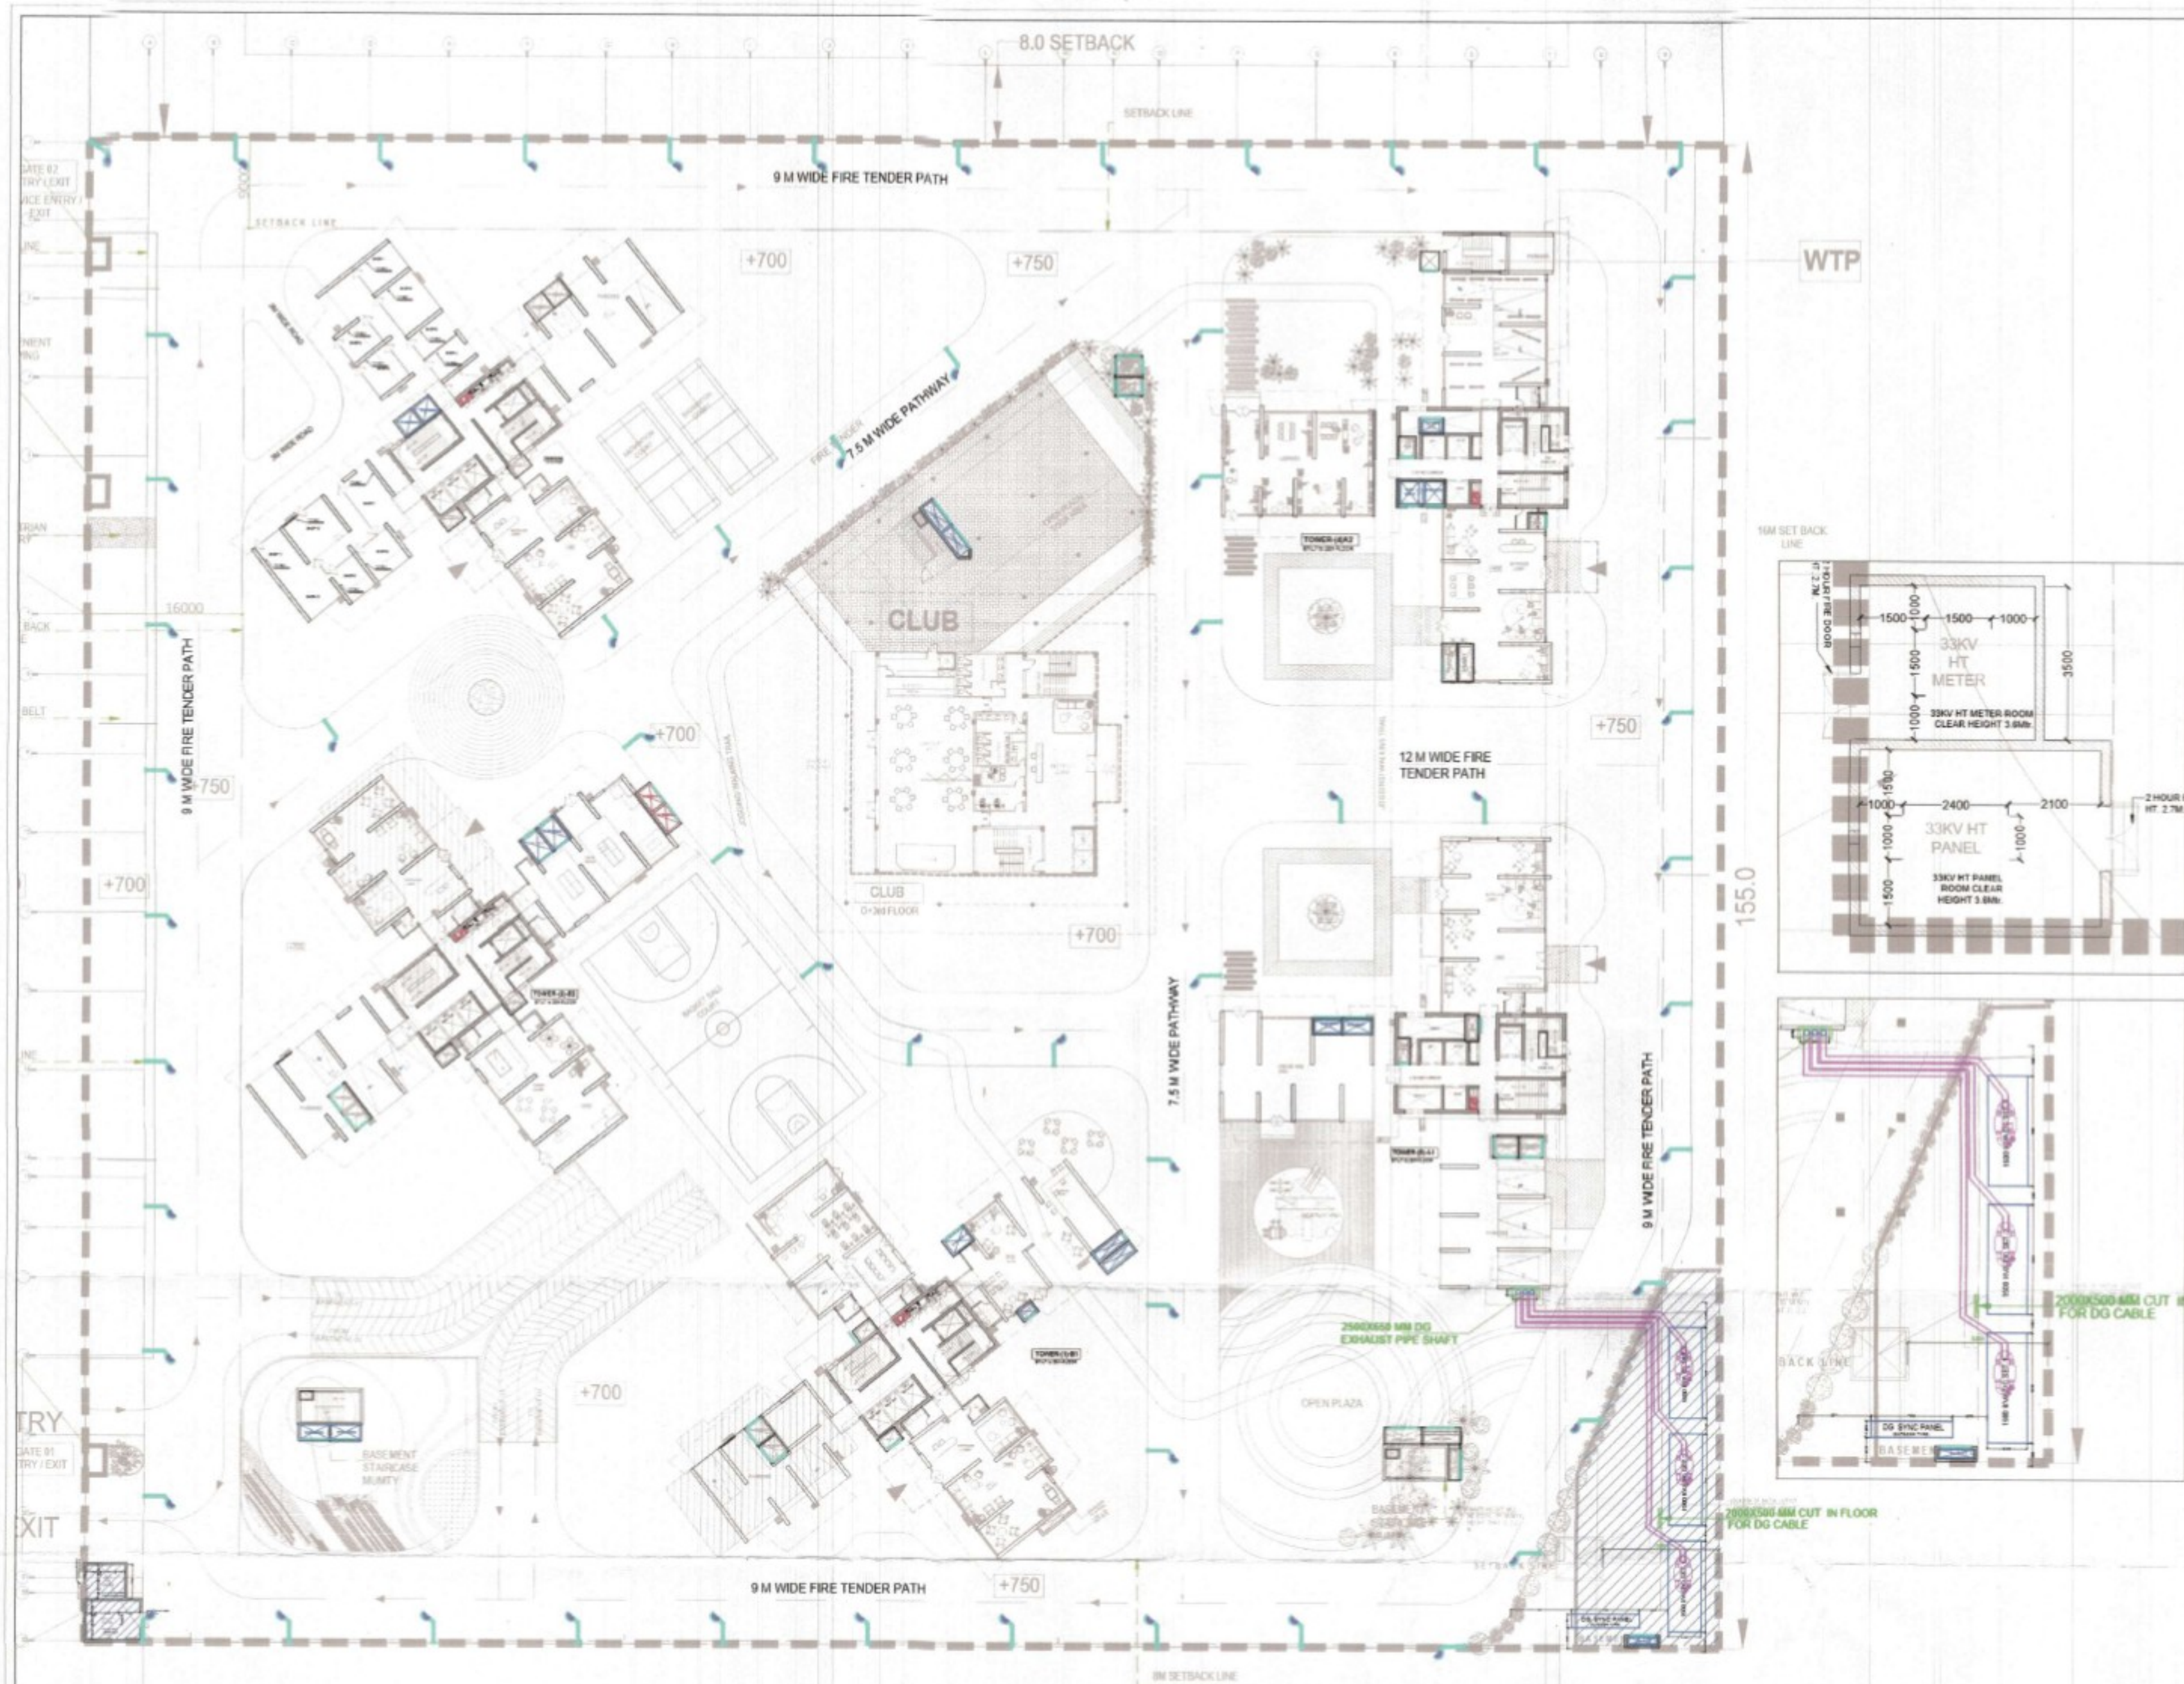


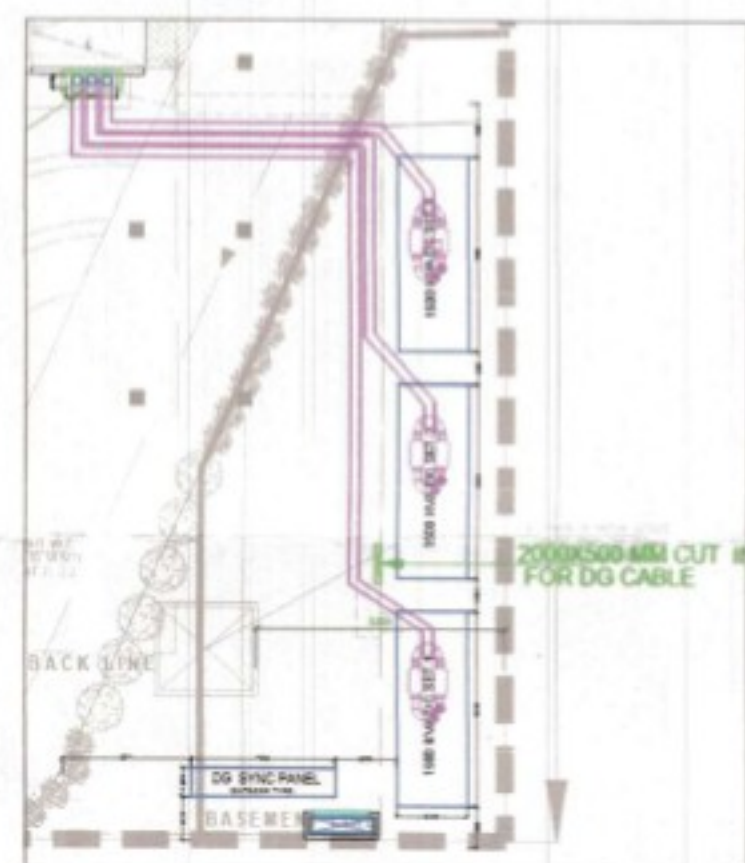

WTP

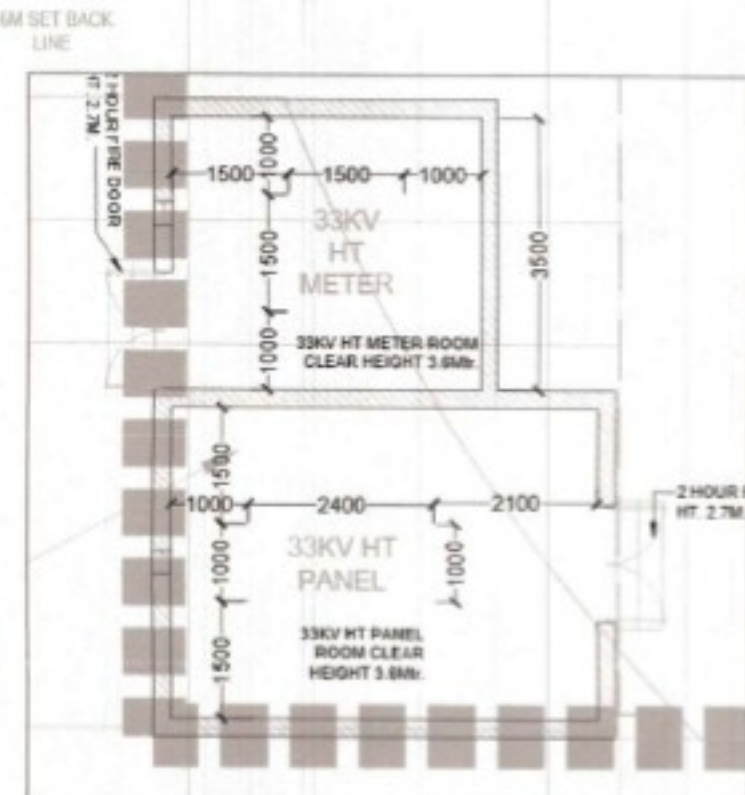

KEY PLAN

For Uppal Chadha Hi-Tech Developers Pvt. Ltd.

[Signature]
 Nriaj Kumar Nanda, Architect
 Council of Architecture
 Registration No. CA/2009/46122

LEGEND
 8M HEIGHT SINGLE ARM STREET LIGHT

Architect :
 Wave Infratech Pvt. Ltd.
 C-1, Sector-3
 Noida, U.P. 201301
 TEL: +91 120 4180500

MEP Consultant

 Find us: electromep.com
 Reach us: projects@electromep.com
 Talk to us: 011 41861394
 Visit us: A222, Ground Floor & Lower Ground Floor
 Shevark Mahiya Nagar, New Delhi - 110017

Structure Consultant

Landscape Consultant


OWNER
 UPPAL CHADHA HITECH DEVELOPERS
 PVT. LTD.

PROJECT
 PROPOSED GROUP HOUSING (VH)
 AT PLOT NO. GH02 PH04 A, AT WAVE CITY
 NH-24 GHAZIABAD (UP)


REV. NO.	DESCRIPTION	DATE
----------	-------------	------

TITLE
 SITE PLAN
 ELECTRICAL LAYOUT

DRAWN: S.A.	DATE: 11.02.2009	REV. NO.
CAD: C.S.		
SCALE: 1:100	EL: 400/100	
DATE: 11.02.2009		
PURPOSE:		

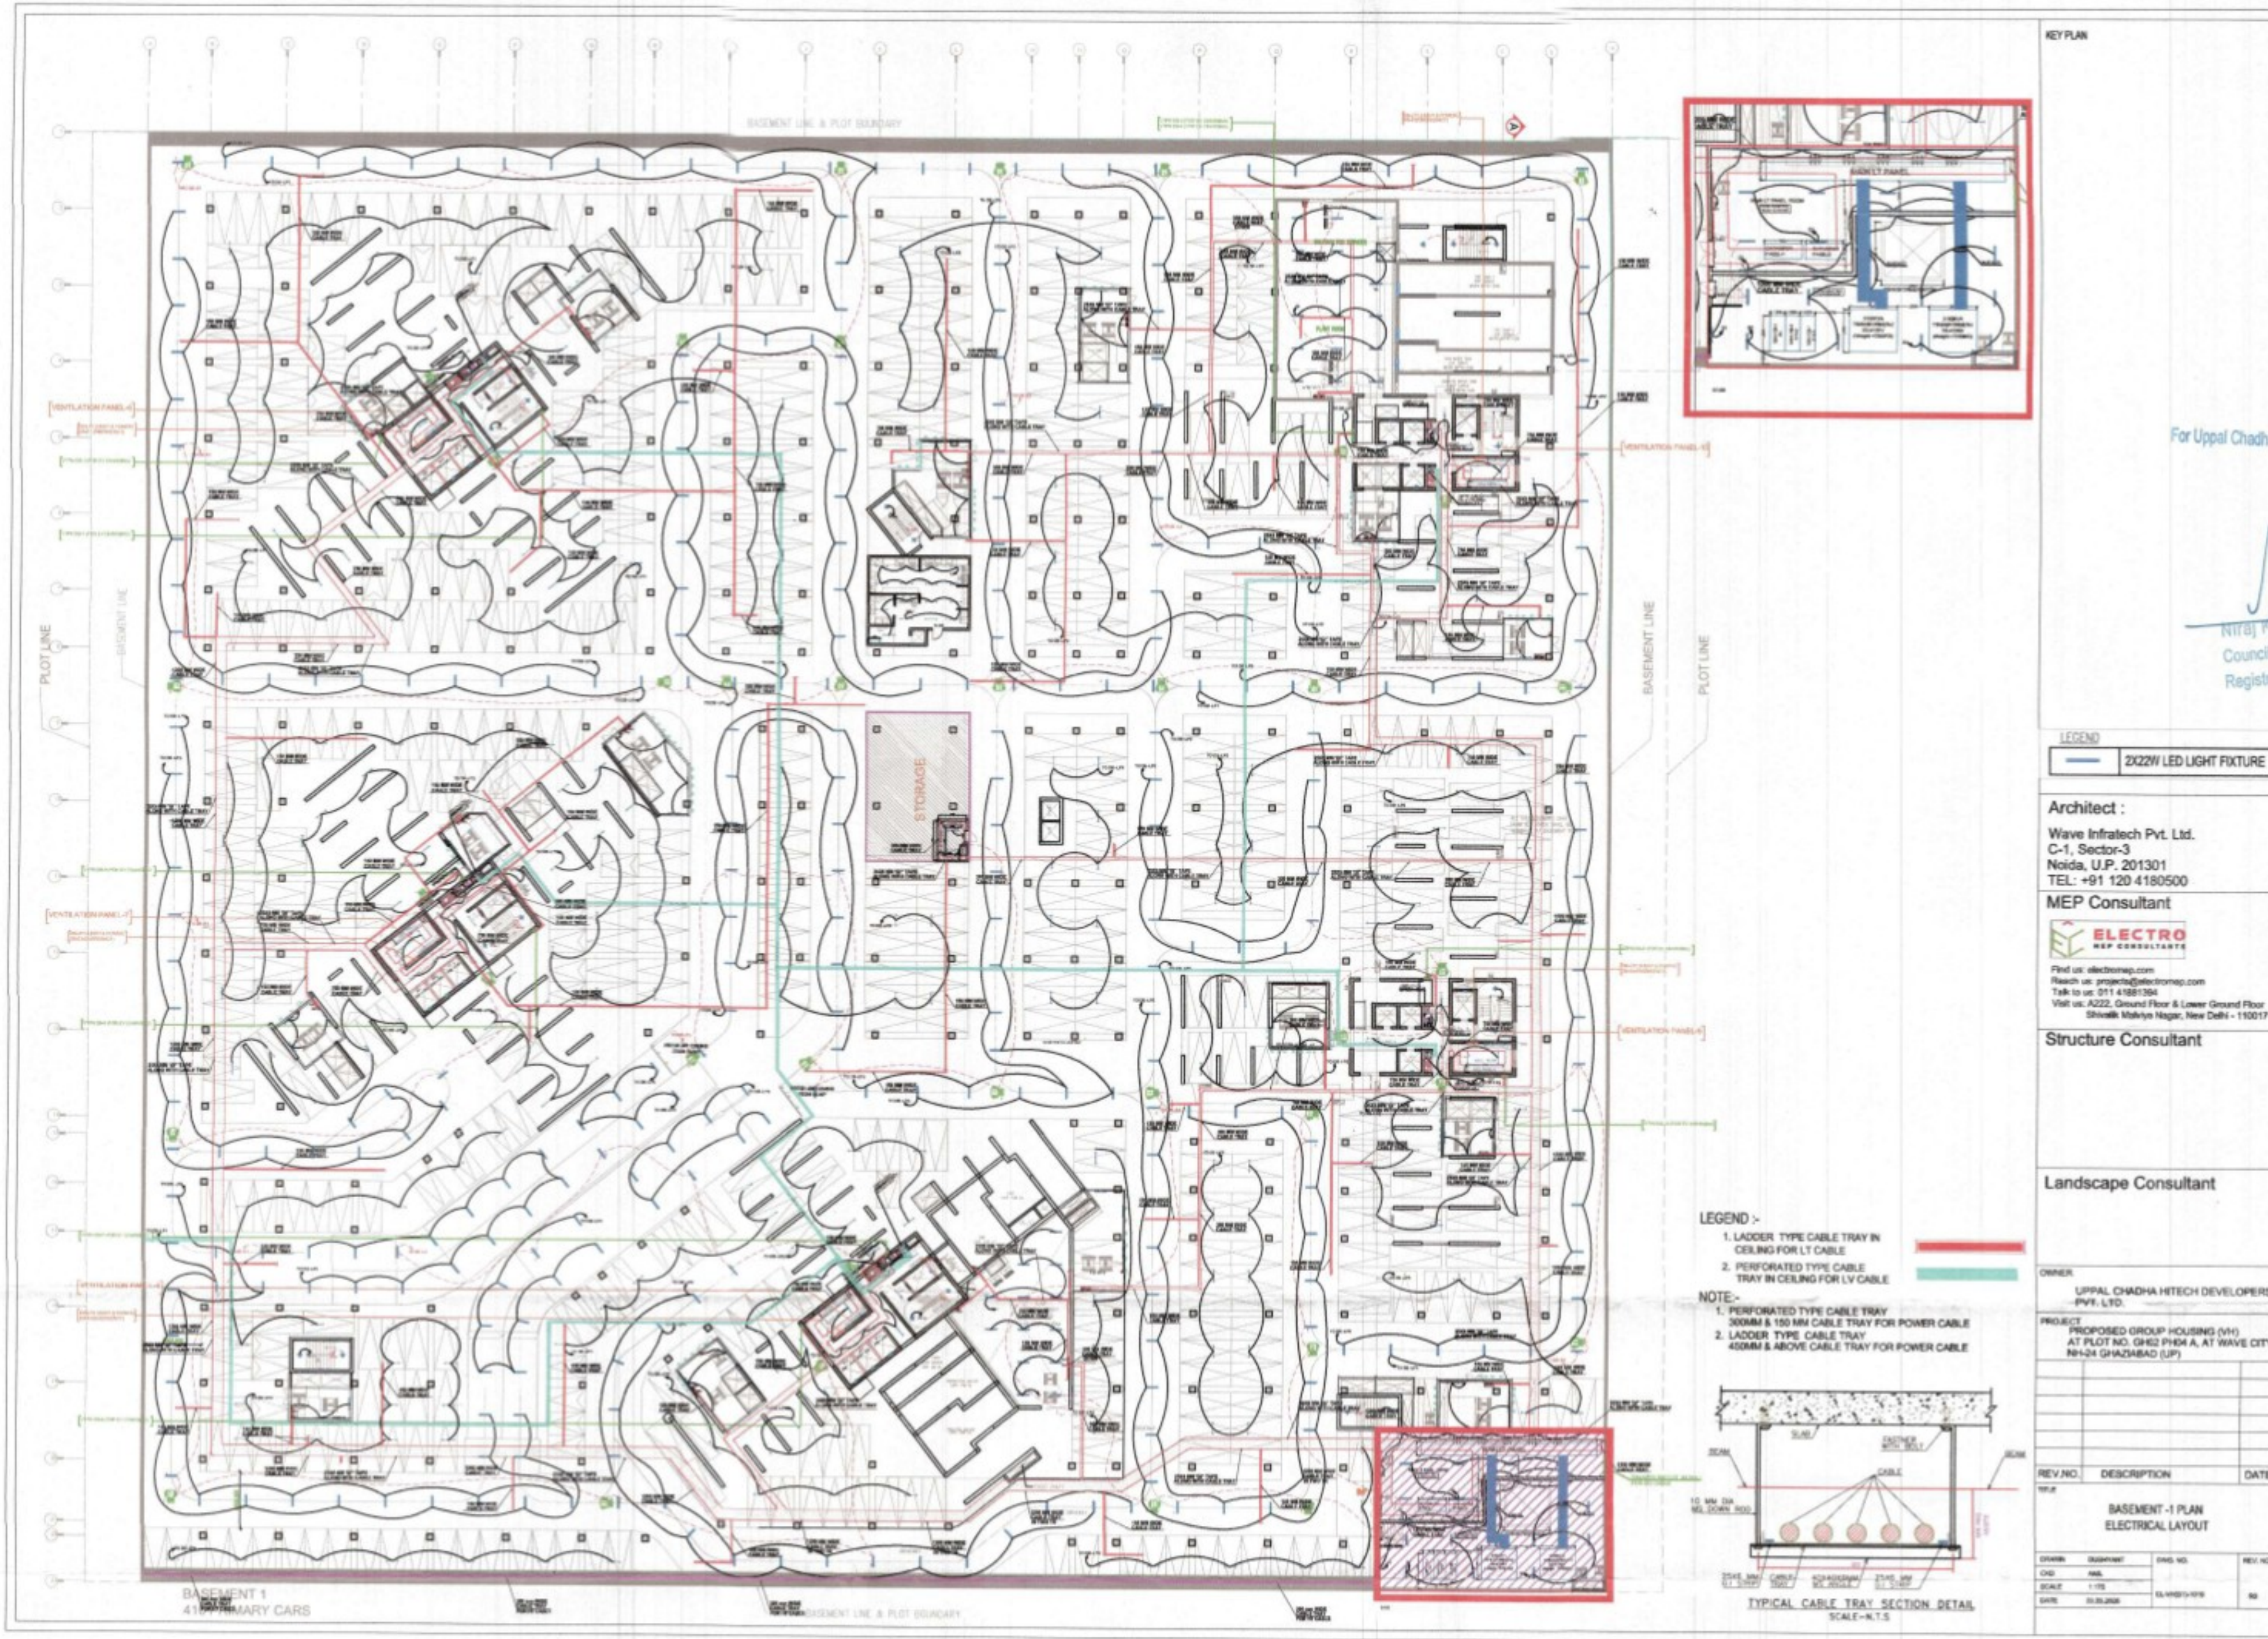

KEY PLAN

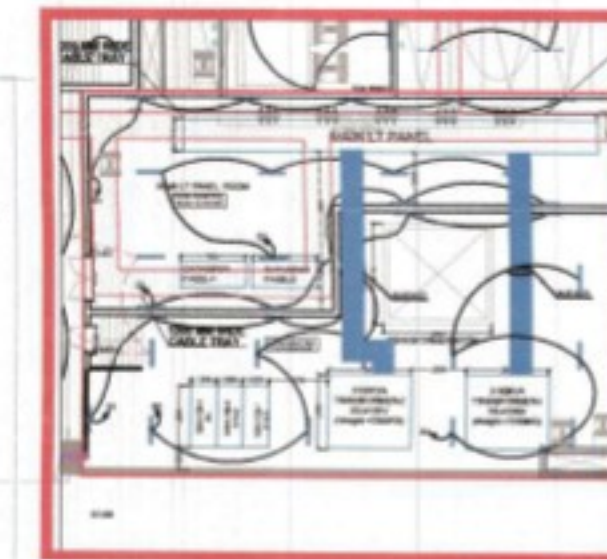

For Uppal Chadha Hi-Tech Developers Pvt. Ltd.

Authorised Signatory

Niraj Kumar Nanda, Architect
Council of Architecture
Registration No. CA/2009/46122

LEGEND

2X22W LED LIGHT FIXTURE

Architect :

Wave InfraTech Pvt. Ltd.
C-1, Sector-3
Noida, U.P. 201301
TEL: +91 120 4180500

MEP Consultant

ELECTRO
MEP CONSULTANTS

Find us: electromap.com
Reach us: projects@electromap.com
Talk to us: 011 41881394
Visit us: A222, Ground Floor & Lower Ground Floor
Shivoli, Mahanagar, New Delhi - 110017

Structure Consultant

Landscape Consultant


OWNER
UPPAL CHADHA HI-TECH DEVELOPERS
PVT. LTD.

PROJECT
PROPOSED GROUP HOUSING (V1)
AT PLOT NO. GH2 PHD A, AT WAVE CITY
NH-24 GHANSHABAD (UP)

REV. NO.	DESCRIPTION	DATE
01		

BASEMENT -1 PLAN
ELECTRICAL LAYOUT


DATE	DESIGNER	DATE	REV. NO.
01.08.2020	MM	01.08.2020	01

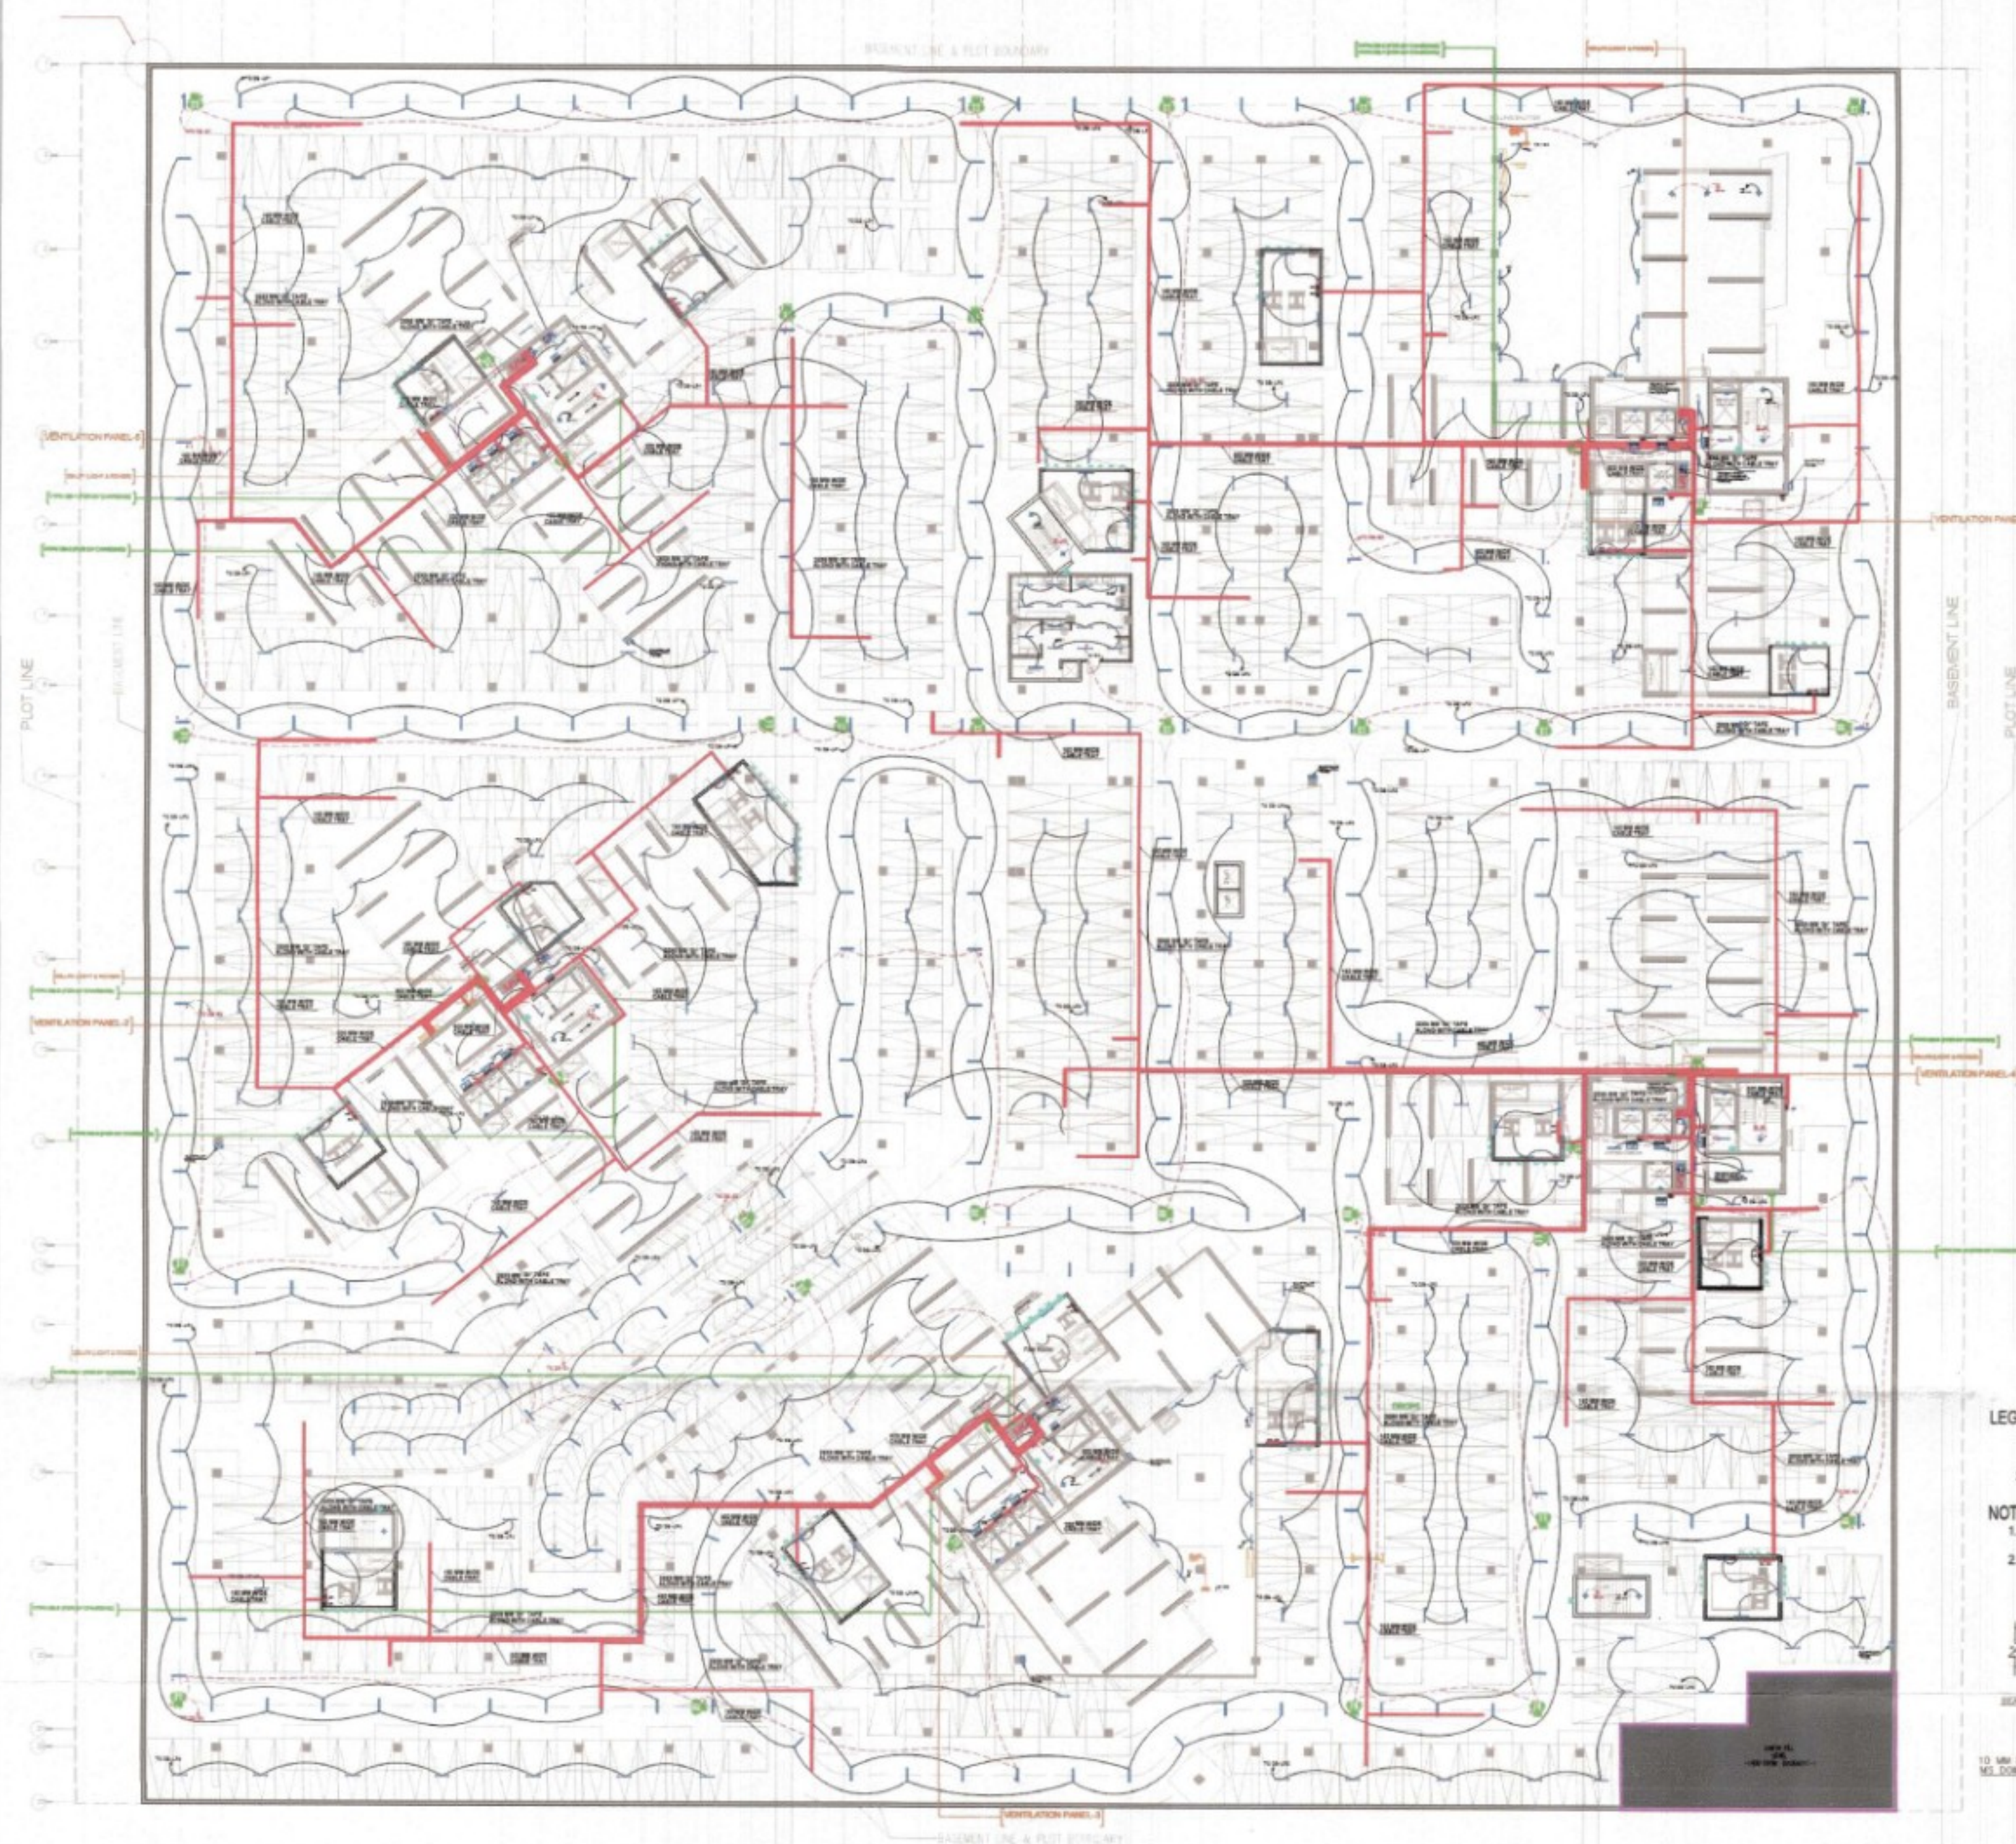

BASEMENT 2
419 PRIMARY CARS

- LEGEND -**
- 1. LADDER TYPE CABLE TRAY IN CEILING FOR LT CABLE
 - 2. PERFORATED TYPE CABLE TRAY IN CEILING FOR LV CABLE

- NOTE -**
- 1. PERFORATED TYPE CABLE TRAY 300MM & 150 MM CABLE TRAY FOR POWER CABLE
 - 2. LADDER TYPE CABLE TRAY 400MM & ABOVE CABLE TRAY FOR POWER CABLE

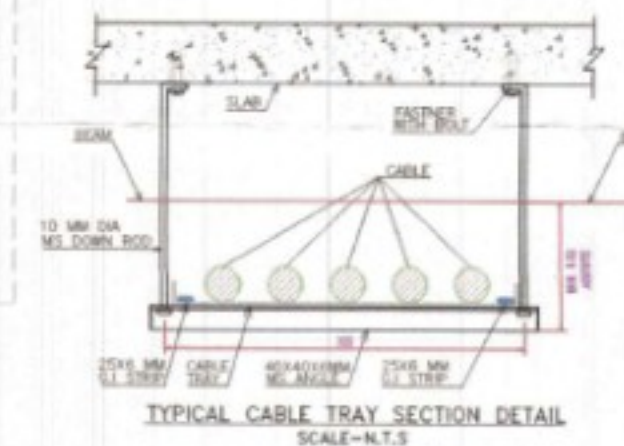

KEY PLAN

For Uppal Chadha Hi-Tech Developers Pvt. Ltd.

 Nisha Kumar Nanda, Architect
 Council of Architecture
 Registration No. CA/2009/16122

LEGEND
 2X22W LED LIGHT FIXTURE

Architect :
 Wave Infotech Pvt. Ltd.
 C-1, Sector-3
 Noida, U.P. 201301
 TEL: +91 120 4180500

MEP Consultant

 Find us: electromep.com
 Reach us: projects@electromep.com
 Talk to us: 011 41681394
 Visit us: A222, Ground Floor & Lower Ground Floor
 Shivaji Mahila Nagar, New Delhi - 110017

Structure Consultant

Landscape Consultant

OWNER
 UPPAL CHADHA HITECH DEVELOPERS
 PVT. LTD.

PROJECT
 PROPOSED GROUP HOUSING (VH)
 AT PLOT NO. GH02 PH04 A, AT WAVE CITY
 NH-24 GHAZIABAD (UP)

REV. NO.	DESCRIPTION	DATE
TITLE		

**BASEMENT -2 PLAN
ELECTRICAL LAYOUT**

DRAWN	CHECKED	DWG. NO.	REV. NO.
CAD	ANL		
SCALE	1:125	SL-0802-1918	02
DATE	23-03-2020		
PURPOSE			